


HAZELDEAN ROAD

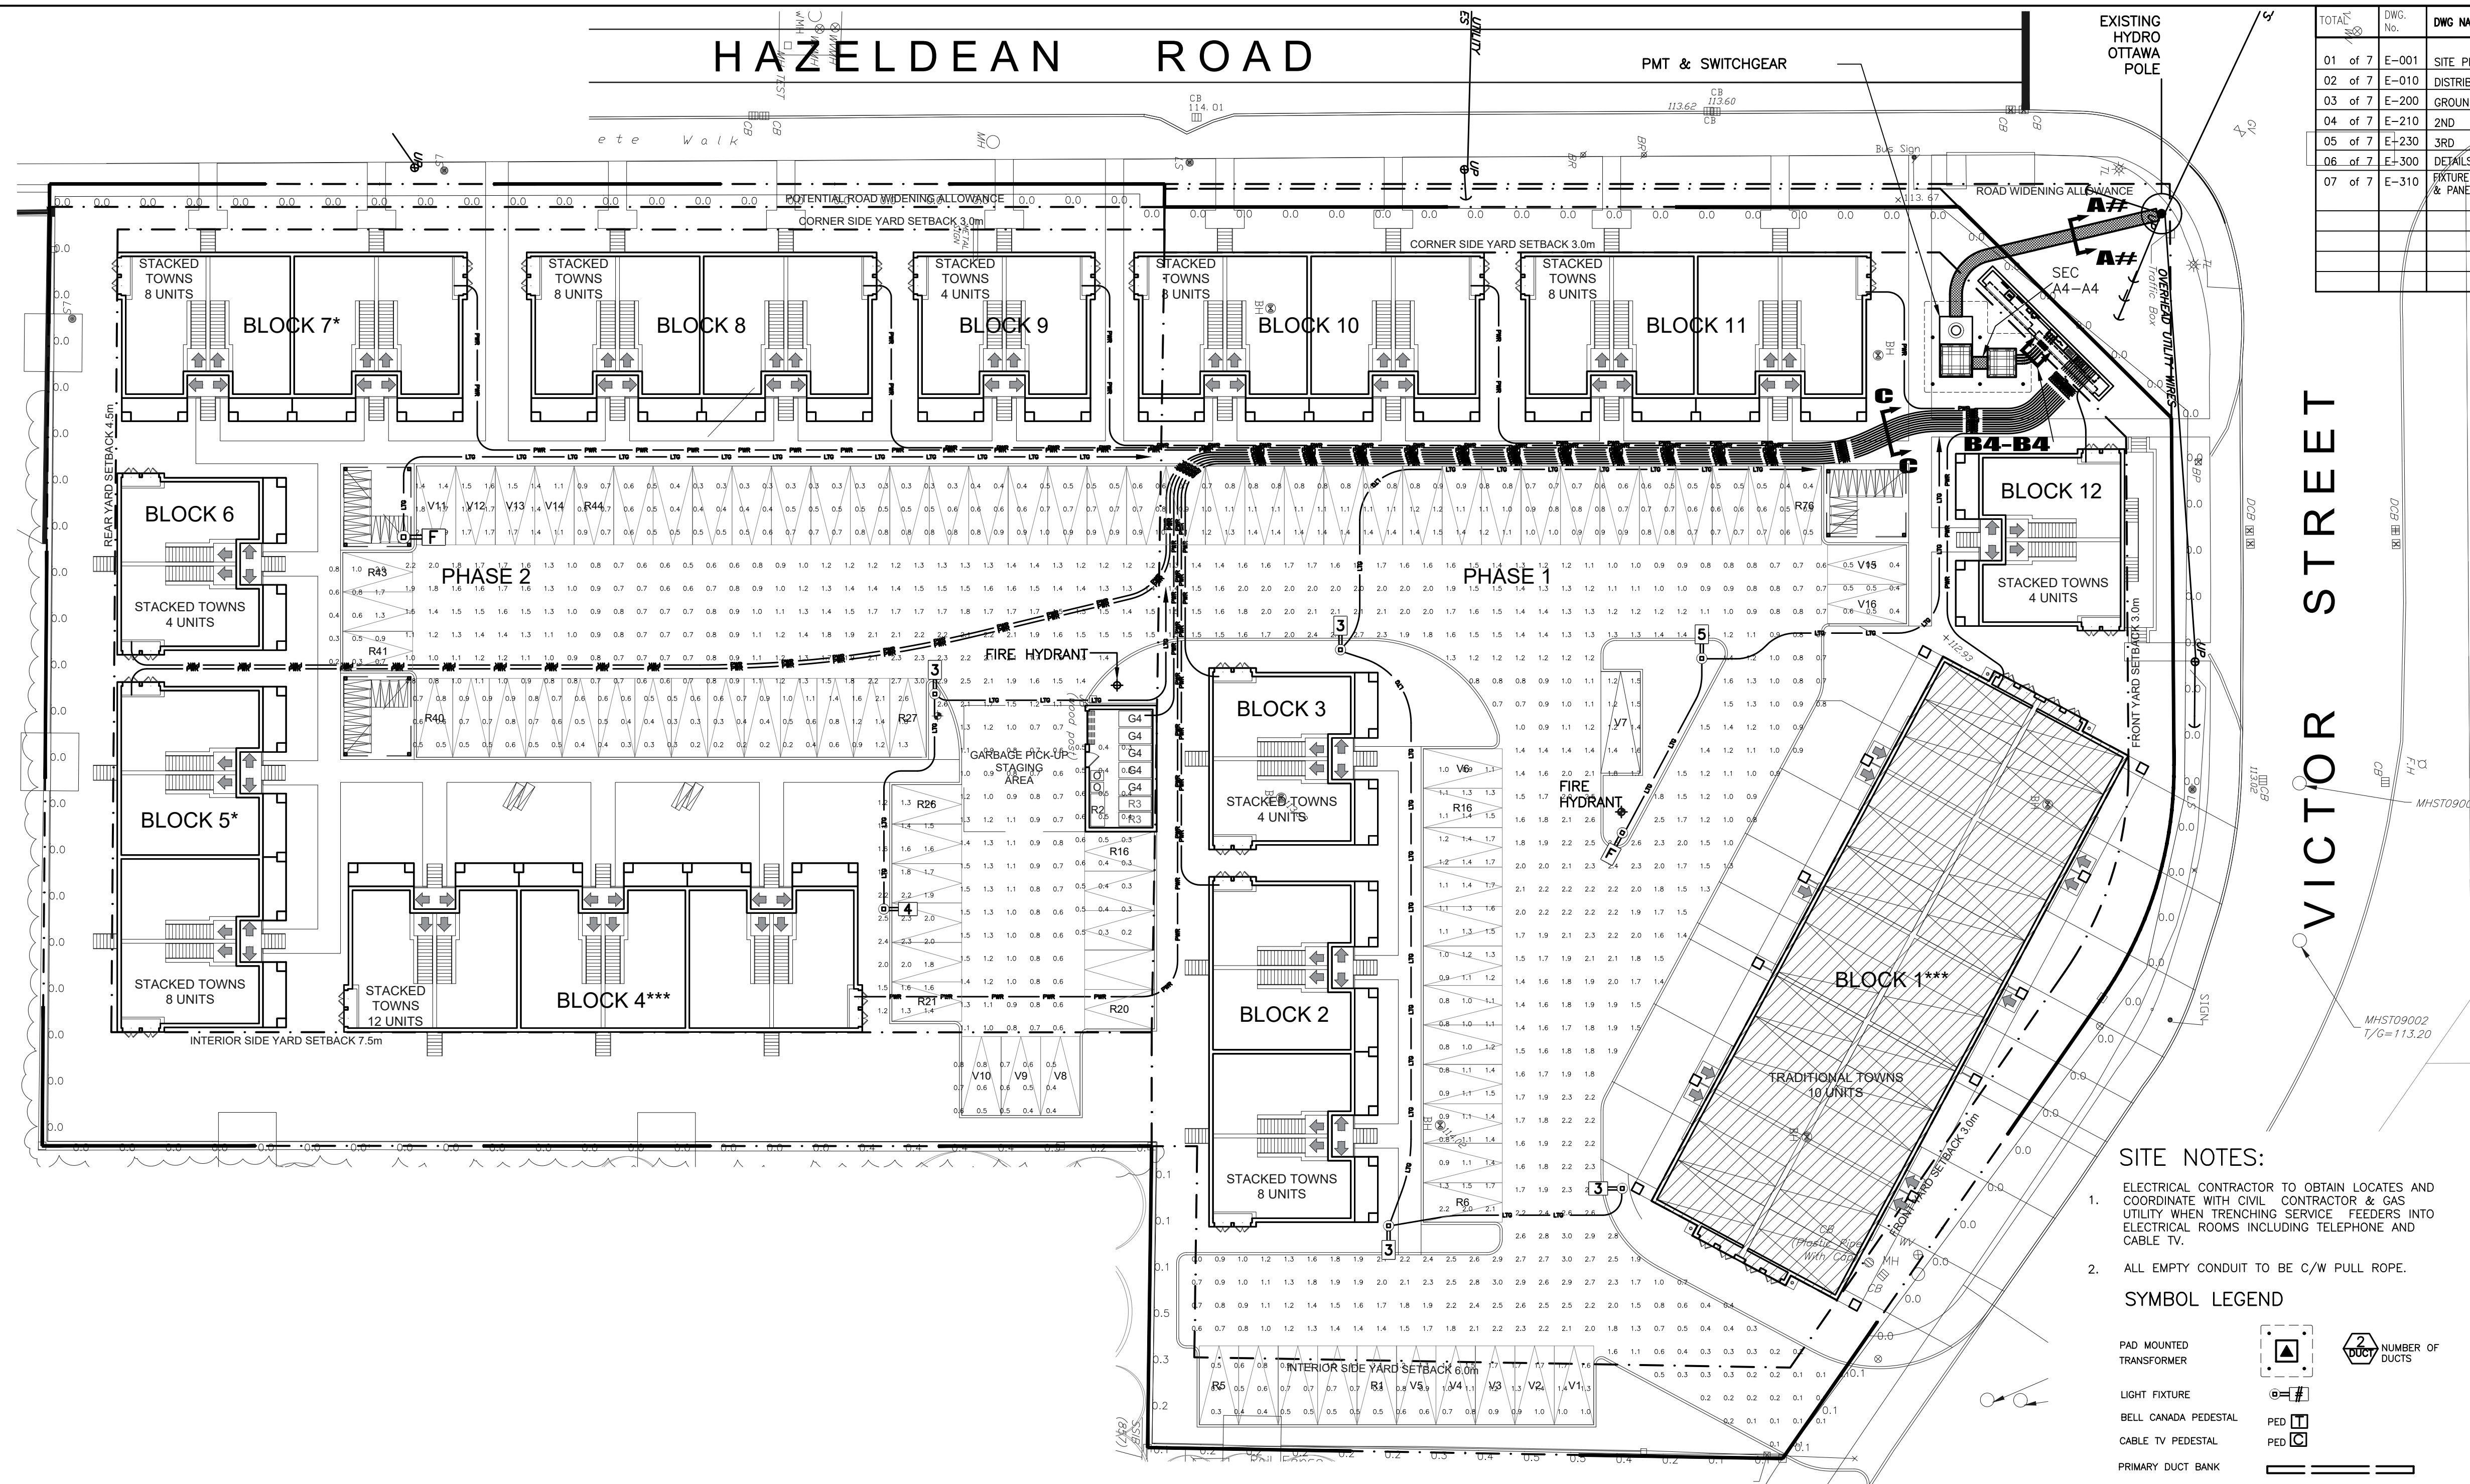

TOTAL	DWG. No.	DWG. NAMES
01 of 7	E-001	SITE PLAN
02 of 7	E-010	DISTRIBUTION
03 of 7	E-200	GROUND
04 of 7	E-210	2ND
05 of 7	E-230	3RD
06 of 7	E-300	DETAILS
07 of 7	E-310	FIXTURE LIST & PANELS

THIS DRAWING, OR PARTS THEREOF, MAY NOT BE REPRODUCED OR USED IN ANY FORM, BY ANY METHOD, FOR ANY PURPOSE, WITHOUT THE WRITTEN PERMISSION OF QUADRANT ENGINEERING.

THIS DRAWING IS TO BE READ IN CONJUNCTION WITH THE SPECIFICATION, WHERE CONFLICT ARISES THE MORE STRINGENT OF THE TWO SHALL APPLY.

COPYRIGHT © 2019 QUADRANT ENGINEERING.

THE ELECTRICAL CONTRACT DOCUMENTS ARE THE PROPERTY OF QUADRANT ENGINEERING LIMITED (QEL)

THE CONTRACTOR SHALL OBTAIN A FULL SET OF ALL CONSULTANTS' DESIGN DOCUMENTS PRIOR TO STARTING WORK.

QEL BEARS NO RESPONSIBILITY FOR INTERPRETATIONS OF THESE DOCUMENTS BY OTHERS.

UPON WRITTEN APPLICATION QEL WILL PROVIDE WRITTEN CLARIFICATION REGARDING THE INTENT OF THE CONTRACT DOCUMENTS.

QEL REVIEW OF SHOP DRAWINGS SUBMITTED BY THE CONTRACTOR IS FOR DESIGN CONFORMANCE ONLY.

DRAWINGS ARE NOT TO BE SCALED FOR CONSTRUCTION. CONTRACTOR TO VERIFY ALL CONDITIONS AND DIMENSIONS, ON SITE, REQUIRED TO PERFORM THE WORK AND REPORT ANY DISCREPANCIES WITH THE CONTRACT DOCUMENTS TO THE DESIGN TEAM BEFORE COMMENCING WORK.

SITE PLAN LIGHTING:

NOTE FOR POWER TO POLE LIGHTS & Pylon SIGNS: ALL CONDUIT LABELED "T" TO BE BURED AS PER DETAIL, SEC 5B - TO BE [2"] RIGID PVC CONDUIT C/W [#8 AWG] + BOND.

SYMBOL

- SITE NOTES:**
- ELECTRICAL CONTRACTOR TO OBTAIN LOCATES AND COORDINATE WITH CIVIL CONTRACTOR & GAS UTILITY WHEN TRENCHING SERVICE FEEDERS INTO ELECTRICAL ROOMS INCLUDING TELEPHONE AND CABLE TV.
 - ALL EMPTY CONDUIT TO BE C/W PULL ROPE.

SYMBOL LEGEND

PAD MOUNTED TRANSFORMER		NUMBER OF DUCTS	
LIGHT FIXTURE			
BELL CANADA PEDESTAL			
CABLE TV PEDESTAL			
PRIMARY DUCT BANK			
SECONDARY POWER			
POWER TO BOLLARDS			
TELEPHONE CONDUIT			
CABLE T.V. CONDUIT			

Site Label	Label	MANUFACTURER	Description	WATTS	LUMENS
5	P2-T5W	Lithonia Lighting	DSX1 LED P2 30K T5W MVOLT	70	8516
4	P2-T4M	Lithonia Lighting	DSX1 LED P2 30K T4M MVOLT	70	8082
3	P2-T3M	Lithonia Lighting	DSX1 LED P2 30K T3M MVOLT	70	8021
F	P2-TFTM	Lithonia Lighting	DSX1 LED P2 30K TFTM MVOLT	70	8257

- TRENCH BURIAL NOTES:**
- WHEN CROSSING ROADS, PARKING LOTS & SIDEWALKS: REINSTATE SURFACE TO MATCH ADJACENT SURFACE
 - WHEN CROSSING GRASS: SEEDING OR SOD BY OTHERS.
 - WARNING TAPE (BURIED AS-PER OESC) (BELOW FINISHED GRADE)
 - WHEN CROSSING SIDEWALK OR SOD: APPROVED BACKFILL (AND/OR SCREENED NATIVE FILL)- COMPACTED C/W 150mm SCREENED TOPSOIL TO GRADE.
 - WHEN CROSSING ROADS OR PARKING LOTS: BACKFILL WITH GRANULAR 'B' FILL- COMPACT TO 95% PROCTOR IN 150mm LAYERS.

NO.	REVISION	DATE	BY
5	RE-ISSUED FOR PERMIT	11 OCT, 2019	RL
4	PROGRESS FOR PRICING	30 SEP, 2019	RL
3	ISSUED FOR PERMIT	23 AUG, 2019	RL
2	ISSUED FOR COORDINATION	21 JUL, 2019	RL
1	ISSUED FOR PROGRESS	31 JUL, 2019	RL

HAZELDEAN CROSSING TOWNS
5924 HAZELDEAN ROAD

OTTAWA, ONTARIO



QUADRANT
an Intelectic Company

2283 ST. LAURENT BLVD., UNIT 203, OTTAWA, ONT., K1G 5A2
TEL: (613) 567-1487 FAX: (613) 567-1493
E-Mail: mail@quadrantengineering.ca

DATE	SCALE
11 OCT, 2019	1:250
DRAWN	RL
DESIGNED	AS
CHECKED	AS
PROJECT	19029
DRAWING NUMBER	E-001

ELECTRICAL SITE PLAN LIGHTING