



**LEGEND**

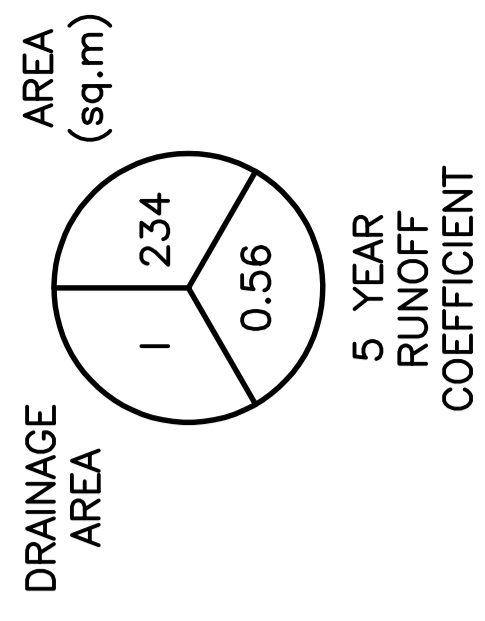

**KEY PLAN**

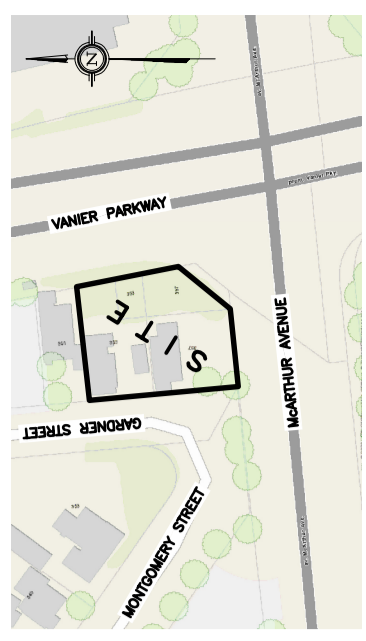

No.	DATE	REVISION
2	JUN 26-20	ISSUED FOR APPROVAL
1	JUN 24-20	ISSUED FOR COORDINATION

**D. B. GRAY ENGINEERING INC.**  
 Supervisor/Manager: Consulting & Draining - Storm & Sanitary Sewer - Stormwater  
 700 Long Point Circle  
 Ottawa, Ontario      d.gray@dbgrayengineering.com  
 613-425-8044

**Project**  
 PROPOSED 9-STORY  
 61-UNIT APARTMENT  
 BUILDING  
 353-357 GARDNER STREET  
 OTTAWA, ONTARIO

**DRAINAGE PLAN**

Engineer's Seal  
  
 NOT VALID UNLESS SIGNED & DATED

Drawn: D.B.G.  
 Horz. Scale: 1:100  
 Vert. Scale:  
 Date: MAY 29-20  
 Rev. No.: 20037

Drawing No.  
**C-6**  
 of 6

