


Copyright Reserved

The Contractor shall verify and be responsible for all dimensions. DO NOT scale the drawing - any errors or omissions shall be reported to Stantec without delay. The Copyrights to all designs and drawings are the property of Stantec. Reproduction or use for any purpose other than that authorized by Stantec is forbidden.

Legend

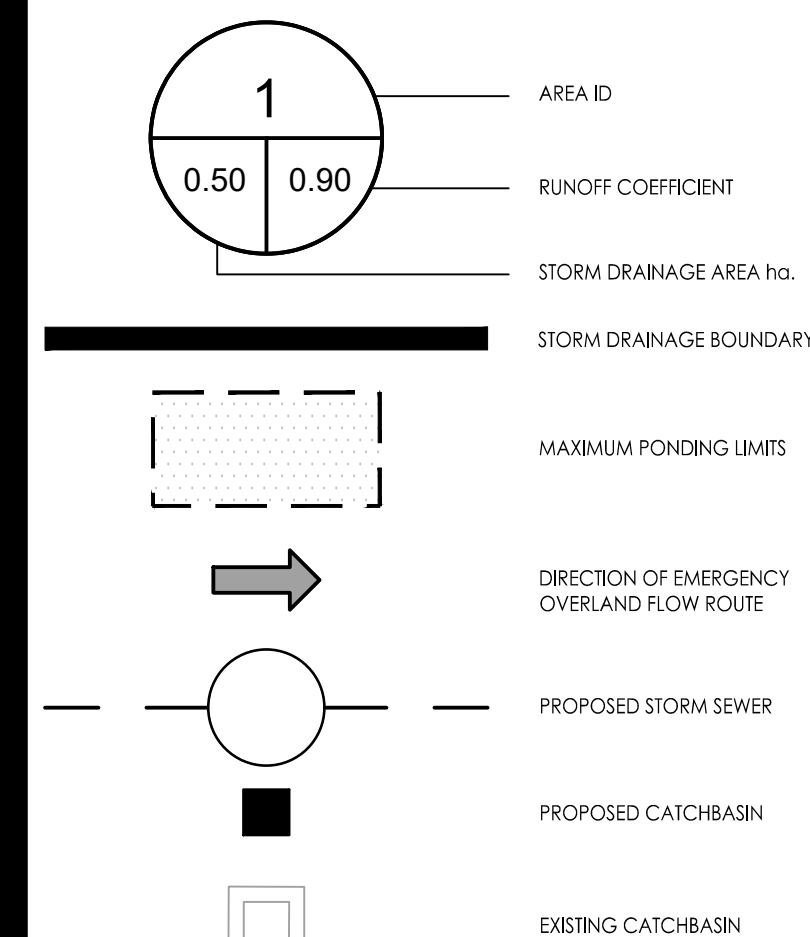

Notes

Revision	By	Appd.	Date
1	JP	KK	20.10.01
2	JP	KK	20.07.03

Permit-Seal	Drawn	Checked	Designed	Date
	JP	KK	JP	20.07.03




Client/Project
TC UNITED DEVELOPMENT CORP.
800 INDUSTRIAL AVENUE UNIT 9-100
6 STORY MIXED USE BUILDING
1155 JOSEPH CYR STREET
OTTAWA, ONTARIO

Title
STORM DRAINAGE PLAN

Project No. 160401587	Scale 1:150	Sheet 5 of 5	Revision 1
--------------------------	----------------	-----------------	---------------

SD-1

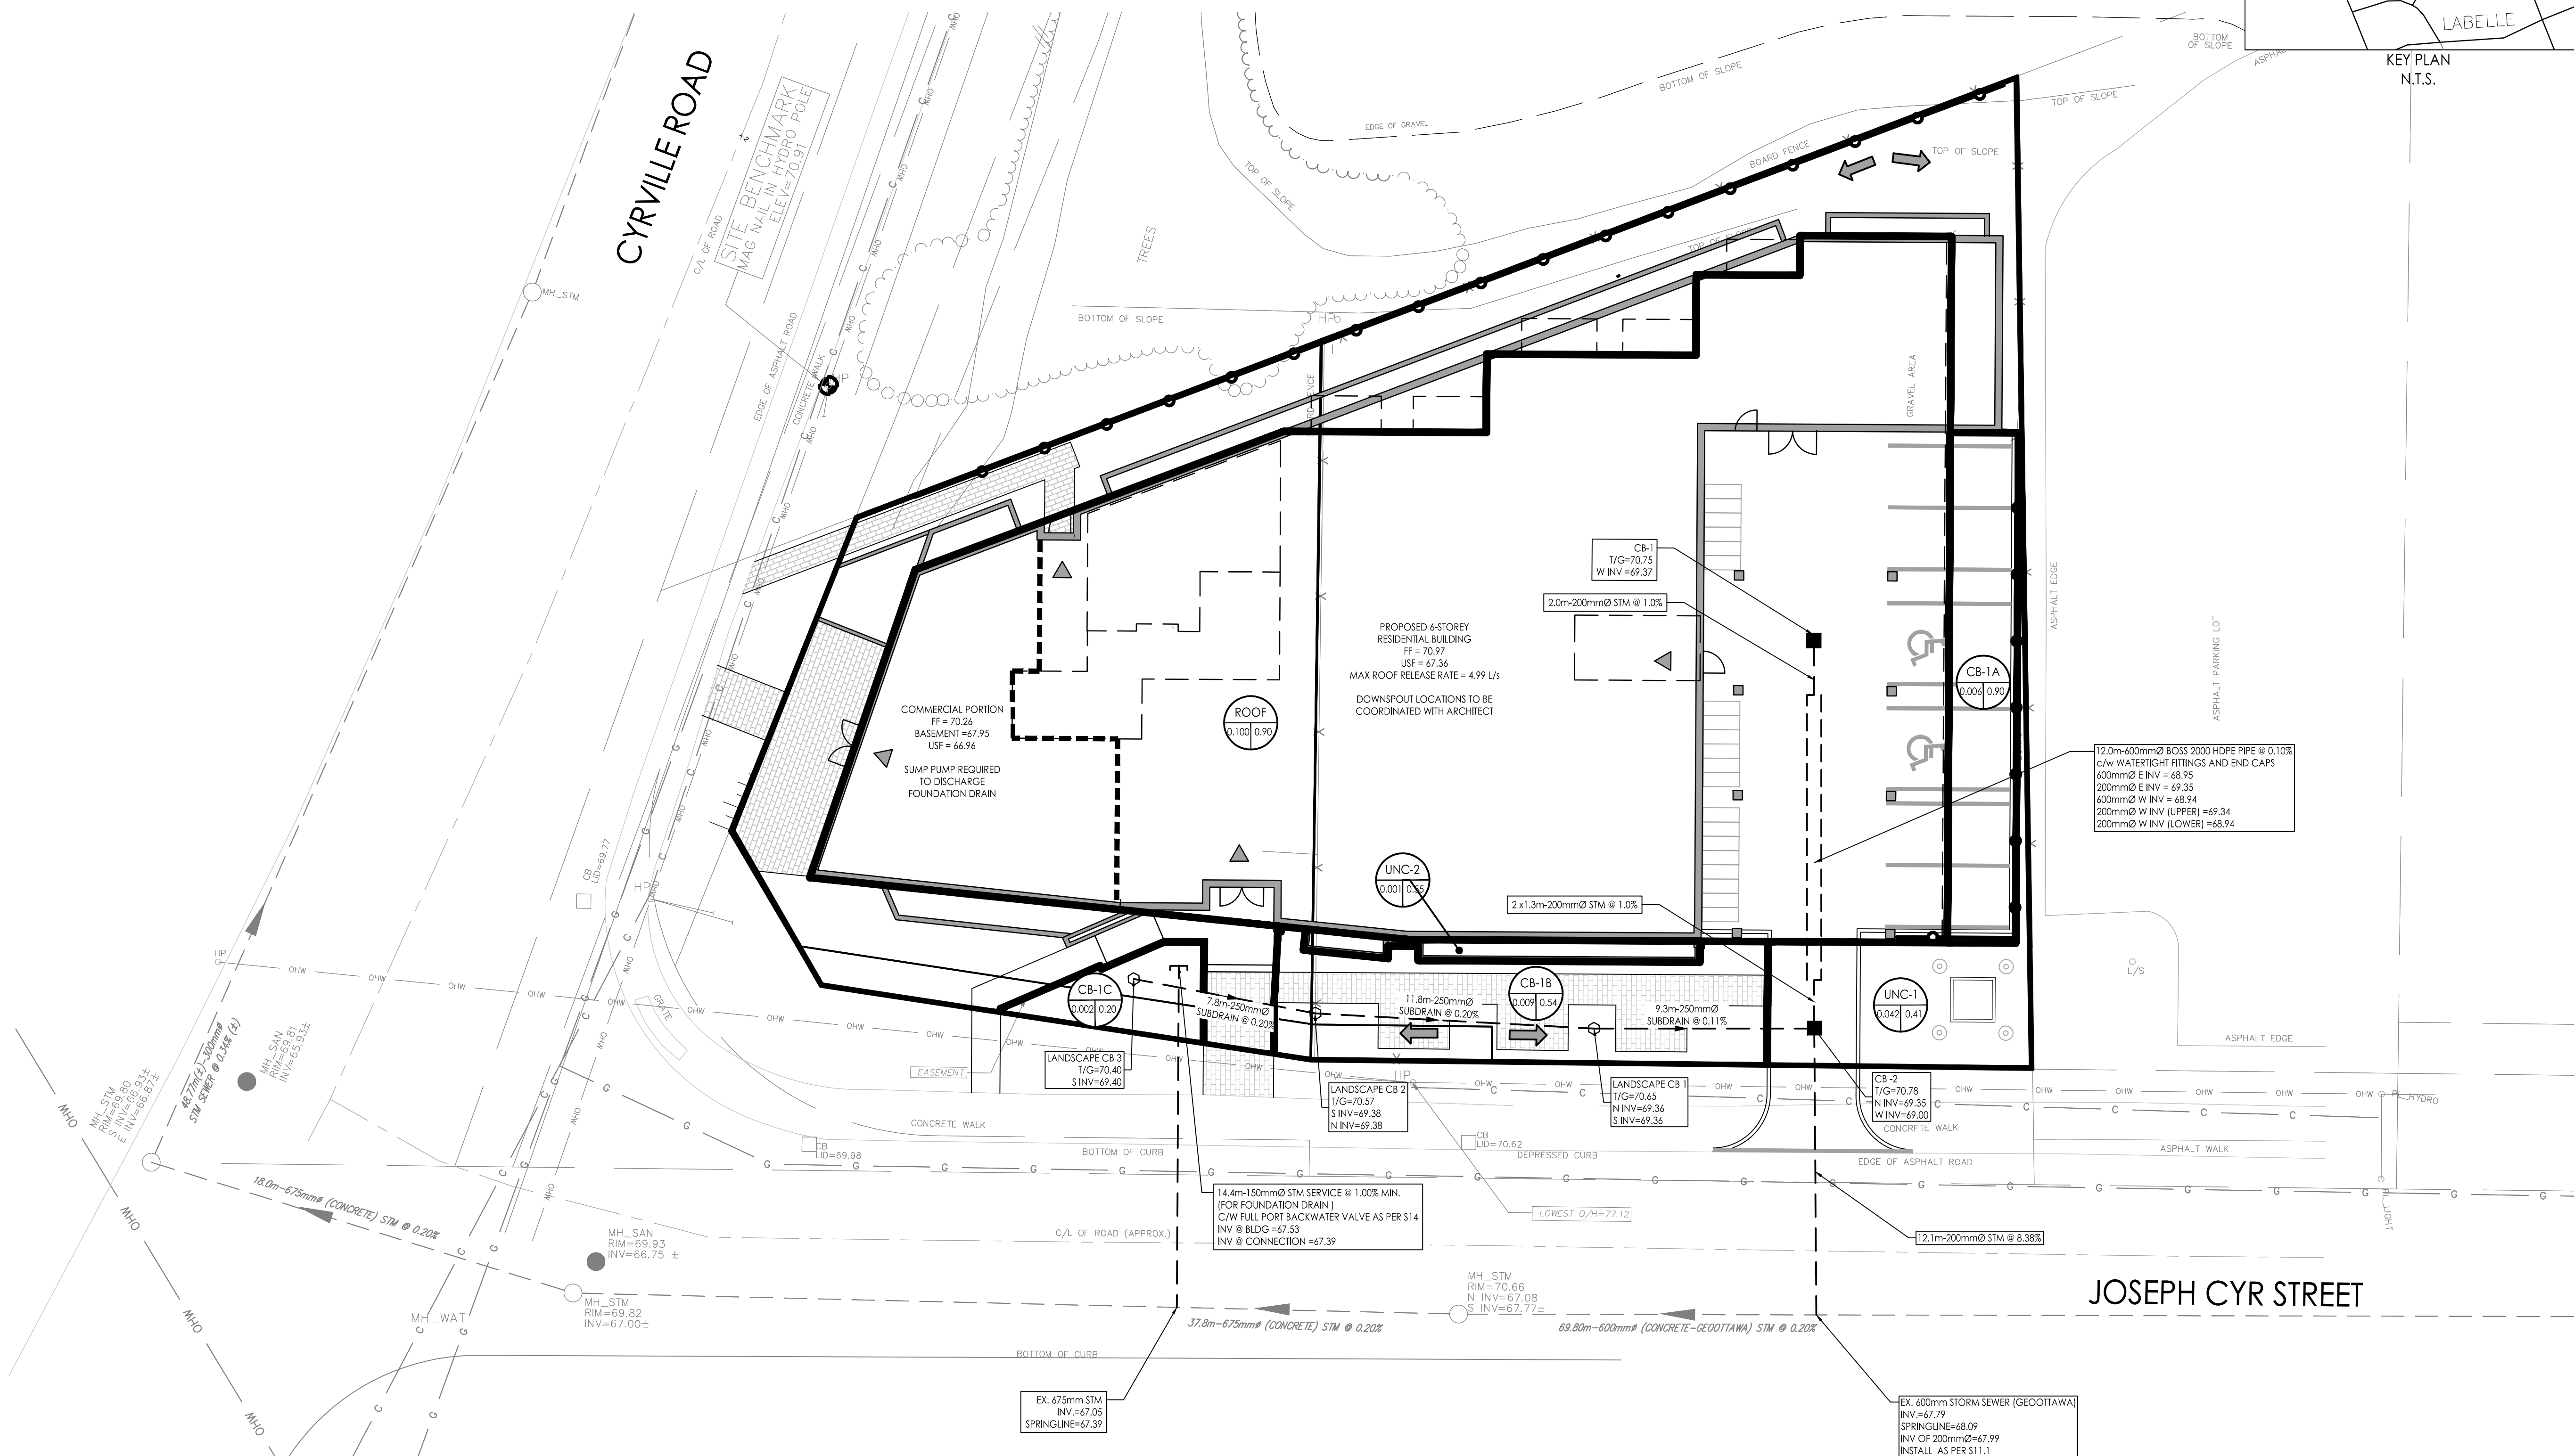

DRAINAGE AREA ID	STRUCTURE ID	ORIFICE TYPE	100YR HEAD (m)	100YR RELEASE RATE (L/S)
CB-1A, CB-1B, CB-1C	CB-2	IPEX TEMPEST UMF 100	0.53	6.52

W:\Projects\160401587\160401587.dwg
 2020-10-01 11:56 AM
 ORIGINAL SHEET - ARCH D