


Client

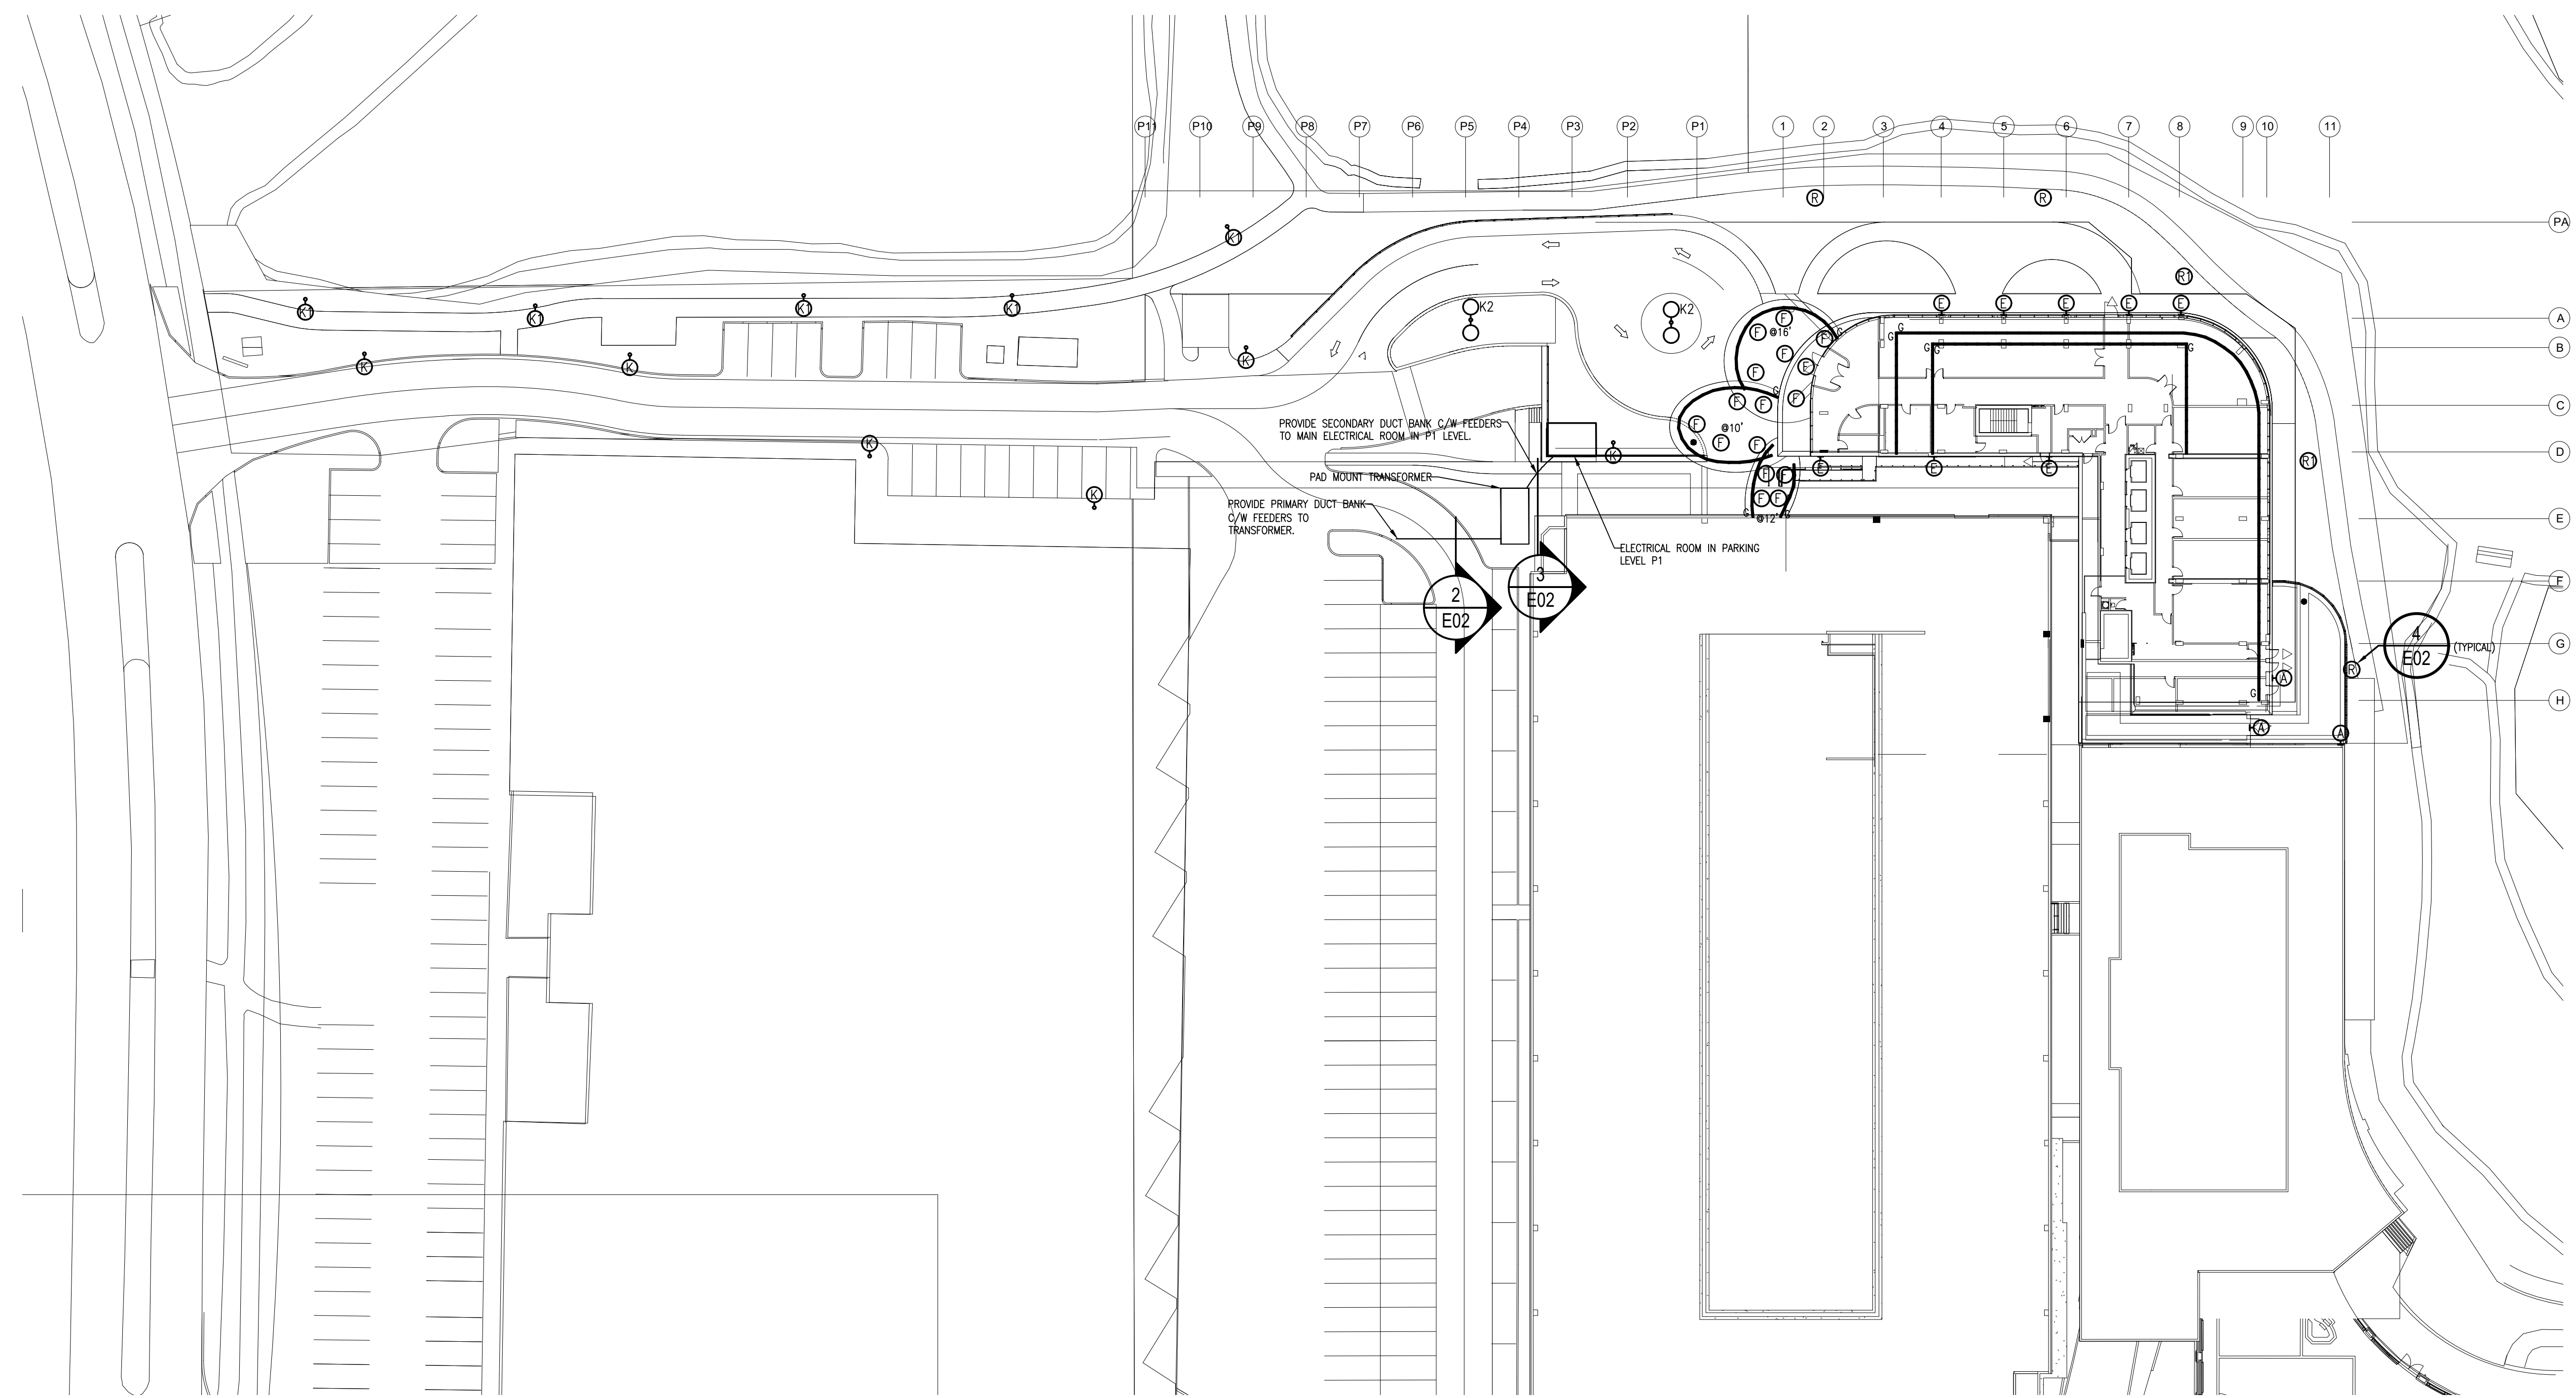

DATE	REVISION	REF
2021-10-04	ISSUED FOR SITE PLAN APPROVAL	-
2021-07-20	ISSUED FOR HYDRO OTTAWA	-

THE ENGINEER WAIVES ANY AND ALL RESPONSIBILITY AND LIABILITY FOR PROBLEMS WHICH ARISE FROM FAILURE TO FOLLOW THESE PLANS, SPECIFICATIONS AND THE DESIGN INTENT THEY CONVEY, OR FOR PROBLEMS WHICH ARISE FROM OTHER FAILURE TO OBTAIN AND / OR FOLLOW THE ENGINEER'S GUIDANCE WITH RESPECT TO ANY ERRORS, OMISSIONS, INCONSISTENCIES, AMBIGUITIES OR CONFLICTS WHICH ARE ALLEGED.

THIS DRAWING IS THE PROPERTY OF GOODKEY WEEDMARK & ASSOCIATES LIMITED AND ALL COPYRIGHTS ARE RESERVED. NO USE OF THIS DRAWING MAY BE MADE WITHOUT EXPRESS WRITTEN CONSENT.

DO NOT SCALE DRAWINGS

L'INGÉNIEUR DÉCLINE TOUTE RESPONSABILITÉ DÉCOULANT DE PROBLÈMES FAISANT SUITE AU NON RESPECT DES PLANS, DES SPÉCIFICATIONS ET DE L'INTENTION DU CONCEPT QU'ILS INDIQUENT OU DE TOUTS LES PROBLÈMES POUVANT RÉSULTER DU DÉFAUT D'OBTENIR ET / OU DE SUIVRE LES CONSEILS DE L'INGÉNIEUR EN CE QUI CONCERNE LES ERREURS, OMISSIONS, INCONSISTENCES, AMBIGUITÉS OU CONFLITS ALLÉGUÉS.

CE Dessin est la propriété littéraire de Goodkey Weedmark & Associates Limited et tous les droits sont réservés. L'utilisation est interdite sans le consentement écrit de l'auteur.

NE PAS MESURER LES Dessins à l'échelle

Goodkey Weedmark
Consulting Engineers


GOODKEY WEEDMARK & ASSOCIATES LIMITED
1688 Woodward Dr. Ottawa Ontario Canada K2C 3R8
613 727-5111 Voice
613 727-5115 Fax
www.gwal.com Web

Project north
Nord du projet


Seal/Scell

LICENSED PROFESSIONAL ENGINEER
H. ROMANI
100508102
OCT 4
PROVINCE OF ONTARIO


1 ELECTRICAL LAYOUT-SITE PLAN
1:400

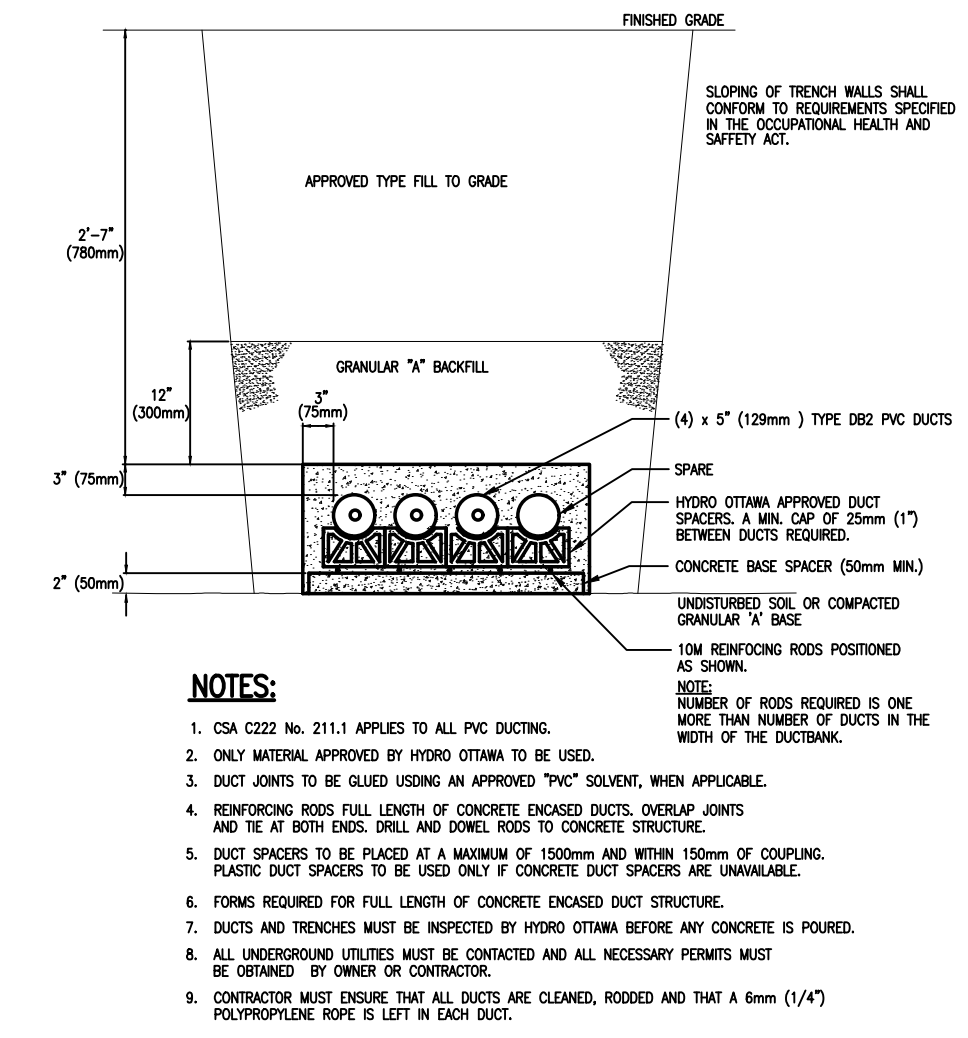

2 4-CELL PRIMARY CONCRETE DUCTBANK
E02 N.T.S.

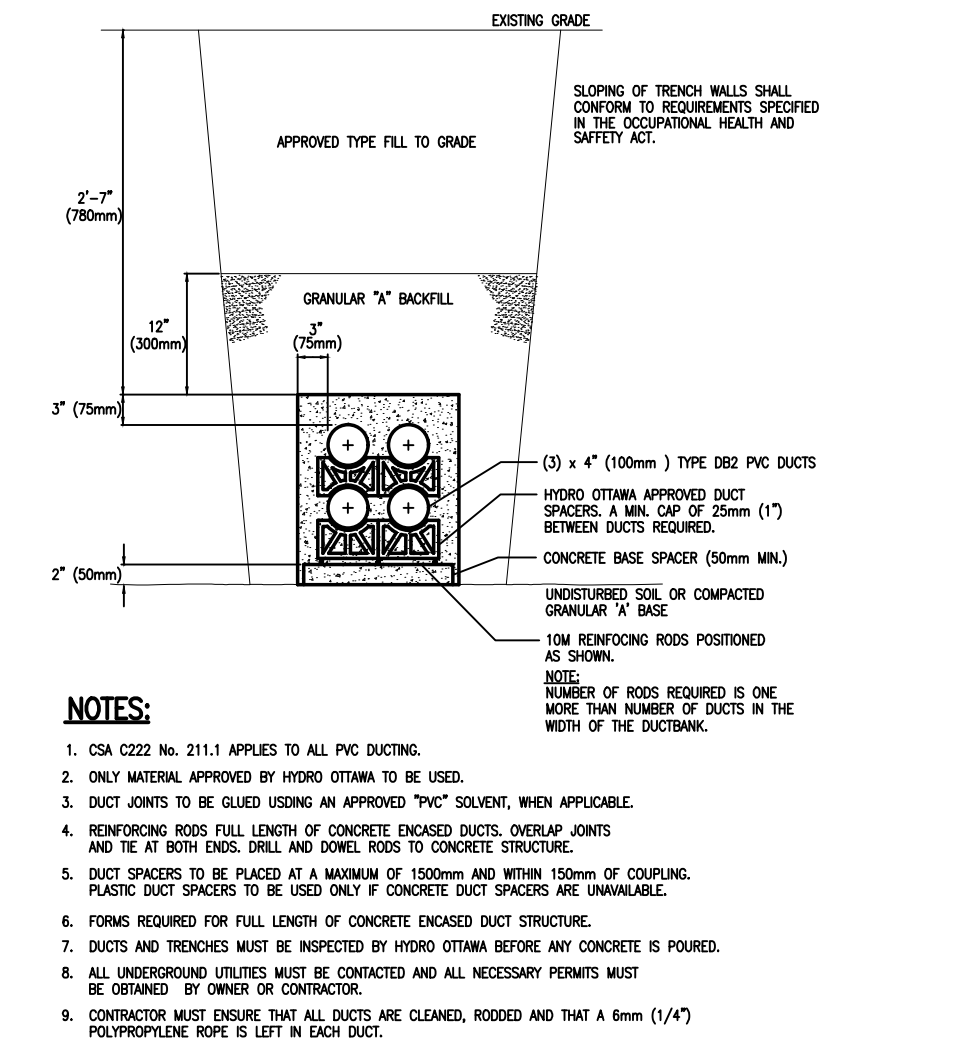

3 4-CELL CONCRETE DUCTBANK (SECONDARY)
E02 N.T.S.

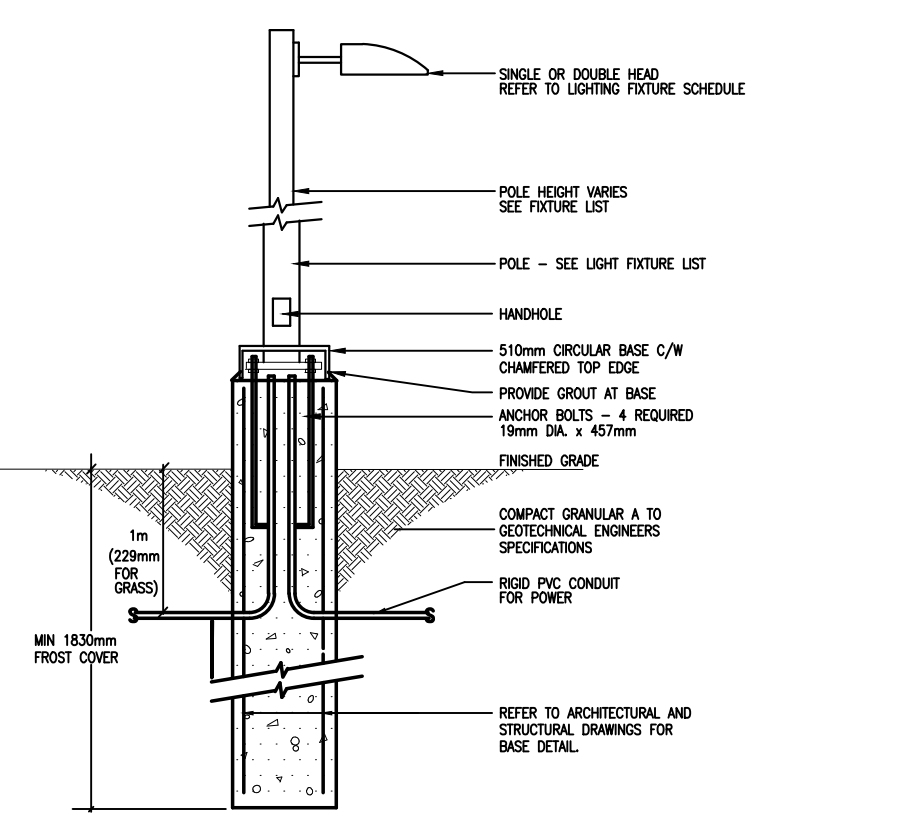

4 TYPICAL BASE DETAIL FOR EXTERIOR LIGHT STANDARD
E02 N.T.S.

TYPE	DESCRIPTION	CATALOG NUMBER	LAMPS PER FIXTURE			VOLT	MOUNTING	REMARKS
			TYPE	WATTS	COLOUR			
A	EXTERIOR LIGHT LED WALL MOUNTED FIXTURE	BECA USA 2421BK3	LED	11	3000K	120	SURFACE	C/W ACCESSORIES MOUNTED @ 15'
E	EXTERIOR LIGHT LED WALL MOUNTED FIXTURE	BECA USA 33817K3	LED	17	3000K	120	SURFACE	C/W ACCESSORIES MOUNTED @ 15'
F	AMENITIES EXTERIOR LIGHT LED SEMI-RECESSED CEILING DOWNLIGHTS	BECA USA 5694K3	LED	31	3000K	120	RECESSED	C/W ACCESSORIES MOUNTED HEIGHT STATED ON DRAWING
G	AMENITIES EXTERIOR LIGHT LED CEILING DOWNLIGHTS	BECA USA ACL34LH40UHE V.1 & ACL54LH40UHE	LED	38.5	3000K	120	RECESSED	C/W ACCESSORIES MOUNTED HEIGHT STATED ON DRAWING
K	EXTERIOR LIGHT LED POLE MOUNTED FIXTURE	LOUIS POULSEN XPERI LED HI SYMS N UP 3000K US	LED	81	3000K	347	POLE	C/W ACCESSORIES MOUNTED @ 20'
K1	EXTERIOR LIGHT LED POLE MOUNTED FIXTURE	LOUIS POULSEN XPERI LED HI ASY3 N UP 3000K US	LED	81	3000K	347	POLE	C/W ACCESSORIES MOUNTED @ 20'
K2	EXTERIOR LIGHT LED POLE MOUNTED FIXTURE	LOUIS POULSEN XPERI LED HI ASY3 N UP 3000K US	LED	81	3000K	347	POLE	C/W ACCESSORIES MOUNTED @ 19.5'
R	EXTERIOR LIGHT LED POLE MOUNTED FIXTURE	LITHONIA LIGHTING RADPT P3 30K PATH	LED	54	3000K	347	POLE	C/W ACCESSORIES MOUNTED @ 15'
R1	EXTERIOR LIGHT LED POLE MOUNTED FIXTURE	LITHONIA LIGHTING RADPT P3 30K PATH	LED	54	3000K	347	POLE	C/W HOUSING SHIELD MOUNTED @ 15'

NOTES:

- FINAL FIXTURE FINISH COLOR SELECTION SHALL BE AS INTERIOR DESIGNER.
- ALL LED FIXTURES SHALL BE C/W DRIVERS.
- PROVIDE DRYWALL ADAPTOR KIT IN ALL FIXTURES IN HARD CEILING.

Project/Projet
BROOKSTREET APARTMENTS
525 LEGGET DRIVE
KANATA ON K2K 2W2

Drawing title/Titre du dessin
ELECTRICAL SITE PLAN

Scale
Echelle
1:100

Project no./No. du projet
2020-610

Design by
Compu par
H.ROMANI

Drawn by
Dessiné par
L.ALI

Reviewed by
Examiné par
H.ROMANI

Date
Date
OCTOBER 2020

Revision no.
Acad file/Fichier:
-

E02

OF