

KEY PLAN



No.	DATE	REVISION
2	JUN 3-22	ISSUED FOR APPROVAL
1	MAY 12-22	ISSUED FOR COORDINATION

D. B. GRAY ENGINEERING INC.
Stormwater Management - Grading & Drainage - Sewer & Sanitary Sewers - Watermain
 700 Long Point Circle 613-425-8044
 Ottawa, Ontario d.gray@dbgrayengineering.com

Project
**PROPOSED
 3-STORY (4-LEVEL)
 APARTMENT BUILDING
 366 WINONA AVENUE
 OTTAWA, ONTARIO**


Drawing Title
**PRE-DEVELOPMENT
 DRAINAGE PLAN**

Engineer's Seal
 D.B. GRAY
 17016502
 JUN 3-22
 PROVINCE OF ONTARIO


Drawn D.B.G.
 H. Scale 1:100
 V. Scale
 Date MAY 12-22
 Job No. 21142

Drawing No.
**C-6
 of 7**


NOT VALID UNLESS SIGNED & DATED

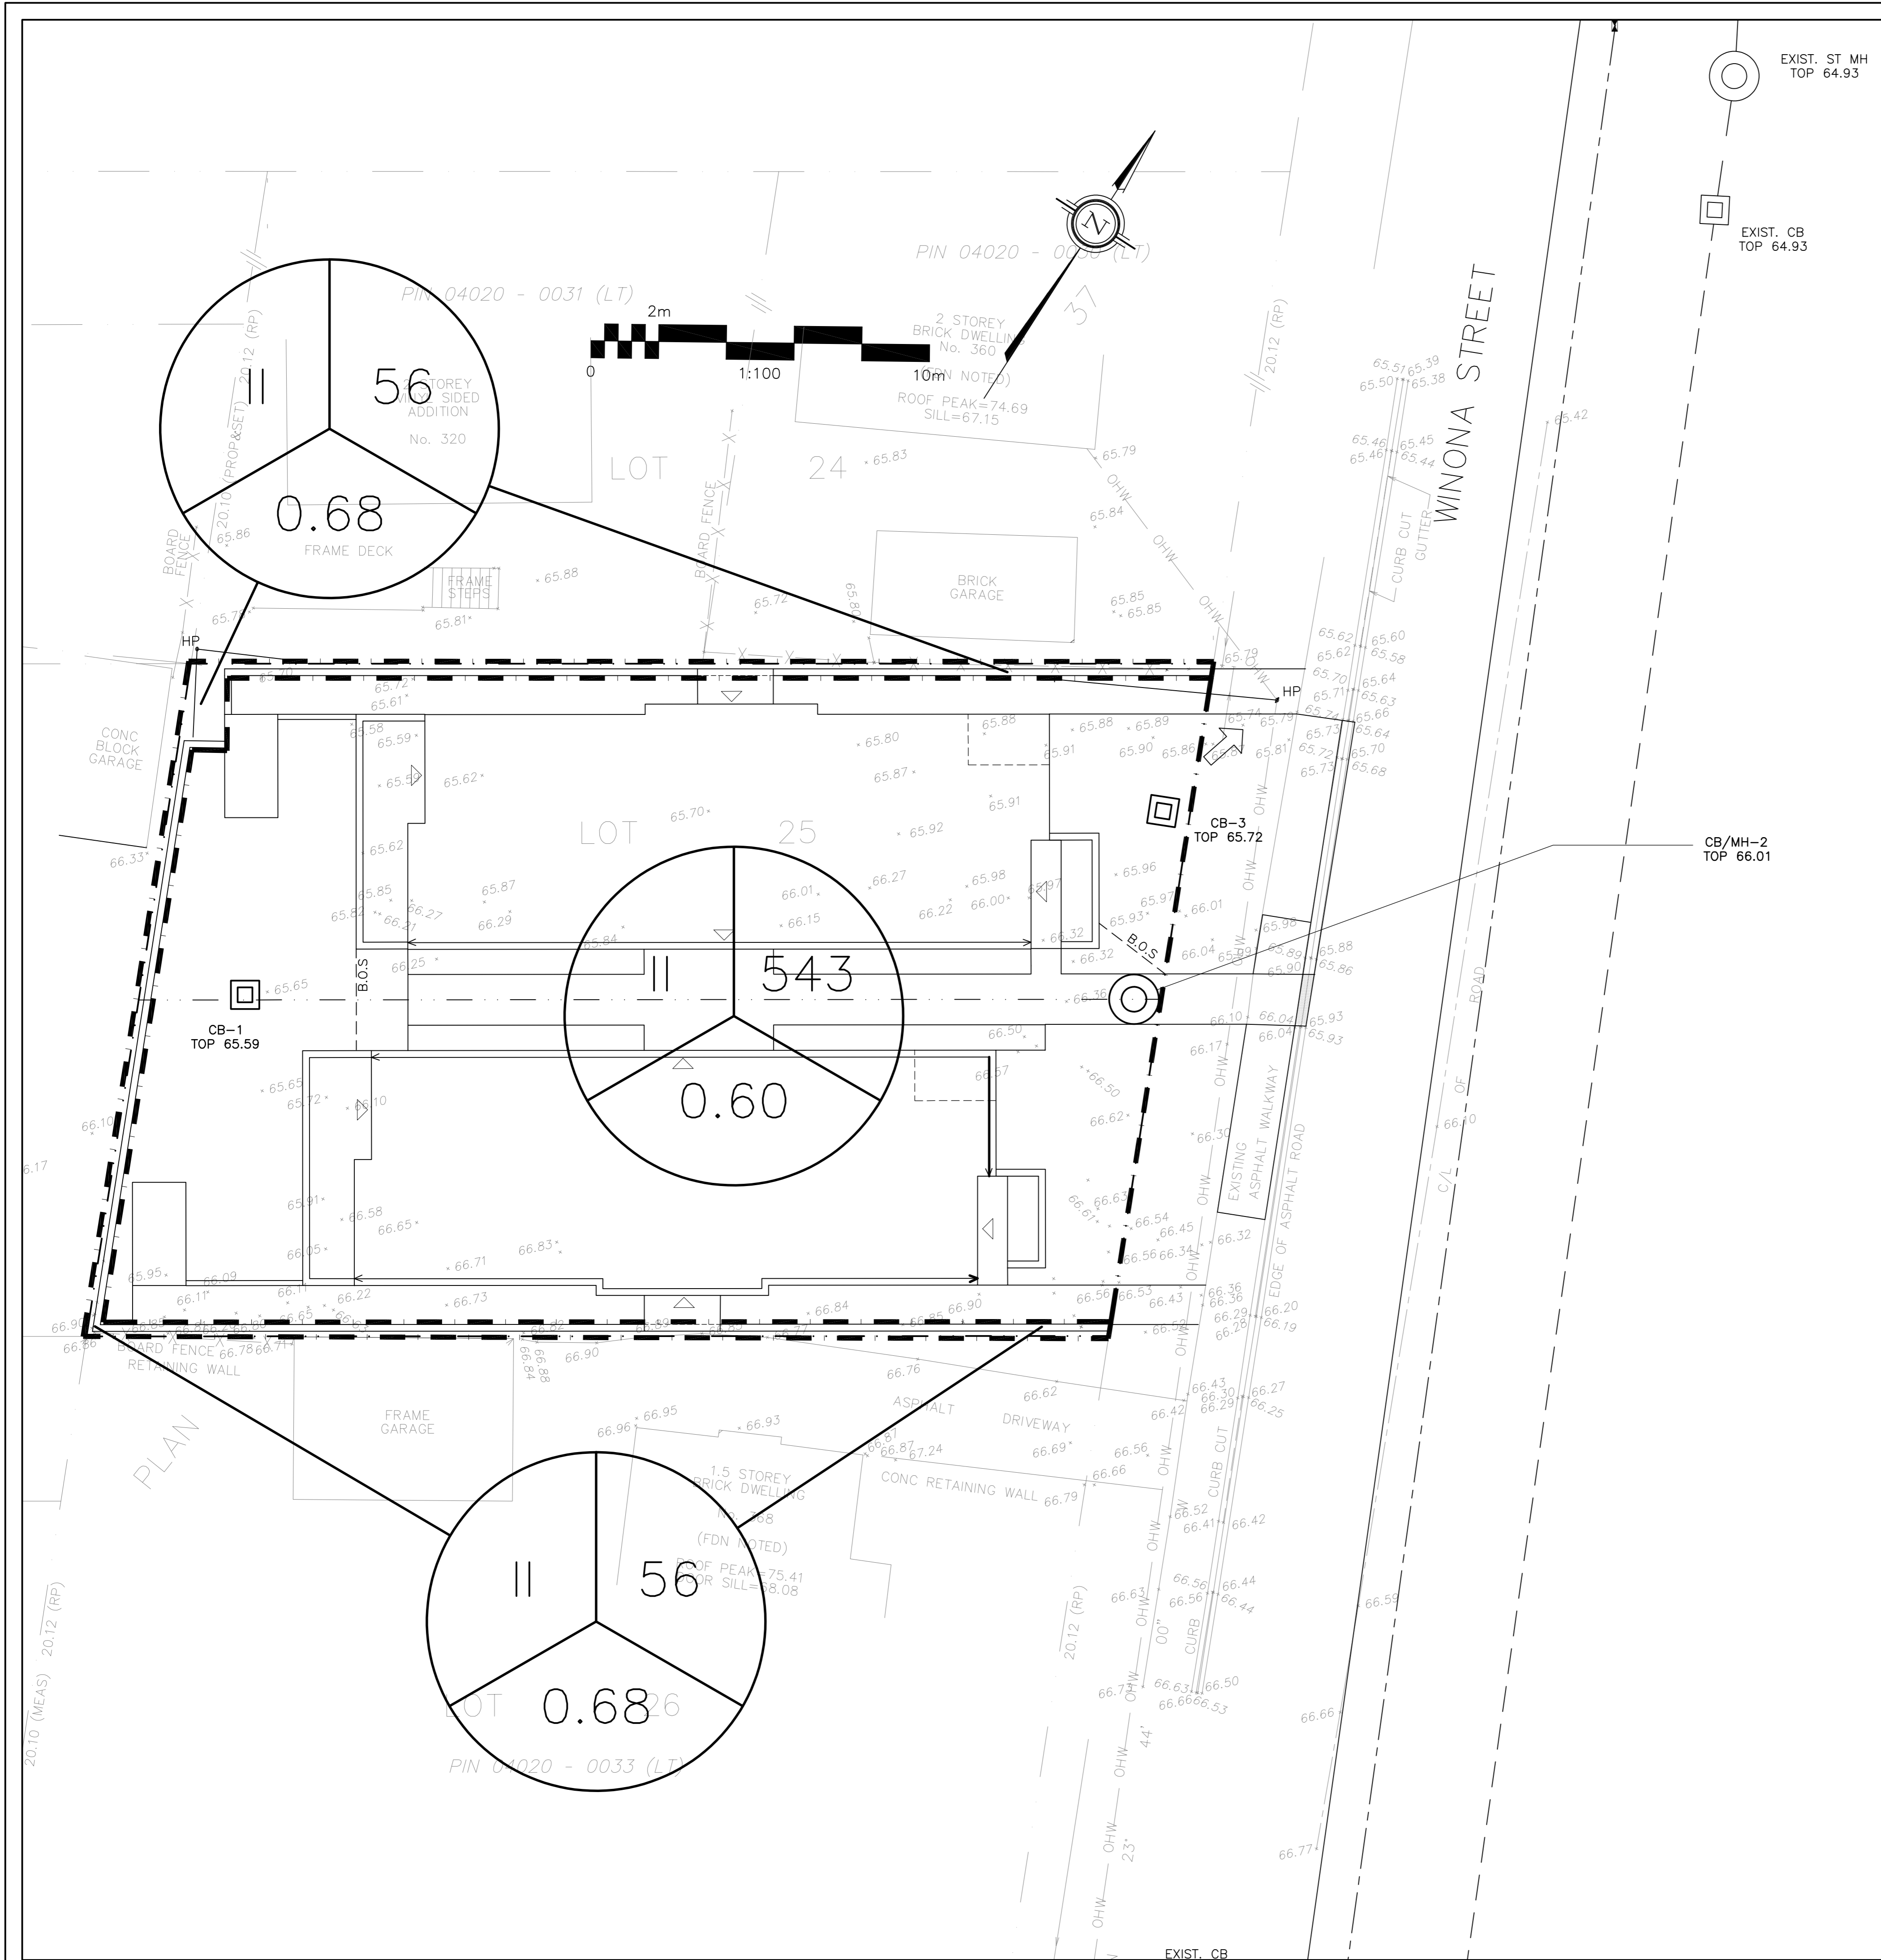

LEGEND

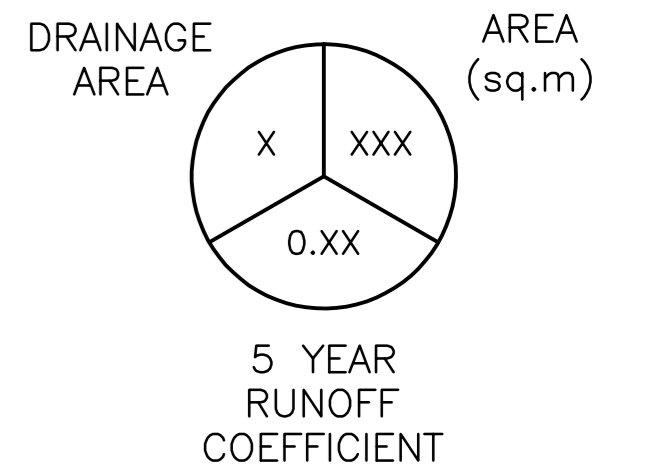

KEY PLAN

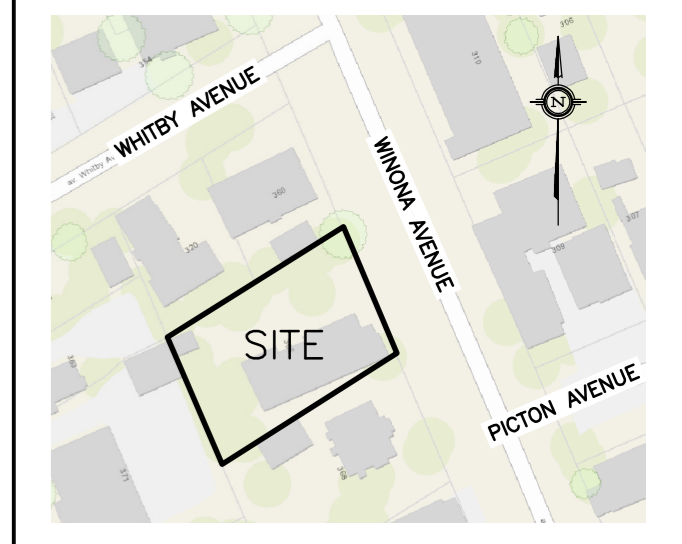


No.	DATE	REVISION
2	JUN 3-22	ISSUED FOR APPROVAL
1	MAY 12-22	ISSUED FOR COORDINATION

D. B. GRAY ENGINEERING INC.
 Stormwater Management - Grading & Drainage - Storm & Sanitary Sewers - Waterworks
 700 Long Point Circle 613-425-8044
 Ottawa, Ontario d.gray@dbgrayengineering.com

Project
**PROPOSED
 3-STORY (4-LEVEL)
 APARTMENT BUILDING
 366 WINONA AVENUE
 OTTAWA, ONTARIO**

Drawing Title
**PRE-DEVELOPMENT
 DRAINAGE PLAN**

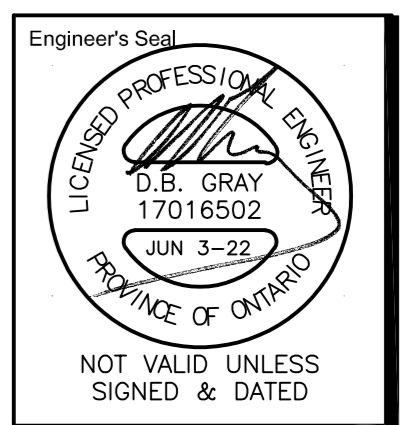

Drawn D.B.G.
 H. Scale 1:100
 V. Scale
 Date MAY 12-22
 Job No. 21142

Drawing No.
**C-7
 of 7**

NOT VALID UNLESS
 SIGNED & DATED