



Symbol	Qty	Label	Arrangement	Description	LLF	Luminaire Lumens	Total Watts	(MANUFAC)	BUG Rating
□	2	PIa	Single	VP-S-60L-136-3K7-4-BC 0.3M ARMS, MOUNTING HEIGHT 7.9, COLOR BLACK	0.900	10394	267,206	Hubbell Lighting Inc	B1-U0-G2
□	4	SS	Single	LXEN4-30XW-RFA-EDU SUN SHADE, COLOR WHITE	0.850	2074	55.6	COLUMBIA LIGHTING	B1-U0-G1
□	1	PI	Single	VP-S-60L-136-3K7-2 MFG 28FT, MOUNTING HEIGHT 7.9, COLOR BLACK	0.900	4964	30.6	Forum Lighting	B1-U0-G1
□	12	ADD	Single	ACD-3-65LED30-SAT-H X 4-WH, COLOR WHITE	0.850	2652	166.8	LIGMAN	N/A
□	1	OW2b	Single	UTA-31861-T2-W30 Tempo Square, COLOR BLACK	0.900	2427	13.9	KIM LIGHTING	B1-U0-G0
□	1	OP1	Single	PATRNUS-12L-020-3K7, COLOR BLACK	0.900	1264	13.9	KIM LIGHTING	B1-U0-G0
□	4	OP2	Single	PATRNUS-12L-020-3K7, COLOR BLACK	0.900	1264	55.6	HUBBELL LIGHTING	B1-U0-G2
□	7	P2	Single	VP-S-48L-110-3K7-3-BC Davit Arms, MOUNTING HEIGHT 7.9, COLOR BLACK	0.900	7516	768.46	Hubbell Lighting Inc	B1-U0-G2
□	5	P1	Single	VP-S-60L-136-3K7-4-BC Davit Arms, MOUNTING HEIGHT 7.9, COLOR BLACK	0.900	10394	668.015	Hubbell Lighting Inc	B1-U0-G2
□	2	P3	Single	VP-S-48L-110-3K7-3 MOUNTING HEIGHT 7.9, COLOR BLACK	0.900	10984	216	Hubbell Lighting Inc, dba Beacon Products	B1-U0-G2
□	13	OW2	Single	TRP1-12L30-3K7-4, COLOR BLACK	0.900	2674	365.3	HUBBELL OUTDOOR LIGHTING	B1-U0-G1
□	14	ATW	Single	LTR-4R03-FS-06L-DMU_LTR-4RD-T-SL03K1WS, COLOR BLACK	0.900	644	109.2	PRESCOLITE	B1-U0-G0

Label	CalcType	Units	Avg	Max	Min	AvgMin	MaxMin
ADA BARRIER FREE PARKING	Illuminance	Fc	3.94	4.8	2.8	1.41	1.71
AWT ENTRANCE CANOPY	Illuminance	Fc	8.20	12.1	4.3	1.91	2.81
BIKE RACKS	Illuminance	Fc	3.98	3.9	2.7	1.25	1.41
COURTYARD	Illuminance	Fc	1.64	10.6	0.0	N/A	N/A
LOADING	Illuminance	Fc	3.25	4.2	2.5	1.30	1.68
PARKING	Illuminance	Fc	2.54	3.7	1.4	1.89	2.54
PROPERTY LINE SPILL OF LIGHT	Illuminance	N/A	0.05	1.7	0.0	N/A	N/A
STAIRS TYPE OW2	Illuminance	Fc	3.25	4.9	1.8	1.81	2.72
TERRACE CANOPY/PS	Illuminance	Fc	4.66	9.8	5.3	1.26	1.85
TYPE OW2: ARCHITECTURALLY FOR WALKWAY	Illuminance	Fc	3.32	9.5	0.9	3.69	10.66
TYPE SS SHADE CANOPY	Illuminance	Fc	5.88	9.3	2.7	2.10	3.44
VEHICLE CANOPY AREA	Illuminance	Fc	21.13	26.5	16.6	1.27	1.60

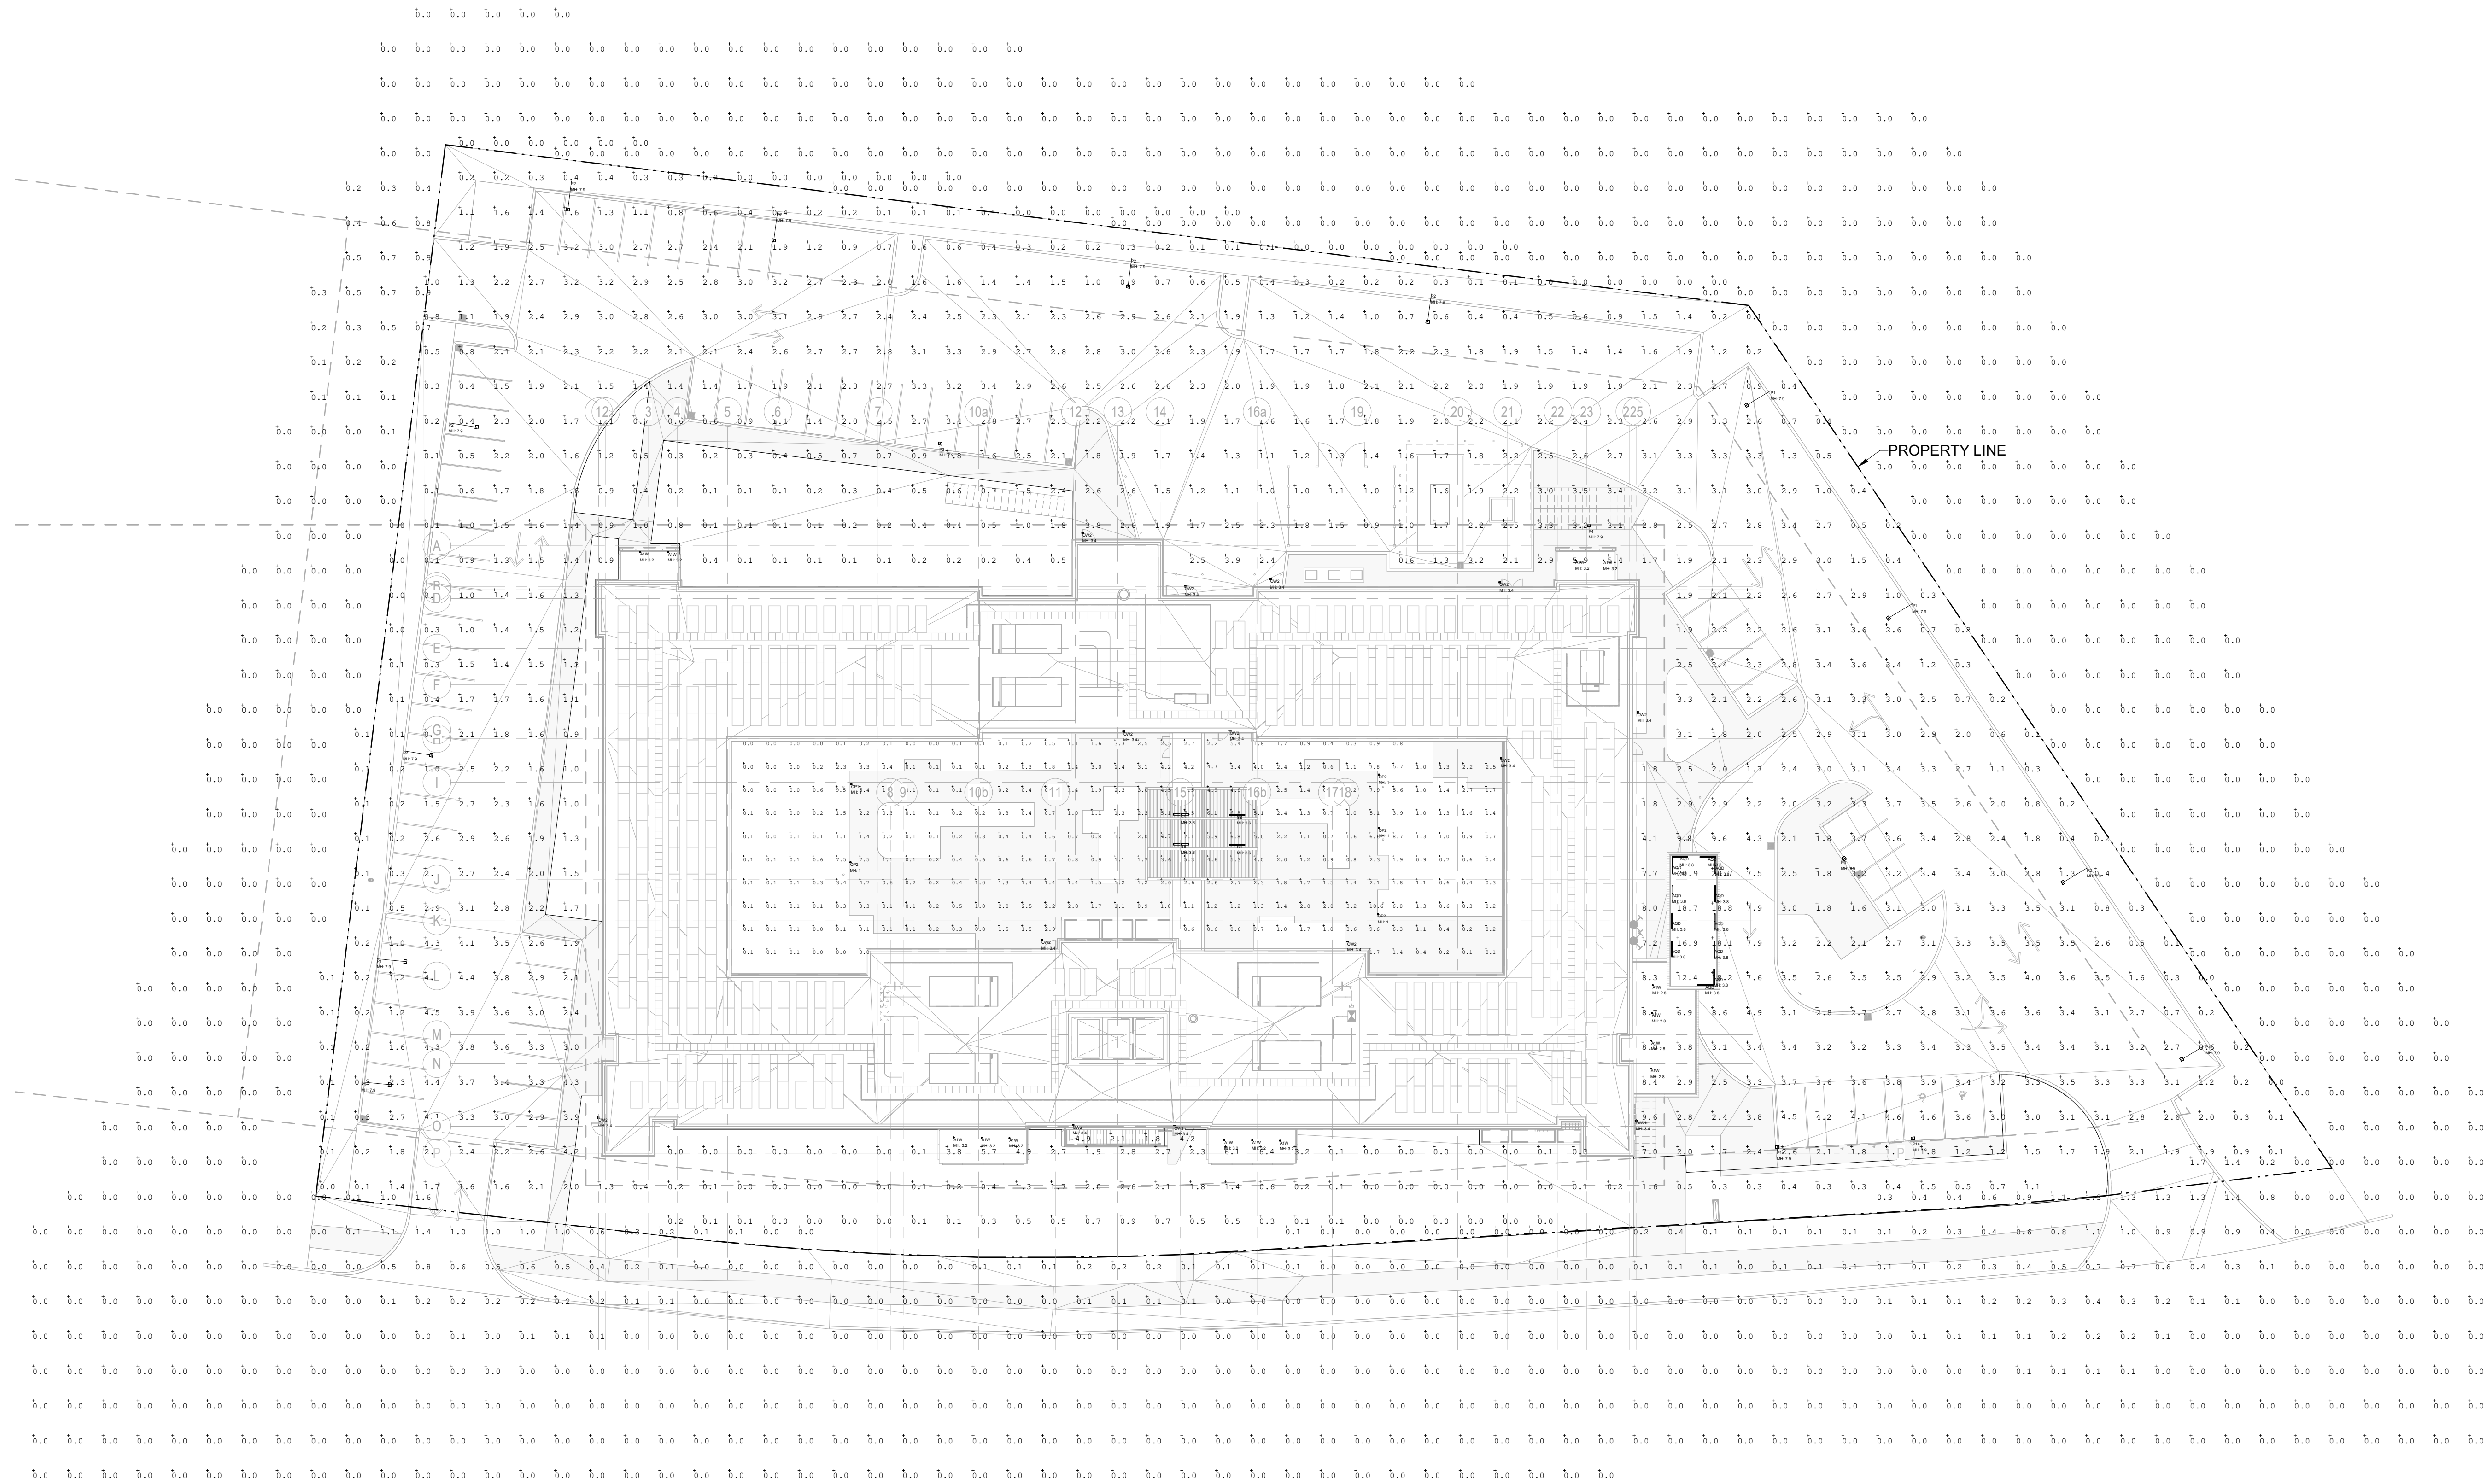

2 2022-08-19 RE-ISSUED FOR SITE PLAN CONTROL FB
1 2021-11-19 APPLICATION & ZONING BY-LAW AMENDMENT FB
ISSUED FOR SITE PLAN CONTROL APPLICATION FB
date: revision: by:

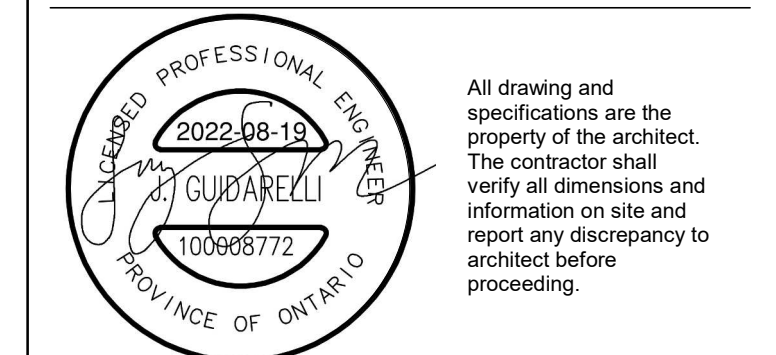

All drawing and specifications are the property of the architect. The contractor shall verify all dimensions and information on site and report any discrepancy to architect before proceeding.

Arch Corp - Orleans

1161 OLD MONTREAL RD,
ORLEANS ON, K4A 3N6

ELECTRICAL SITE PLAN -
LIGHTING & PHOTOMETRICS

scale: 1 : 300
drawn by: FB
reviewed by: JG
job number: HC-21-055
plot date: Issue Date
drawing number:

E-101.