


SITE PLAN  
SCALE: 1:400

REVISIONS AND DISTRIBUTION LOG

No	Date	Note
1	JUNE 19/23	ISSUED FOR S.P.A.

ALL DRAWINGS ARE THE PROPERTY OF THE ARCHITECT AND MUST BE RETURNED ON REQUEST.  
THE CONTRACTOR SHALL CHECK ALL DIMENSIONS AND REPORT DISCREPANCIES TO THE ARCHITECT.  
ALL DIMENSIONS ARE GIVEN IN MILLIMETRES UNLESS OTHERWISE INDICATED.  
DO NOT SCALE DRAWINGS.

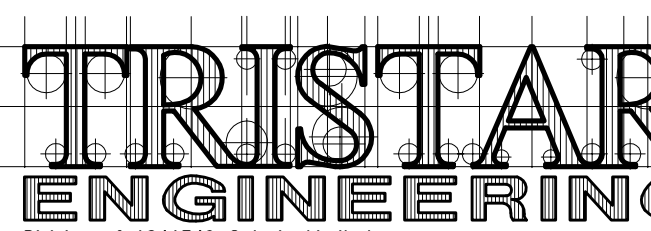

Division of 1041549 Ontario Limited  
8901 Woodbine Avenue, Unit #116  
Markham, Ontario  
Canada, L3R 9Y4  
(905) 604-3801  
Fax (905) 604-3954

Project:  
COMMERCIAL DEVELOPMENT

3095 Palladium Drive  
Ottawa Ontario

Drawing Title:  
SITE PLAN

Drawn By: J.Y.	Checked By: J.P.	Date Checked: JUN. 2023	Project No. 2023-088
-------------------	---------------------	----------------------------	-------------------------

Date Plotted:	Scale: 1:400
---------------	-----------------

Drawing No.: LE-1	Revision No.: -
----------------------	--------------------

Symbol	Qty	Label	Arrangement	LLF	Description	Lum. Watts	Lum. Lumens
	3	ZL-2-11L-5Q	BACK-BACK	0.900	CREE LIGHTING CAT. #OSQM-B-11L-40K7-5Q-UH	72	11950
	1	ZL-1-11L-3M	SINGLE	0.900	CREE LIGHTING CAT. #OSQM-B-11L-40K7-3M-UH	72	11175
	3	WL-1-6L-4ME	SINGLE	0.900	CREE LIGHTING CAT. #XSPW-B-WM-4ME-6L-40K-UH	47	6100
	16	WL-1-2L-2ME	SINGLE	0.900	CREE LIGHTING CAT. #XSPW-B-WM-2ME-2L-40K-UH	19	2490
	18	WL-1-4L-4ME	SINGLE	0.900	CREE LIGHTING CAT. #XSPW-B-WM-4ME-4L-40K-UH	31	4270
	1	WL-1-2L-4ME	SINGLE	0.900	CREE LIGHTING CAT. #XSPW-B-WM-4ME-2L-40K-UH	19	2490

Label	CalcType	Units	Avg	Max	Min	Avg/Min	Max/Min
spill	Illuminance	Lux	1.51	14.3	0.0	N.A.	N.A.
within property line	Illuminance	Lux	22.32	54.6	0.0	N.A.	N.A.

LumNo	Label	X	Y	Z	Orient	Tilt
1	ZL-2-11L-5Q	370.071	477.051	22.5	90	0
2	ZL-2-11L-5Q	460.334	476.981	22.5	90	0
3	ZL-2-11L-5Q	541.119	476.953	22.5	90	0
4	ZL-1-11L-3M	281.82	459.85	22.5	127.145	0
6	WL-1-4L-4ME	277.5	504.102	15	0	0
7	WL-1-4L-4ME	277.5	554.102	15	0	0
8	WL-1-4L-4ME	277.5	604.102	15	0	0
9	WL-1-6L-4ME	309.472	548.298	15	270	0
10	WL-1-4L-4ME	359.472	548.298	15	270	0
11	WL-1-4L-4ME	409.472	548.298	15	270	0
12	WL-1-4L-4ME	459.472	548.298	15	270	0
13	WL-1-6L-4ME	509.472	548.298	15	270	0
14	WL-1-4L-4ME	557.265	533.637	15	270	0
15	WL-1-4L-4ME	607.948	533.637	15	270	0
16	WL-1-4L-4ME	615.674	498.203	15	180.444	0
17	WL-1-4L-4ME	615.629	446.412	15	180	0
18	WL-1-4L-4ME	537.34	405.57	15	90	0
32	WL-1-4L-4ME	582.34	405.57	15	90	0
33	WL-1-4L-4ME	627.34	405.57	15	90	0
34	WL-1-4L-4ME	672.34	405.57	15	90	0
36	WL-1-6L-4ME	351.071	405.83	15	90	0
37	WL-1-4L-4ME	401.071	405.83	15	90	0
38	WL-1-4L-4ME	451.071	405.83	15	90	0
39	WL-1-4L-4ME	501.071	405.83	15	90	0
40	WL-1-4L-4ME	546.609	405.315	15	90	0
41	WL-1-2L-2ME	515.7	391.352	15	0	0
42	WL-1-2L-2ME	340.93	385.342	15	180	0
43	WL-1-2L-2ME	522.64	370.912	15	0	0
44	WL-1-2L-2ME	305.264	591.454	15	90	0
46	WL-1-2L-2ME	255.851	607.161	15	90	0
47	WL-1-2L-2ME	231.715	515.179	15	180	0
58	WL-1-2L-2ME	231.715	590.179	15	180	0
59	WL-1-2L-2ME	680.234	385.089	15	0	0
60	WL-1-2L-2ME	661.355	447.519	15	0	0
61	WL-1-2L-2ME	661.355	498.148	15	0	0
62	WL-1-2L-2ME	621.88	548.563	15	0	0
63	WL-1-2L-2ME	608.794	575.38	15	39.806	0
64	WL-1-2L-2ME	567.389	589.539	15	90	0
68	WL-1-2L-2ME	375.264	591.454	15	90	0
69	WL-1-2L-2ME	445.264	591.454	15	90	0
70	WL-1-2L-2ME	515.264	591.454	15	90	0
71	WL-1-2L-4ME	255.684	501.433	15	270	0

BUILDINGS 'A', 'B', 'C', 'D', 'E' & 'F'

HALO CAR WASH

- POLE MOUNTED FIXTURES ARE MOUNTED ON A 20FT POLE ATOP A 36 INCH HIGH CONCRETE BASE.

LUM NO.	LABEL	MTG. HT.
1	A	23
2	A	23
3	A	23
4	A2	23
5	A2	23
6	A2	23
7	A3	23
8	B	23
9	D	9
10	D	9
11	D	9
12	D	9
13	D	9
14	D	9
15	D	9
16	D	9
17	D	9
18	D	9
19	D	9



LABEL	AVG	MAX	MIN	AVG/MIN	MAX/MIN
PAVED AREA	4.63	20.6	0.9	5.14	22.89
UNDEFINED AREA	0.63	10.4	0.0	N.A.	N.A.

SYMBOL	QTY	LABEL	ARRANGEMENT	LUMENS	LLF	BUG RATING	WATTS/LUMINAIRE	TOTAL WATTS	MANUFACTURE	CATALOG LOGIC
	3	A	SINGLE	13374	1.000	B3-U0-G2	85	255	Cree Inc	OSQ-ML-B-DA + OSQM-B-16L-40K7-3M-UL-NM- BZ-Q9
	3	A2	BACK-BACK	13374	1.000	B3-U0-G2	85	510	Cree Inc	OSQ-ML-B-DA + OSQM-B-16L-40K7-3M-UL-NM- BZ-Q9
	1	A3	3 @ 90 Degrees	13374	1.000	B3-U0-G2	85	255	Cree Inc	OSQ-ML-B-DA + OSQM-B-16L-40K7-3M-UL-NM- BZ-Q9
	1	B	SINGLE	12699	1.000	B2-U0-G2	104	104	Cree Inc	OSQ-ML-B-DA + OSQM-B-16L-40K7-3M-UL-NM- BZ-Q9 + OSQ-BLSMF
	11	D	SINGLE	6094	1.000	B1-U0-G2	46.95	516.45	Cree Inc	XSPW-B-WM-3ME-6L-40K-UL-BZ

REVISIONS AND DISTRIBUTION LOG

No.	Date	Note
1	JUNE 19/23	ISSUED FOR S.P.A.

ALL DRAWINGS ARE THE PROPERTY OF THE ARCHITECT AND MUST BE RETURNED ON REQUEST.  
 THE CONTRACTOR SHALL CHECK ALL DIMENSIONS AND REPORT DISCREPANCIES TO THE ARCHITECT.  
 ALL DIMENSIONS ARE GIVEN IN MILLIMETRES UNLESS OTHERWISE INDICATED.  
 DO NOT SCALE DRAWINGS.

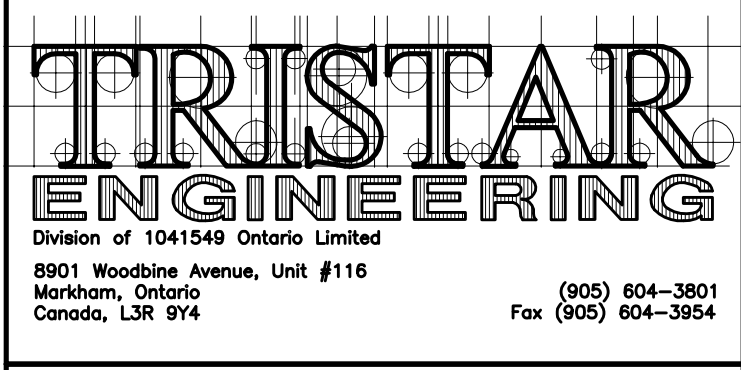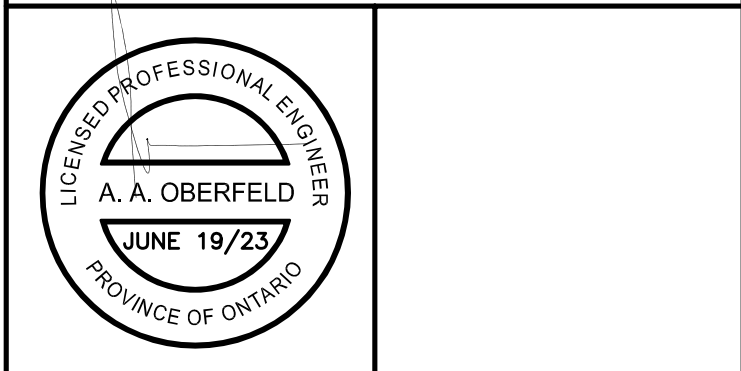

Project: COMMERCIAL DEVELOPMENT

3095 Palladium Drive  
 Ottawa Ontario

Drawing Title: SITE PLAN DETAILS

Drawn By: J.Y. Checked By: J.P. Date Checked: JUN. 2023 Project No: 2023-088

Date Plotted: Scale: 1:400

Drawing No: LE-1A Revision No: -