



IT IS THE RESPONSIBILITY OF THE APPROPRIATE CONTRACTOR TO CHECK AND VERIFY ALL DIMENSIONS ON SITE AND TO REPORT ALL ERRORS AND/OR OMISSIONS TO THE ARCHITECT.  
 ALL CONTRACTORS MUST COMPLY WITH ALL PERTINENT CODES AND BY-LAWS.  
 THIS DRAWING MAY NOT BE USED FOR CONSTRUCTION UNTIL SIGNED BY THE ARCHITECT.  
 DO NOT SCALE DRAWINGS.  
 COPYRIGHT RESERVED.


WITHOUT PREJUDICE

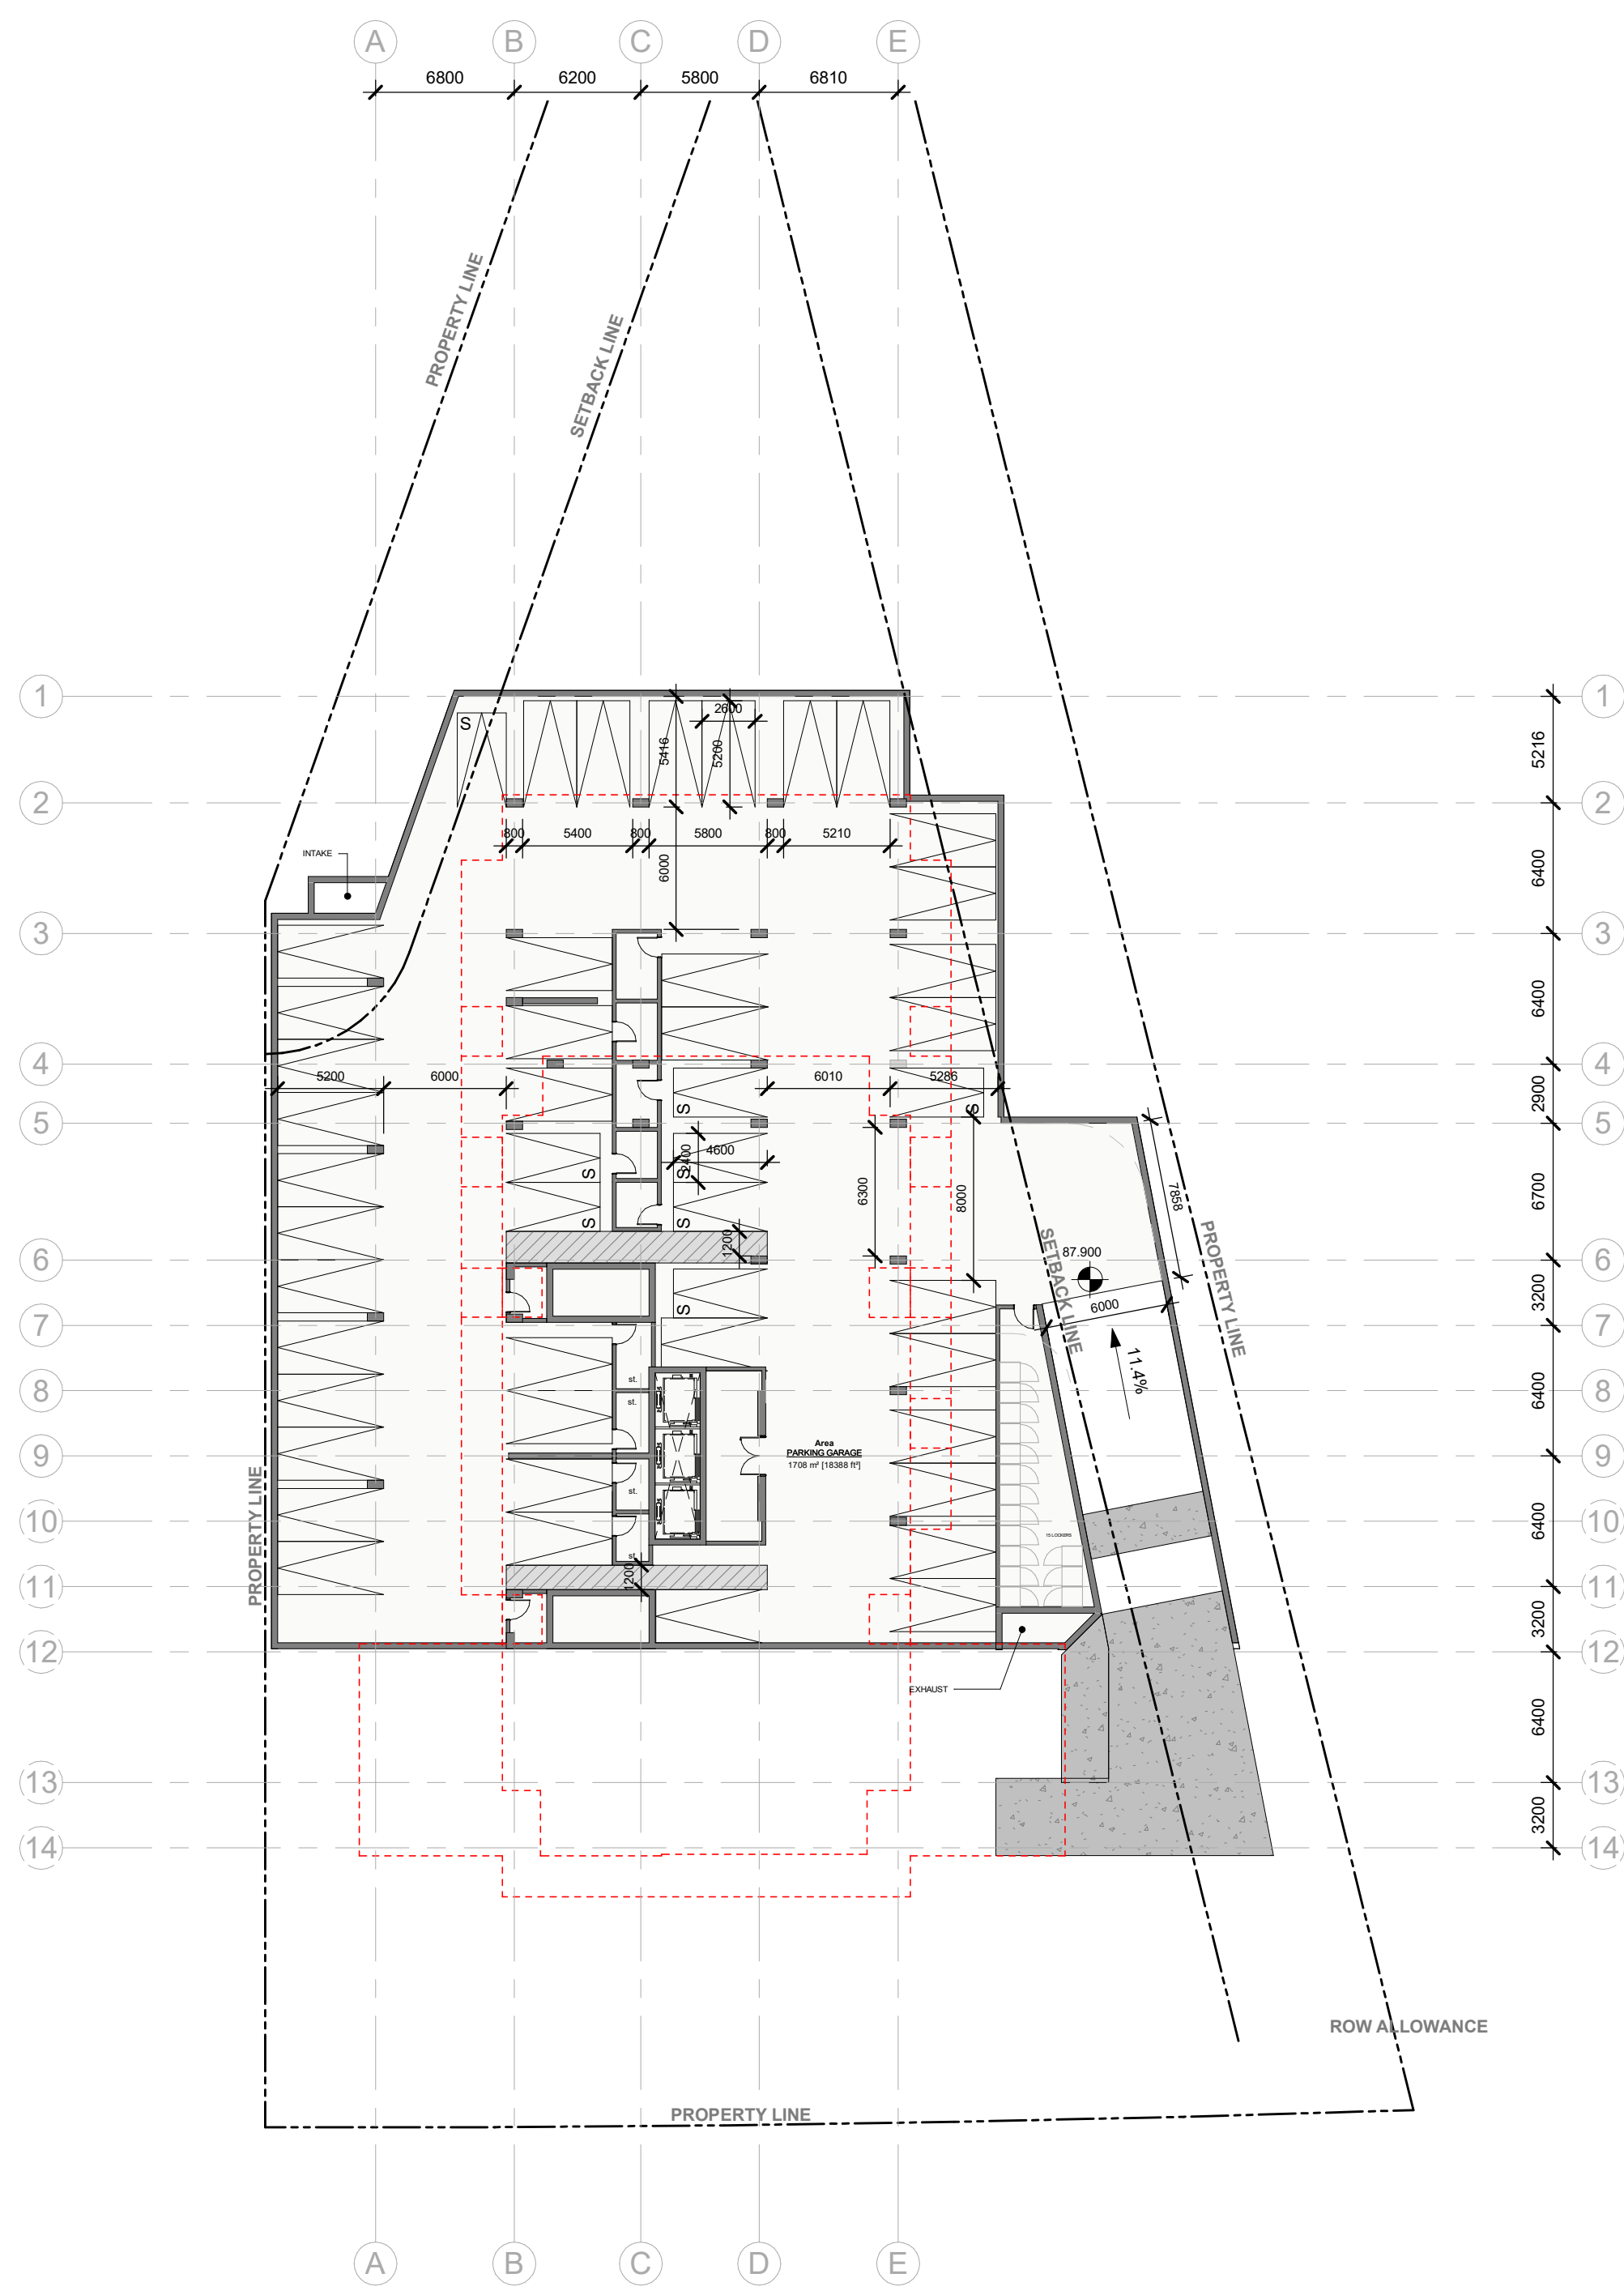

P3 FLOOR PLAN

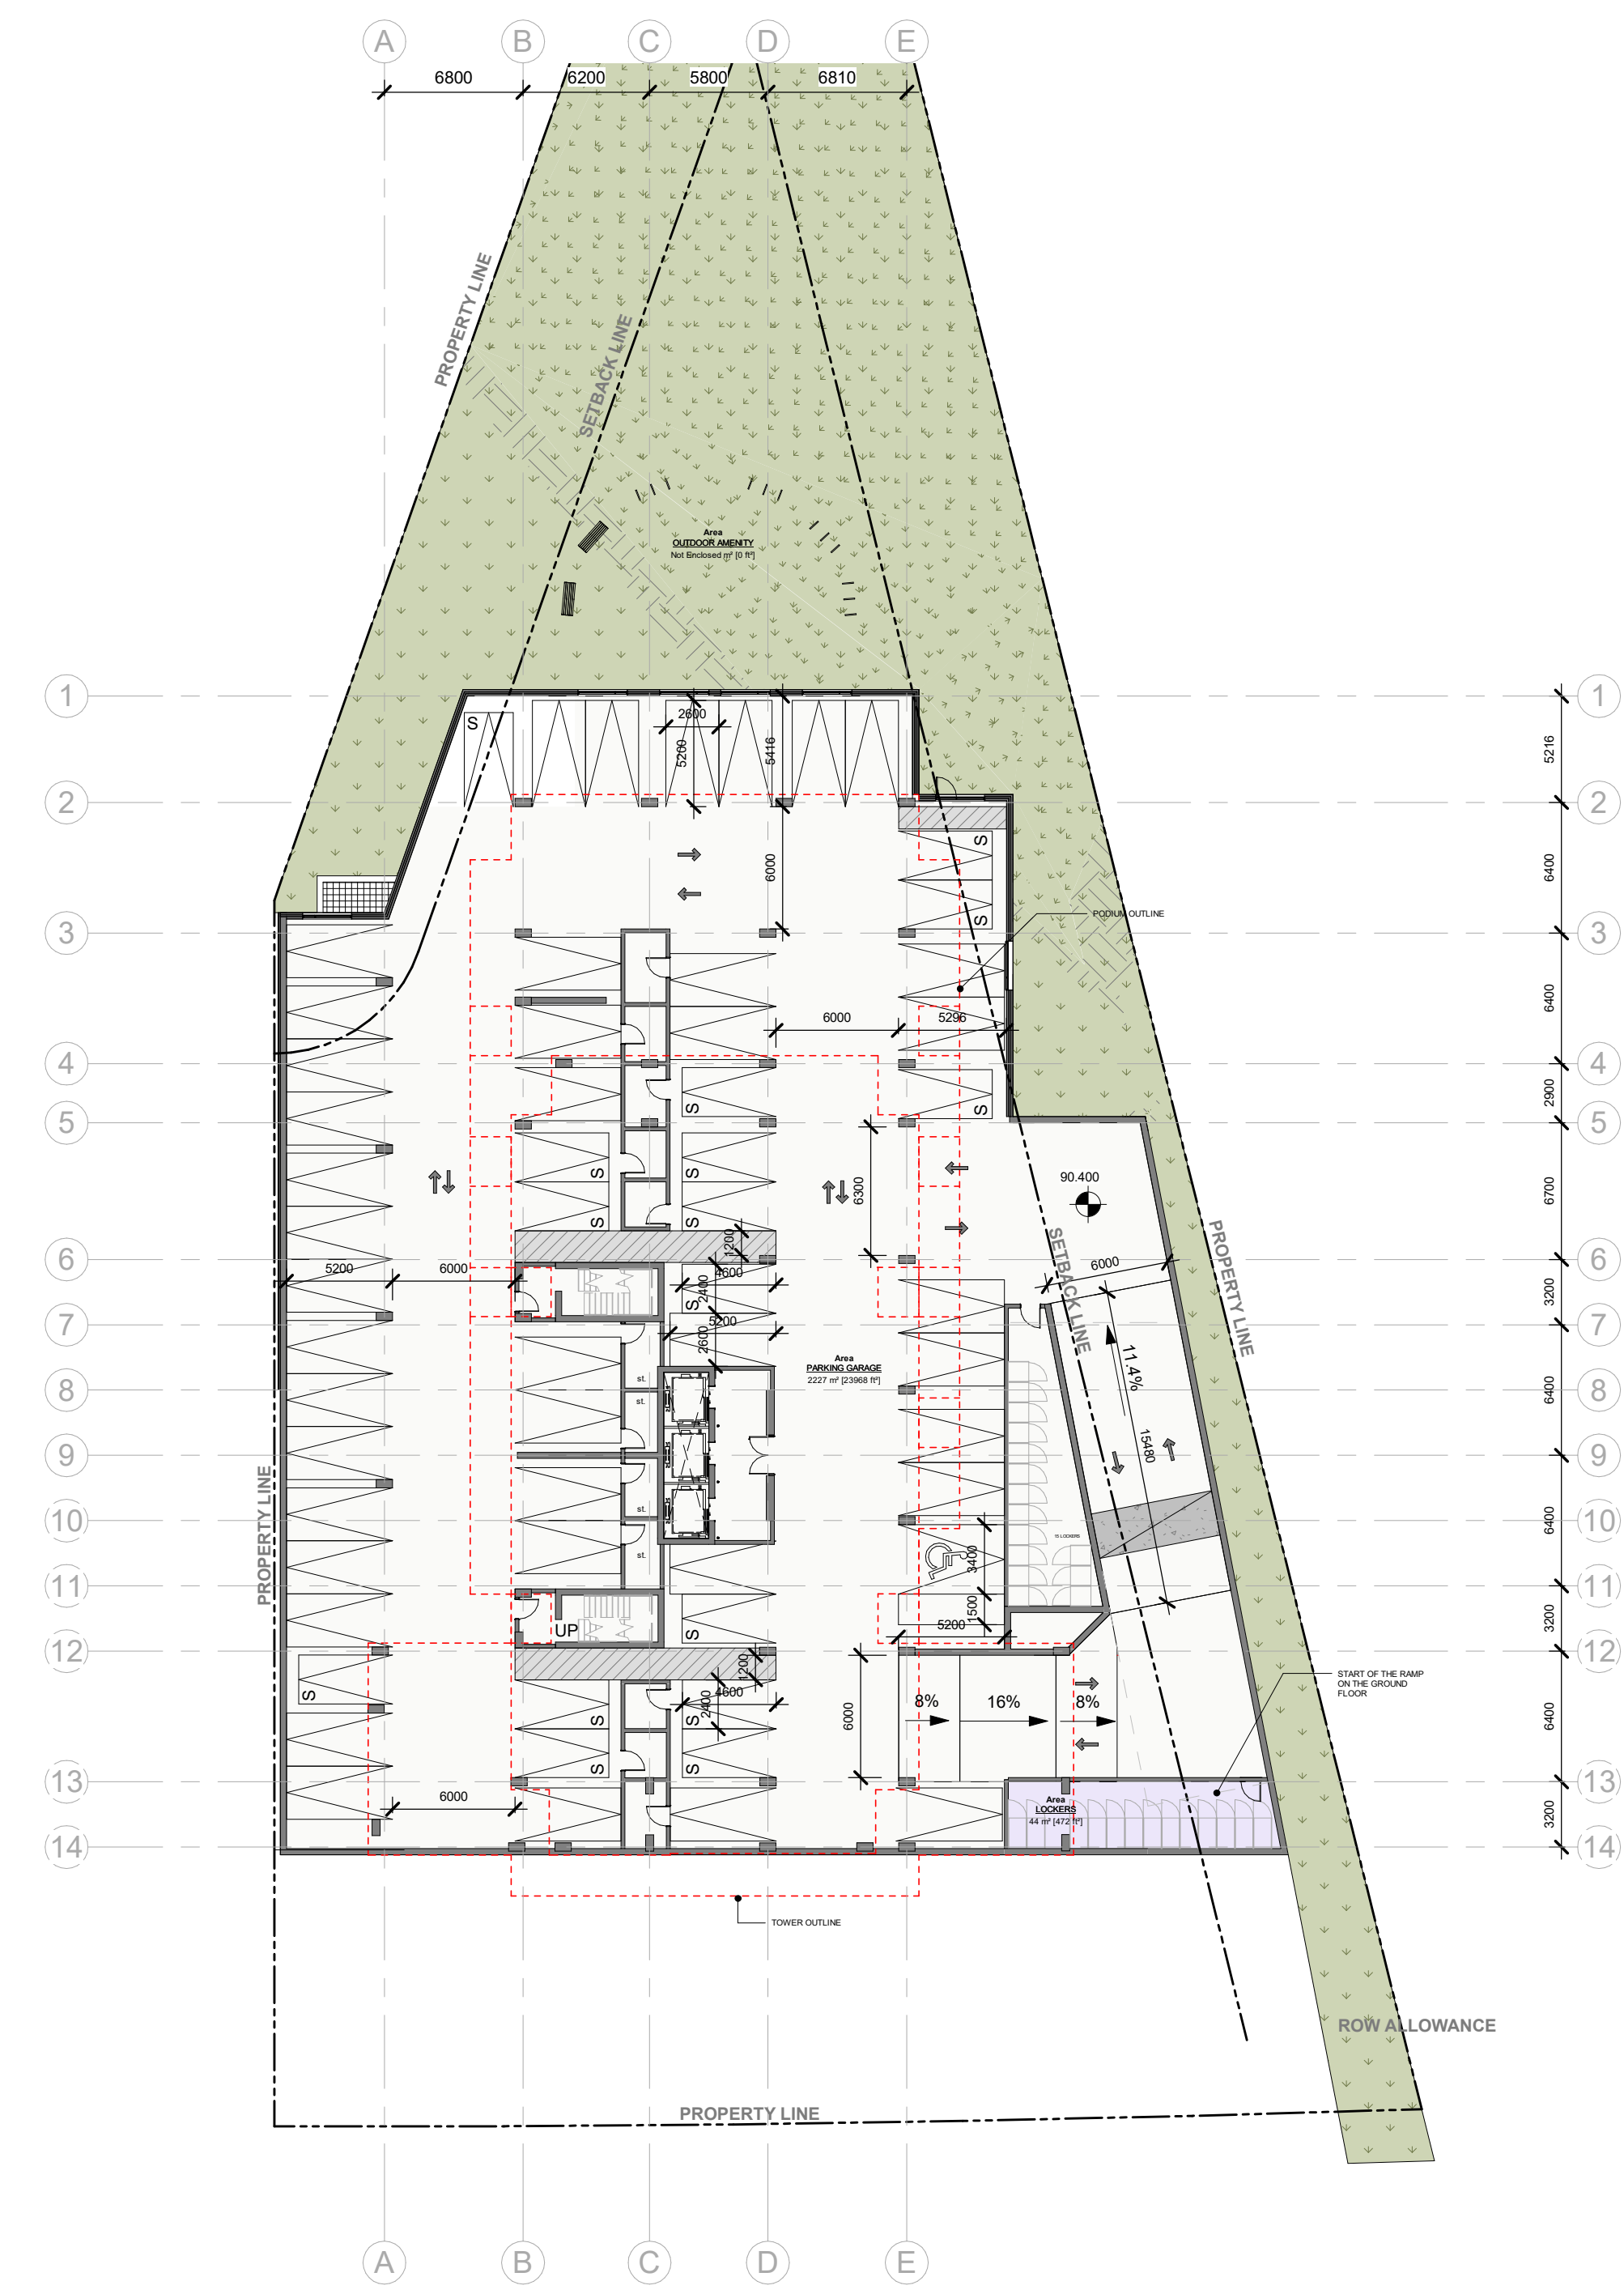

P2 FLOOR PLAN

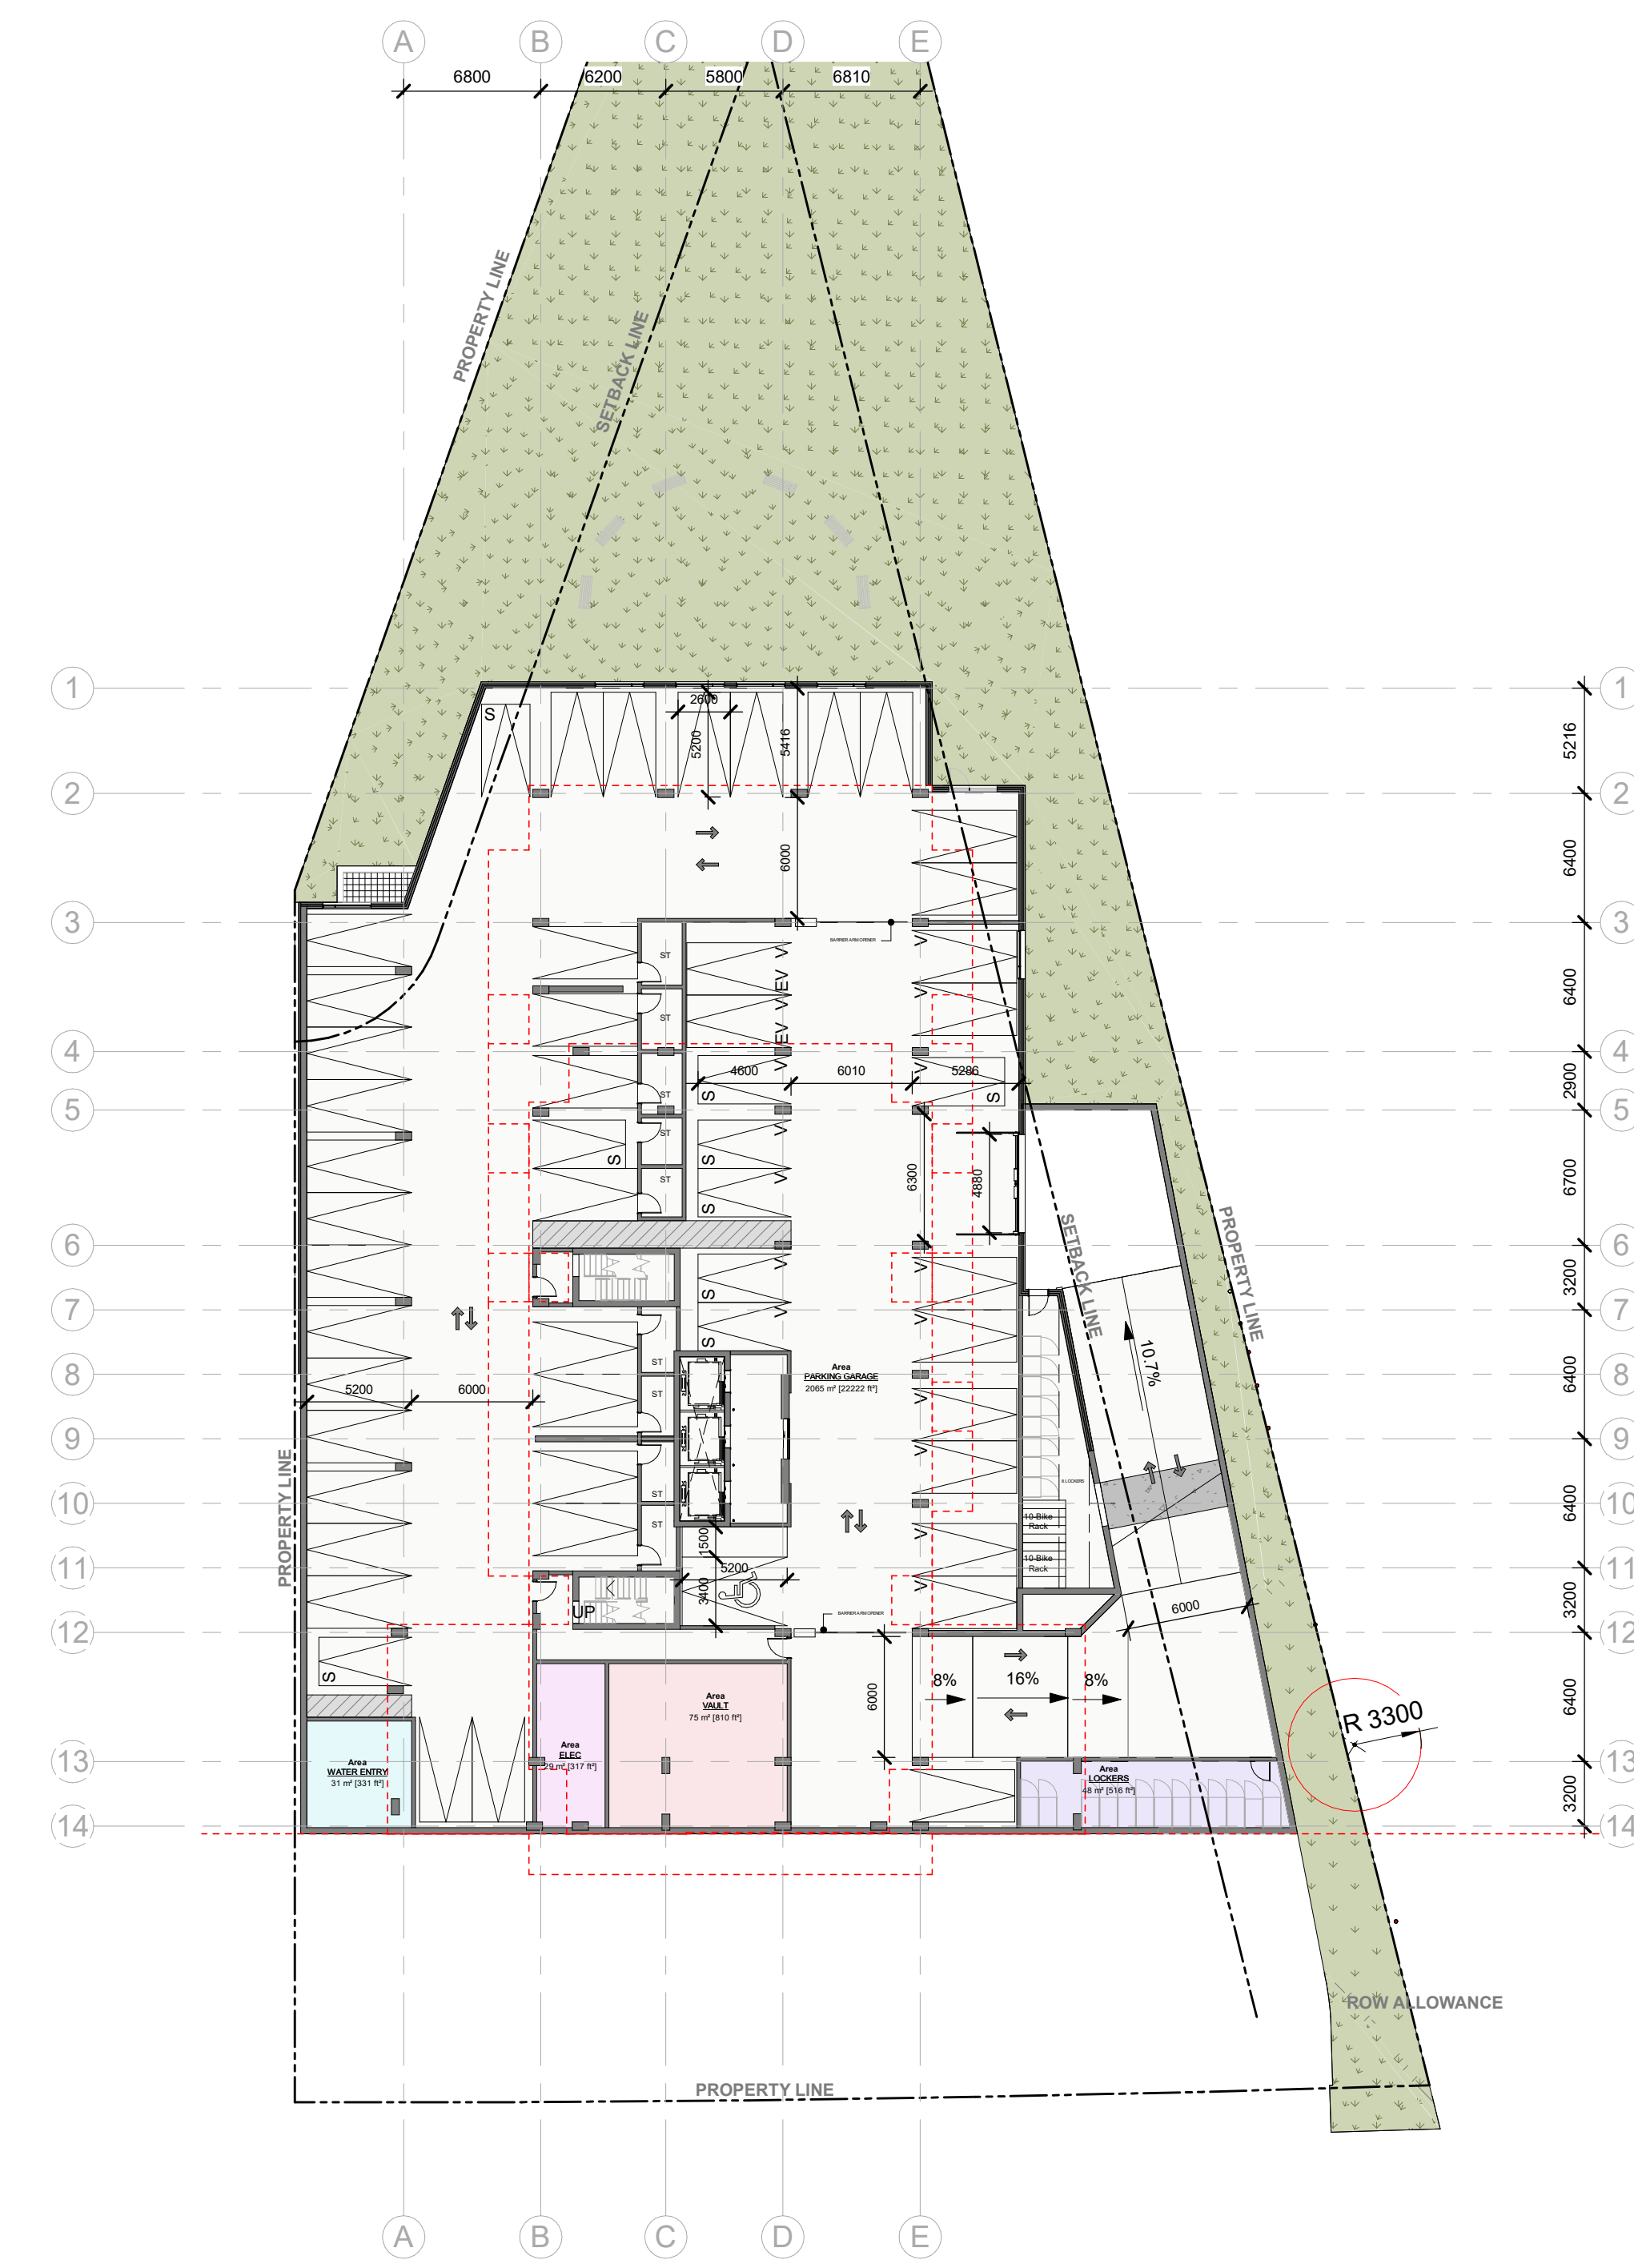

P1 FLOOR PLAN

SPC 01 ISSUED FOR ZBLA APPLICATION	2024 12 13
No. DESCRIPTION	YYYY-MM-DD

ARCHITECT SEAL: NORTH ARROW:

CLIENT:

ARCHITECT:

PROJECT TITLE:  
 1815 MONTREAL RD  
 OTTAWA ON

SHEET TITLE:  
 FLOOR PLANS

DRAWN: Author	CHECKED: Checker
SCALE: 1 : 300	SHEET No.:
PROJECT No.:	A-101
2405	


PAPER SIZE: ISO Full Base B1 (707.0x 1000.0mm)  
 PLOT DATE: 2024-12-20 12:42:40 PM

IT IS THE RESPONSIBILITY OF THE APPROPRIATE CONTRACTOR TO CHECK AND VERIFY ALL DIMENSIONS ON SITE AND TO REPORT ALL ERRORS AND/OR OMISSIONS TO THE ARCHITECT.  
 ALL CONTRACTORS MUST COMPLY WITH ALL PERTINENT CODES AND BY-LAWS.  
 THIS DRAWING MAY NOT BE USED FOR CONSTRUCTION UNTIL SIGNED BY THE ARCHITECT.  
 DO NOT SCALE DRAWINGS.  
 COPYRIGHT RESERVED.


WITHOUT PREJUDICE



GROUND FLOOR PLAN

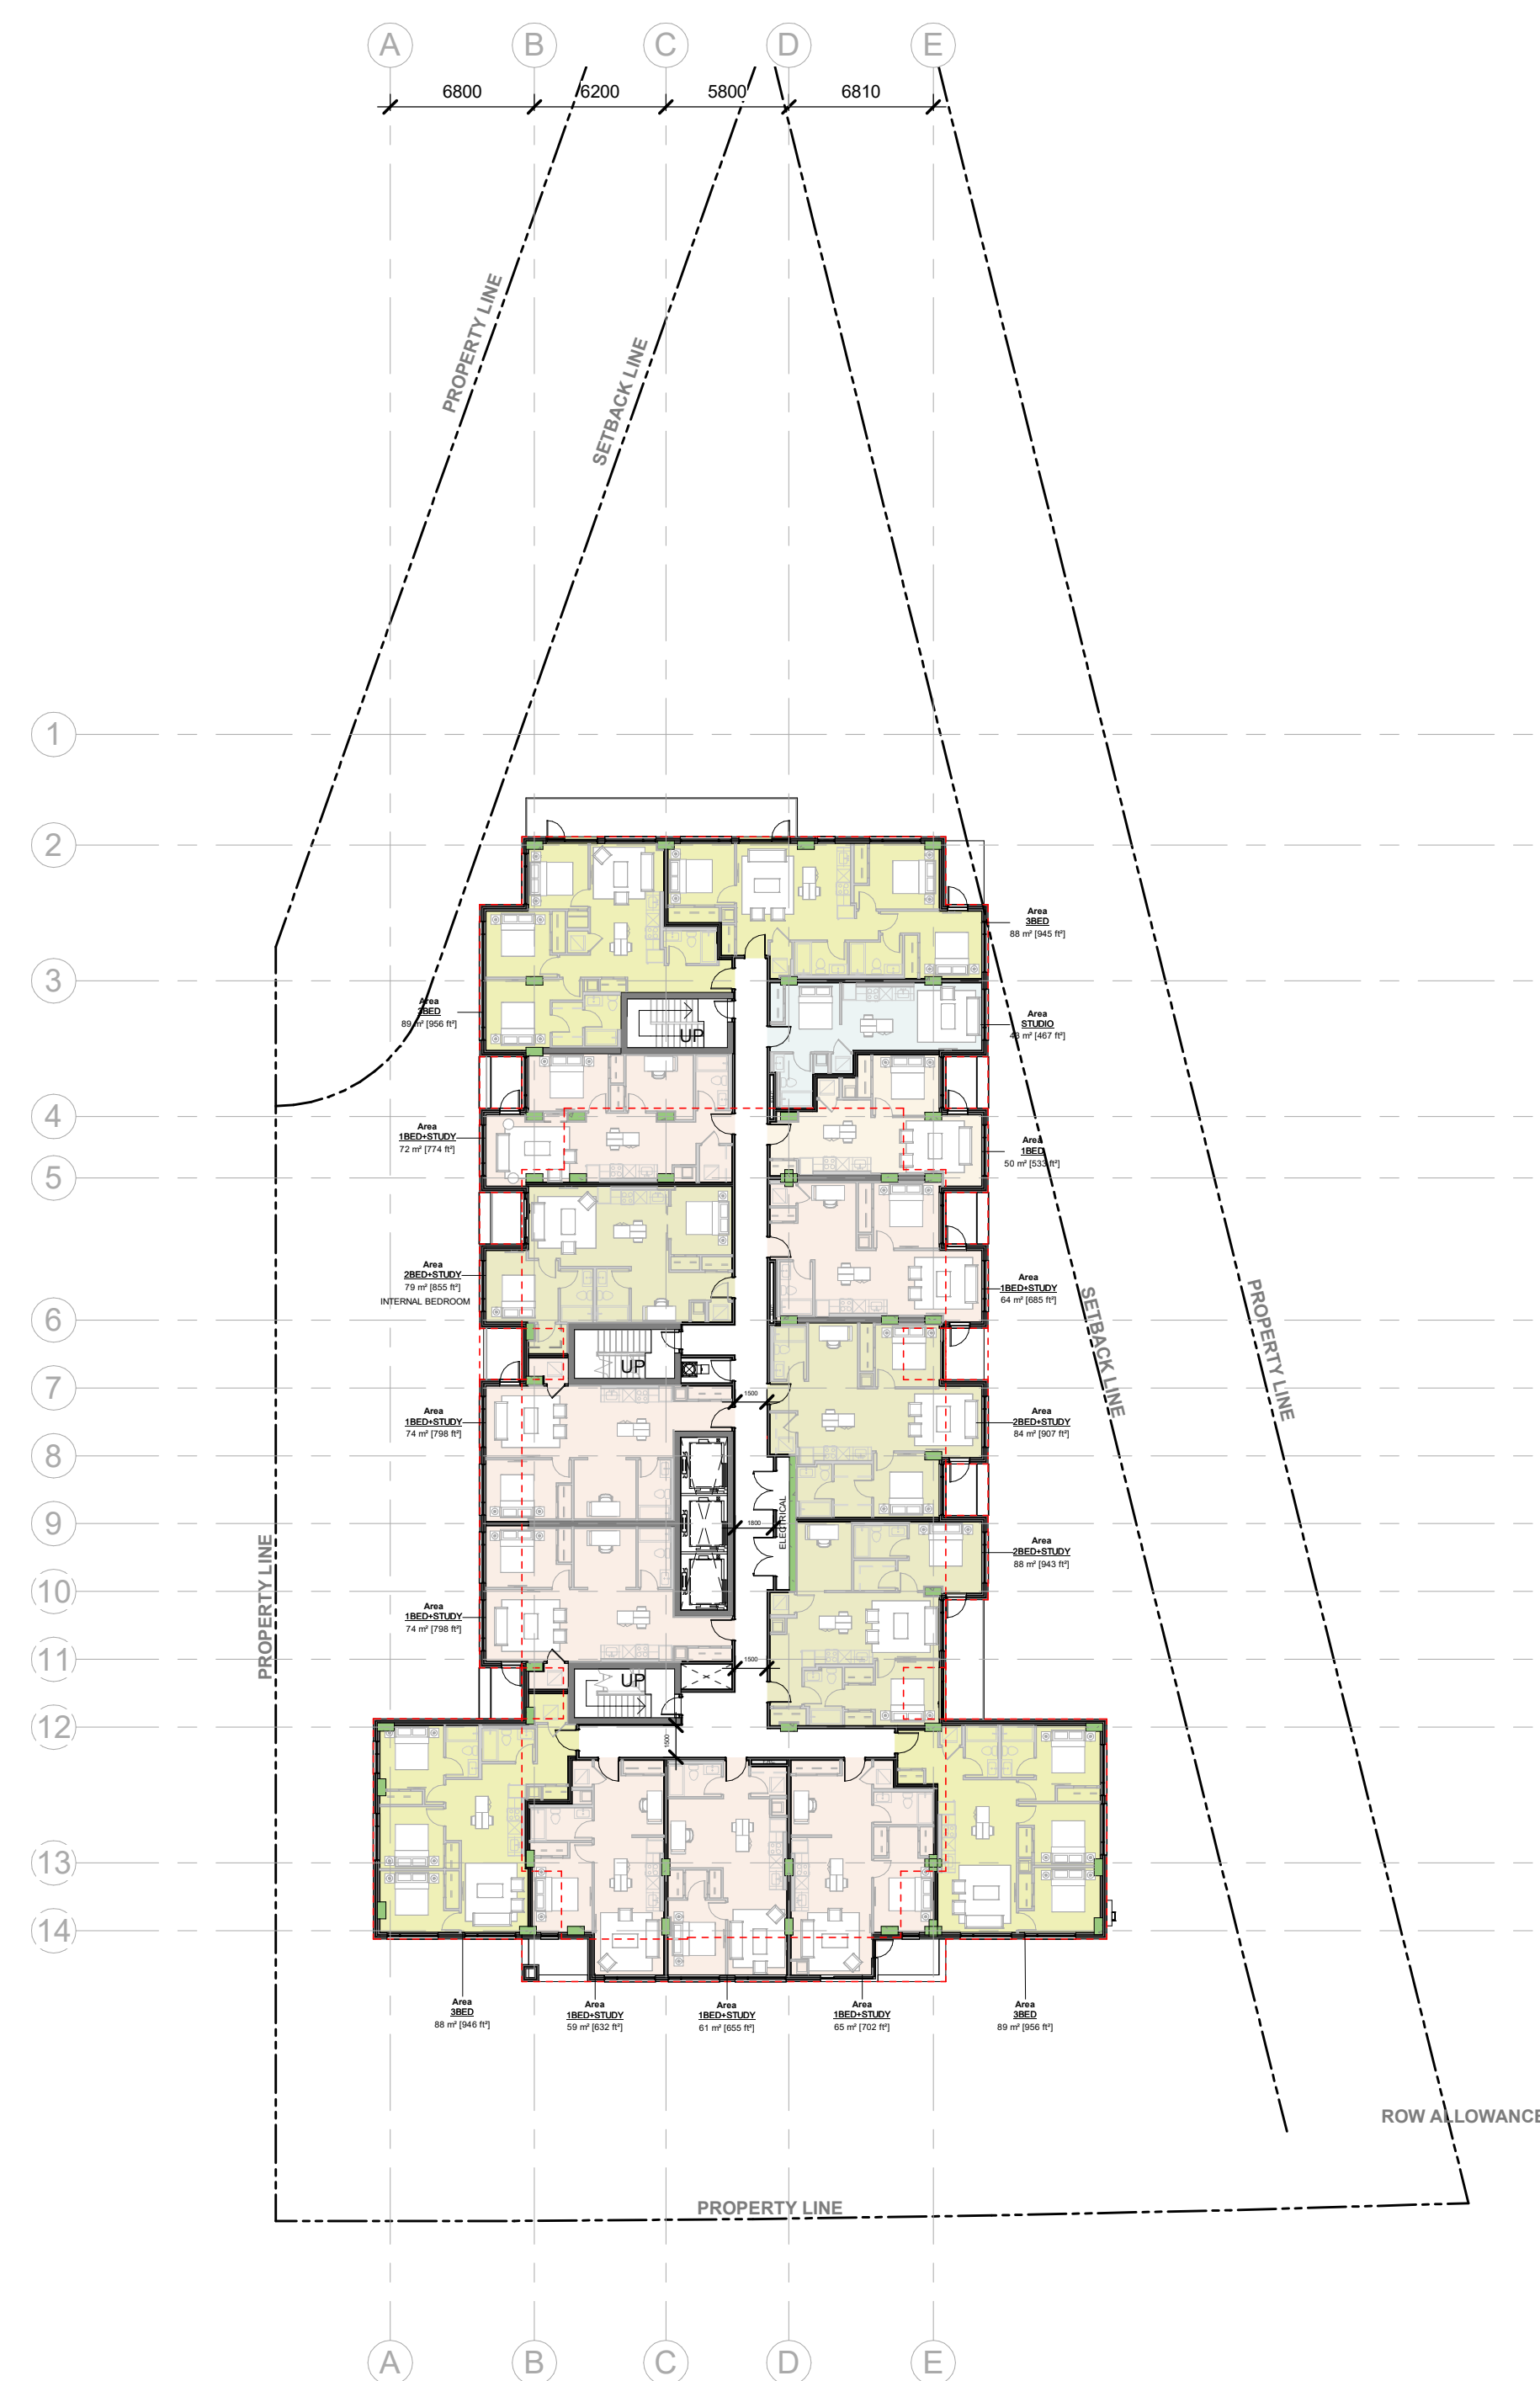
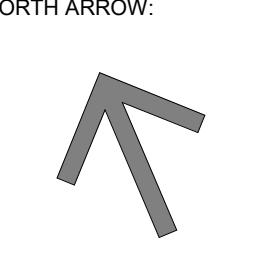



LEVEL 2-3 FLOOR PLAN

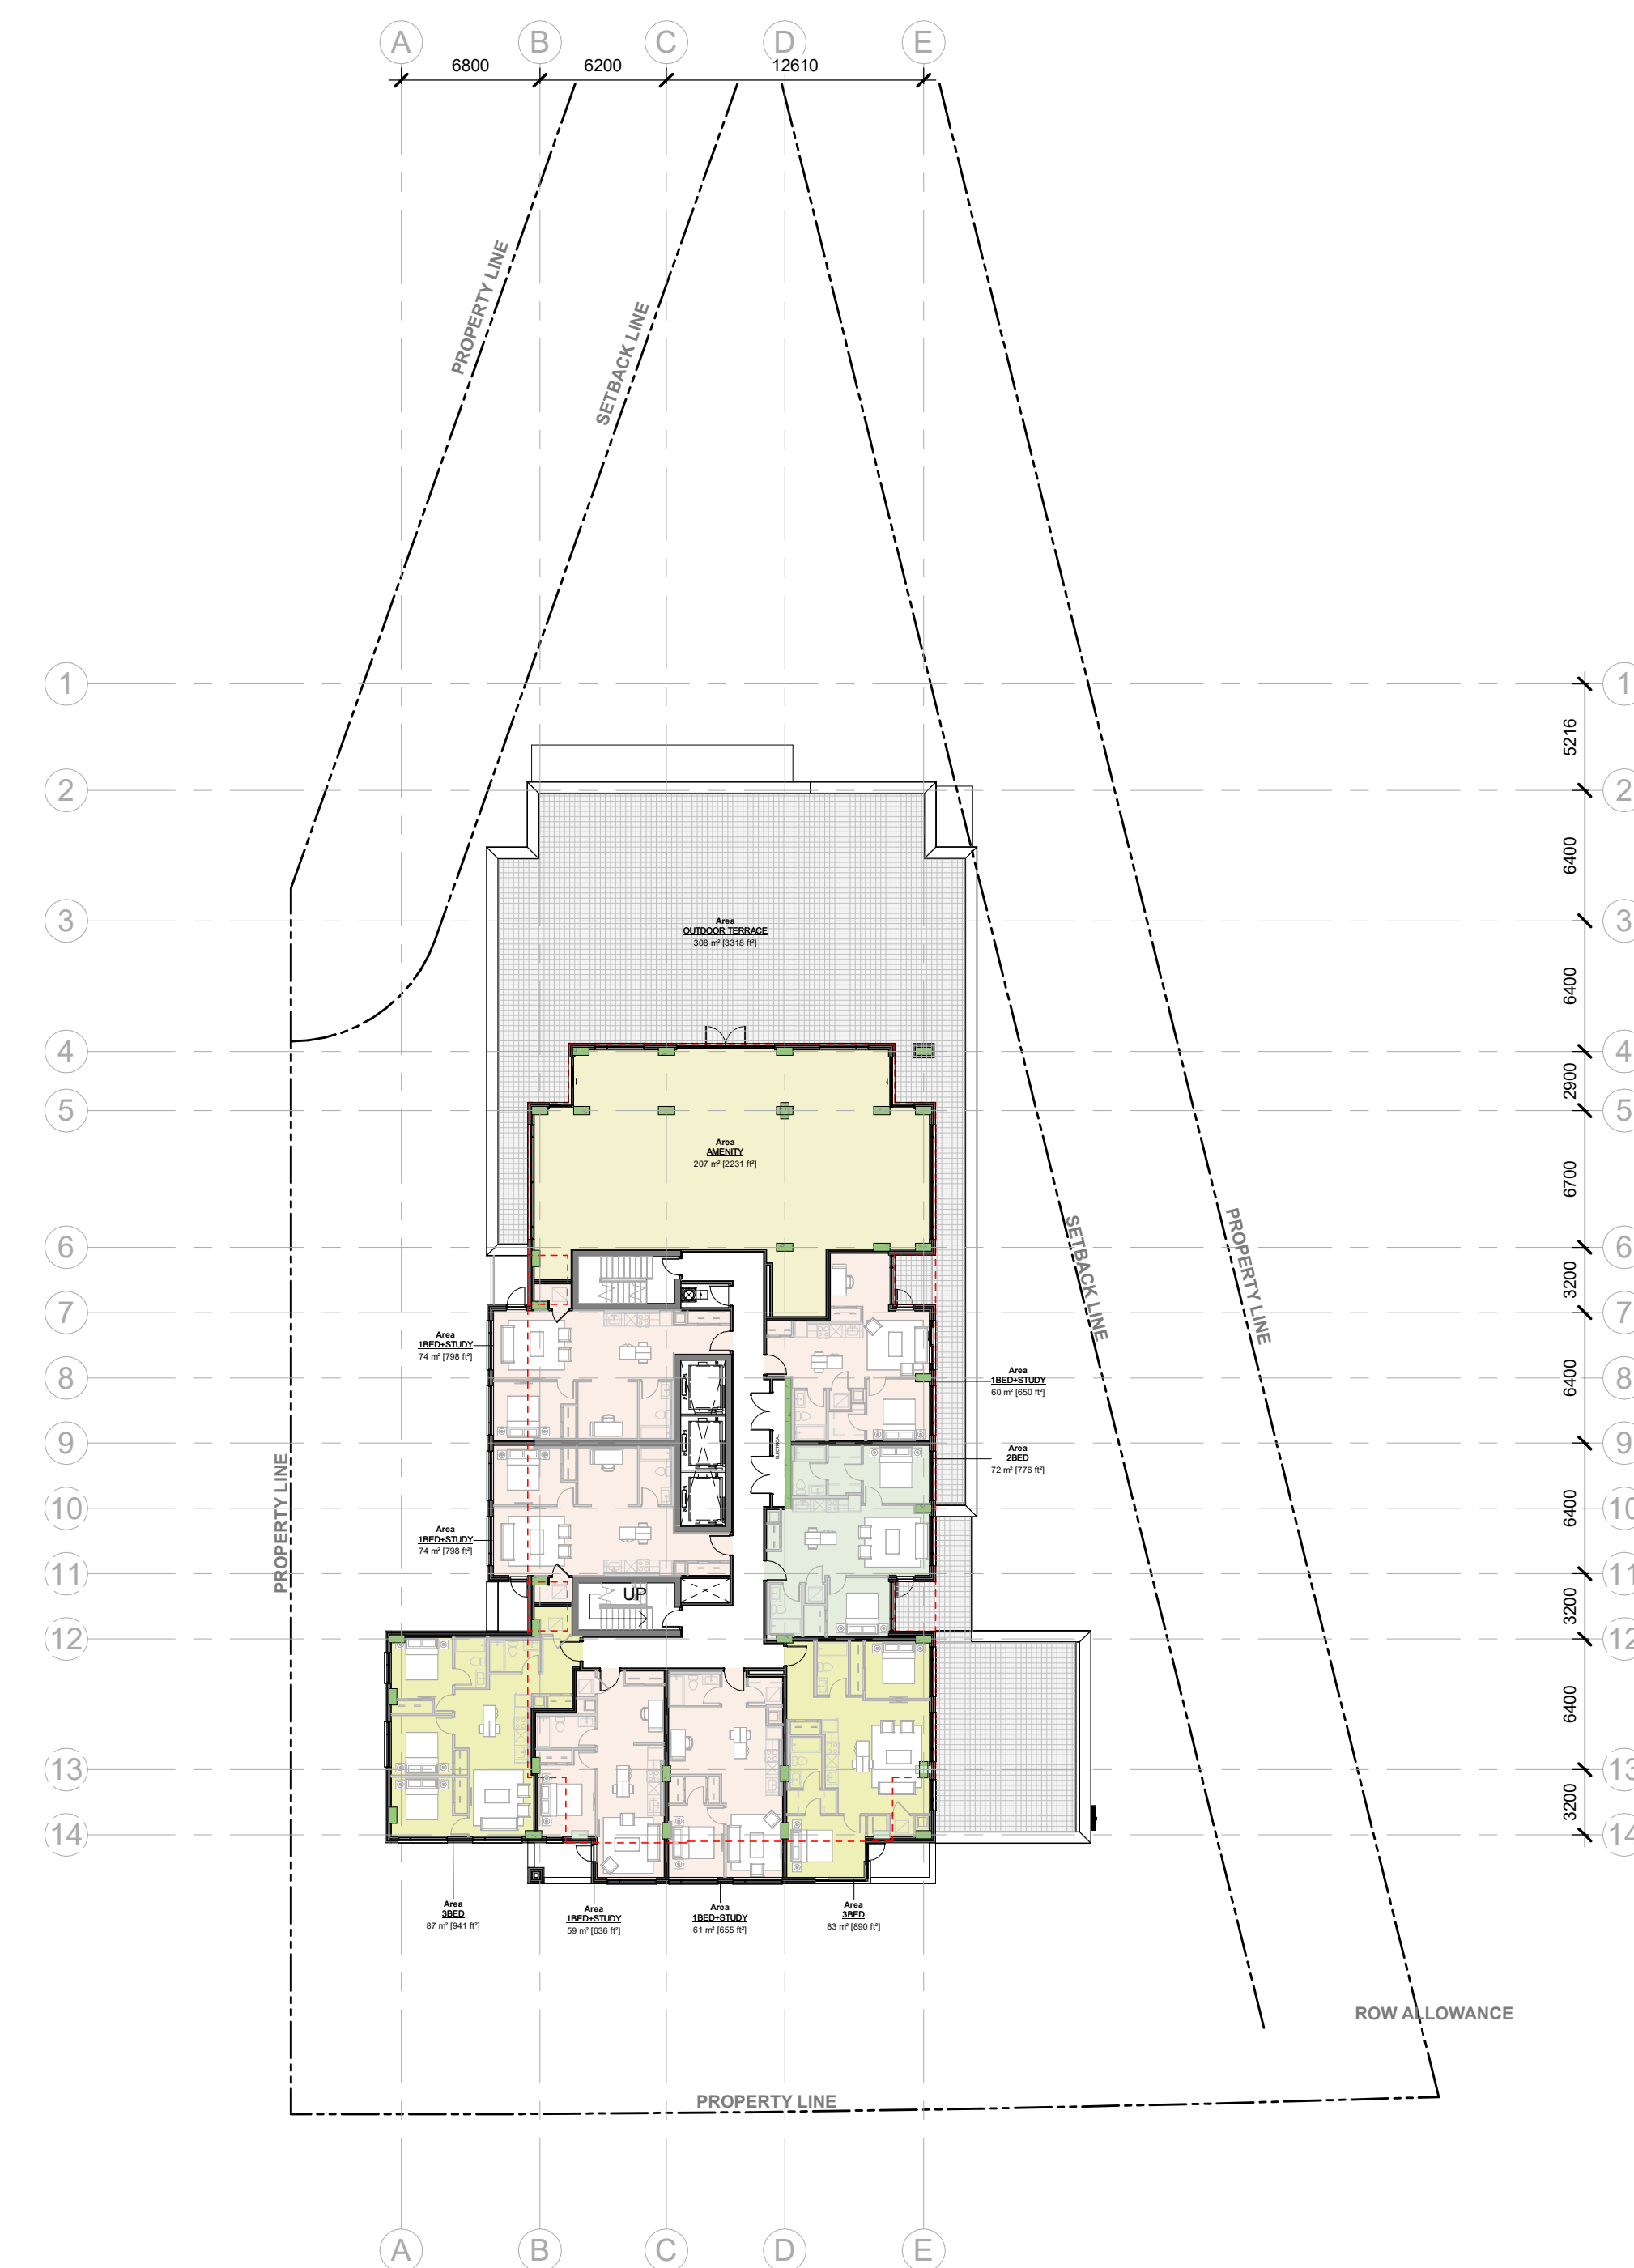

LEVEL 4 FLOOR PLAN

SPC 01 ISSUED FOR ZBLA APPLICATION	2024 12 13
No. DESCRIPTION	YYYY-MM-DD

ARCHITECT SEAL:  NORTH ARROW:  TRUE NORTH

CLIENT:  Owner

ARCHITECT:  56 Beech Street, Ottawa, Ontario K1S 3J6  
 t.613.724.9932 f.613.724.1209 www.rodericklahey.ca

PROJECT TITLE:  
 1815 MONTREAL RD

OTTAWA ON


SHEET TITLE:  
 FLOOR PLANS

DRAWN: Author	CHECKED: Checker
SCALE: 1 : 300	SHEET No.:
PROJECT No: 2405	A-102


PAPER SIZE: ISO Full Base B1 (707.00 x 1000.00mm)  
 PLOT DATE: 2024-12-11 11:45:52 AM

IT IS THE RESPONSIBILITY OF THE APPROPRIATE CONTRACTOR TO CHECK AND VERIFY ALL DIMENSIONS ON SITE AND TO REPORT ALL ERRORS AND/OR OMISSIONS TO THE ARCHITECT.  
 ALL CONTRACTORS MUST COMPLY WITH ALL PERTINENT CODES AND BY-LAWS.  
 THIS DRAWING MAY NOT BE USED FOR CONSTRUCTION UNTIL SIGNED BY THE ARCHITECT.  
 DO NOT SCALE DRAWINGS.  
 COPYRIGHT RESERVED.


WITHOUT PREJUDICE

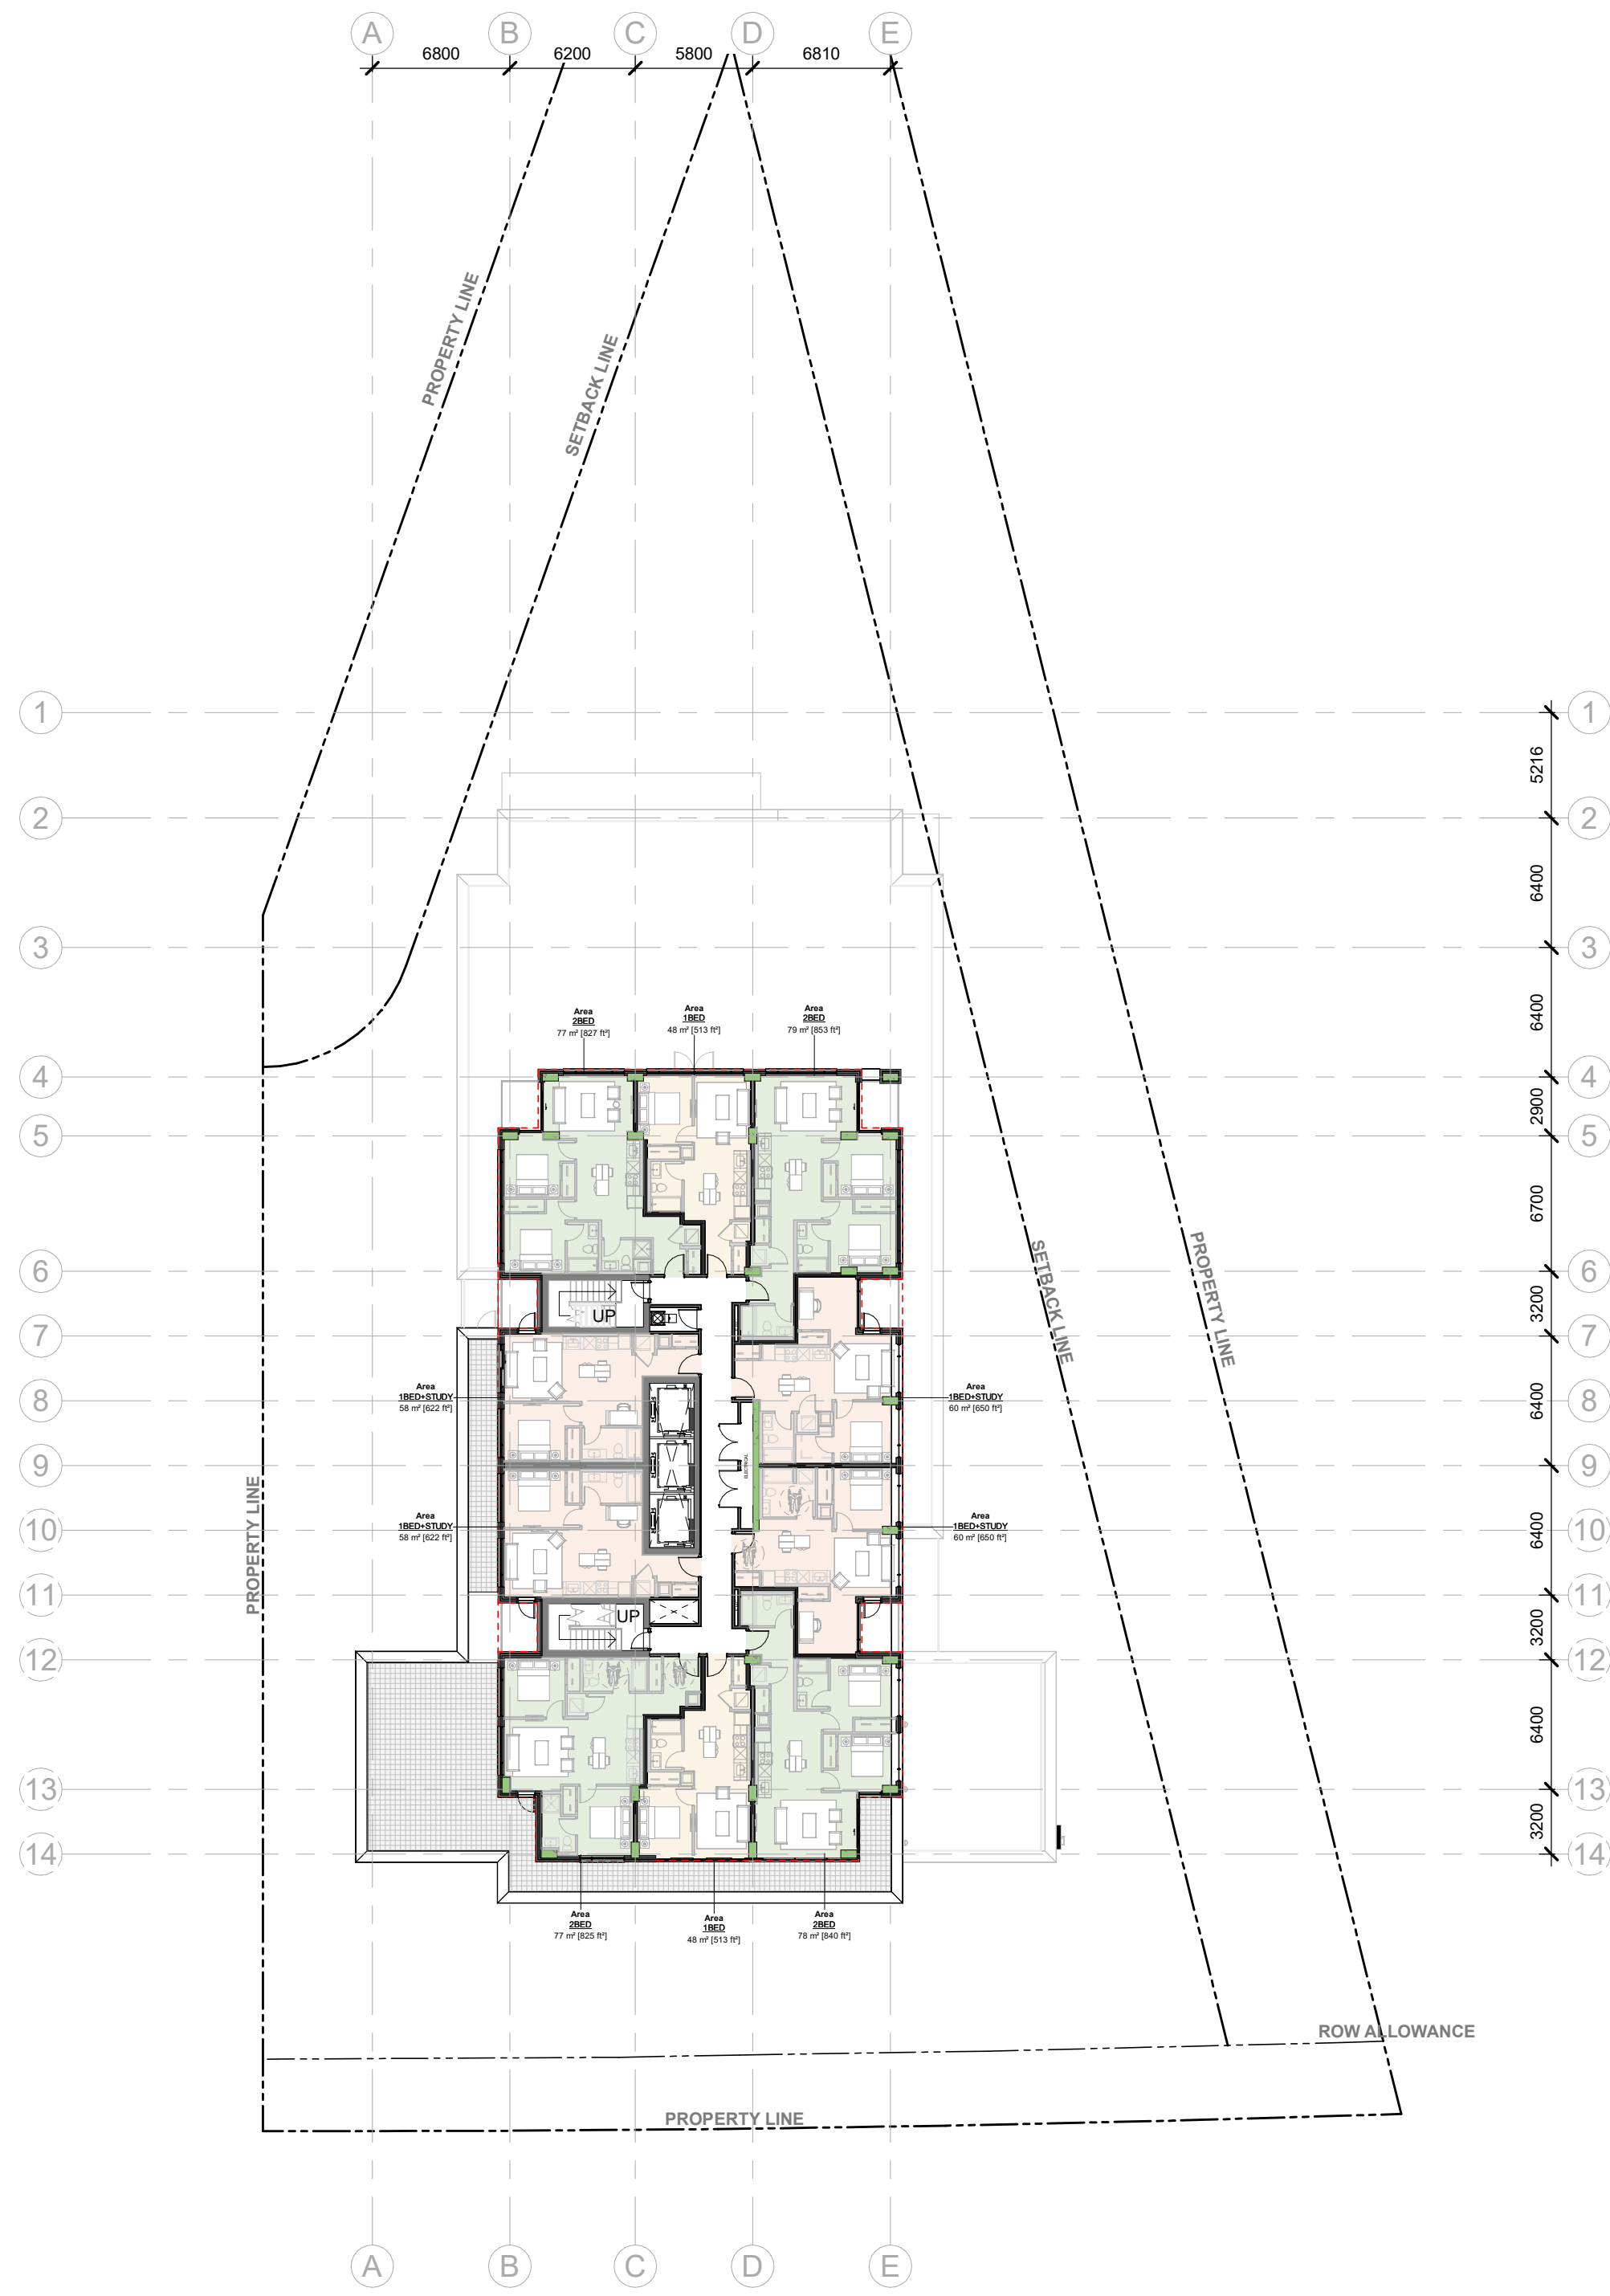

LEVEL 5 FLOOR PLAN

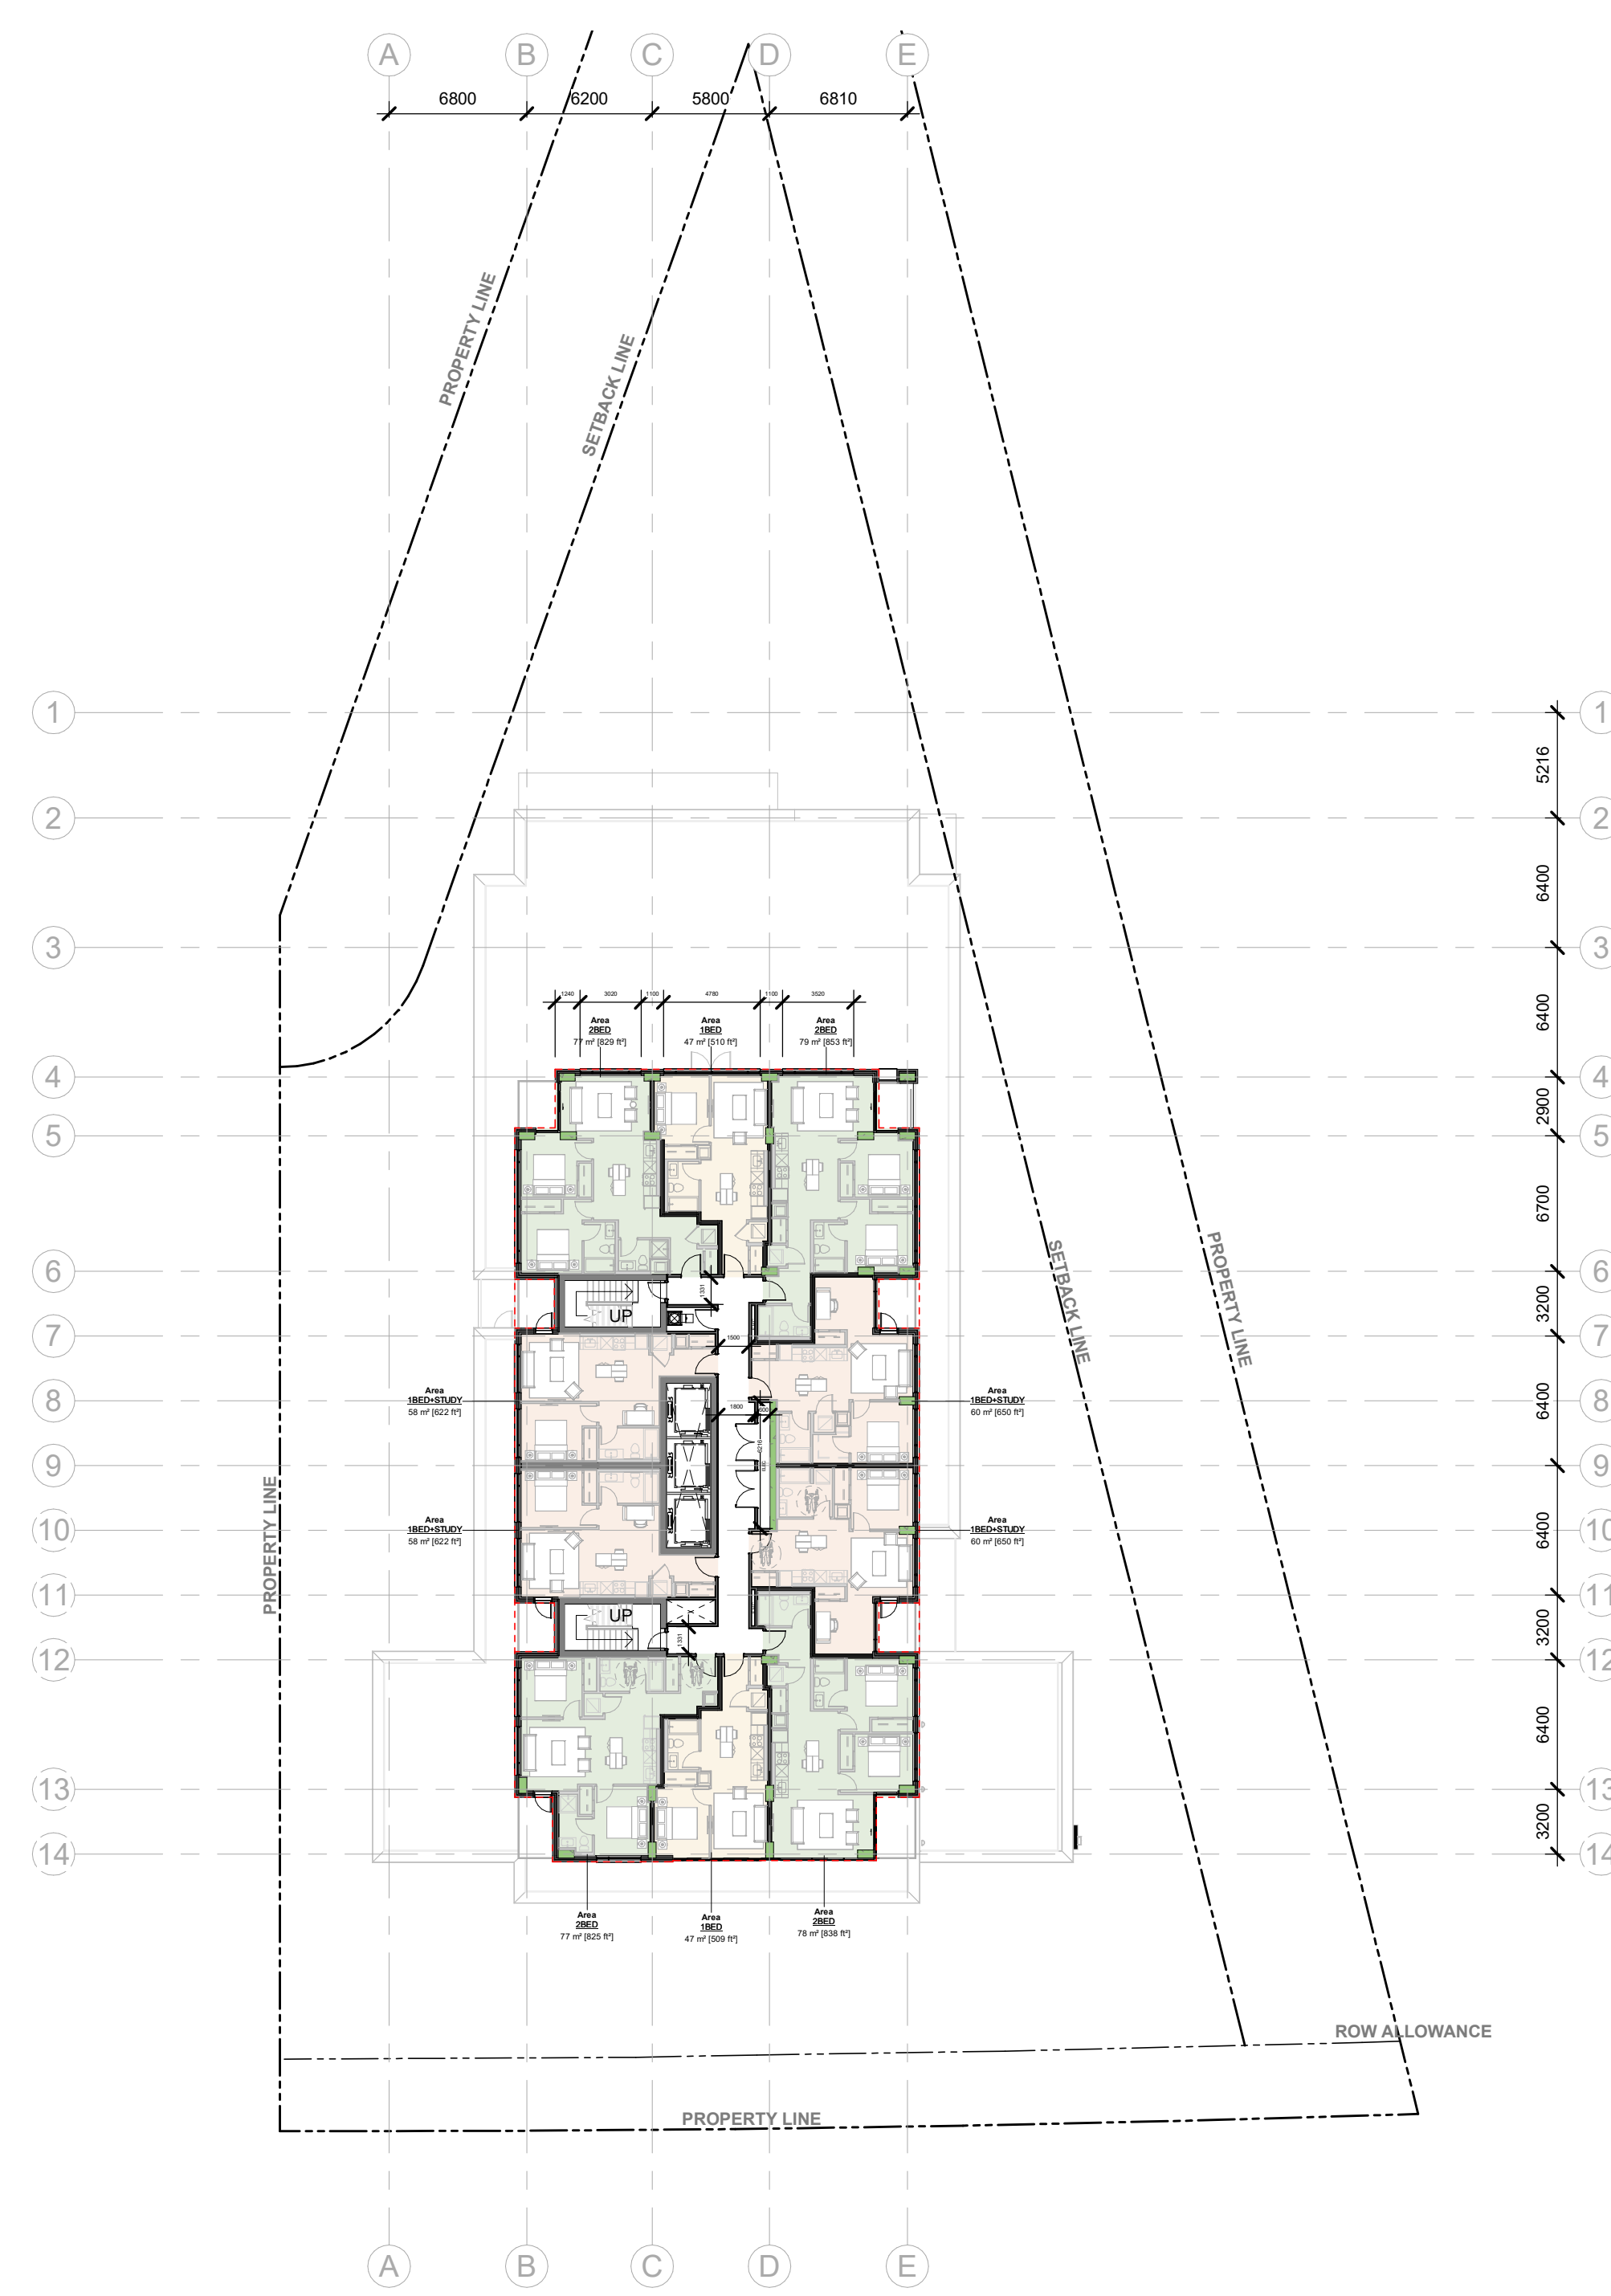

LEVEL 6-16 FLOOR PLAN

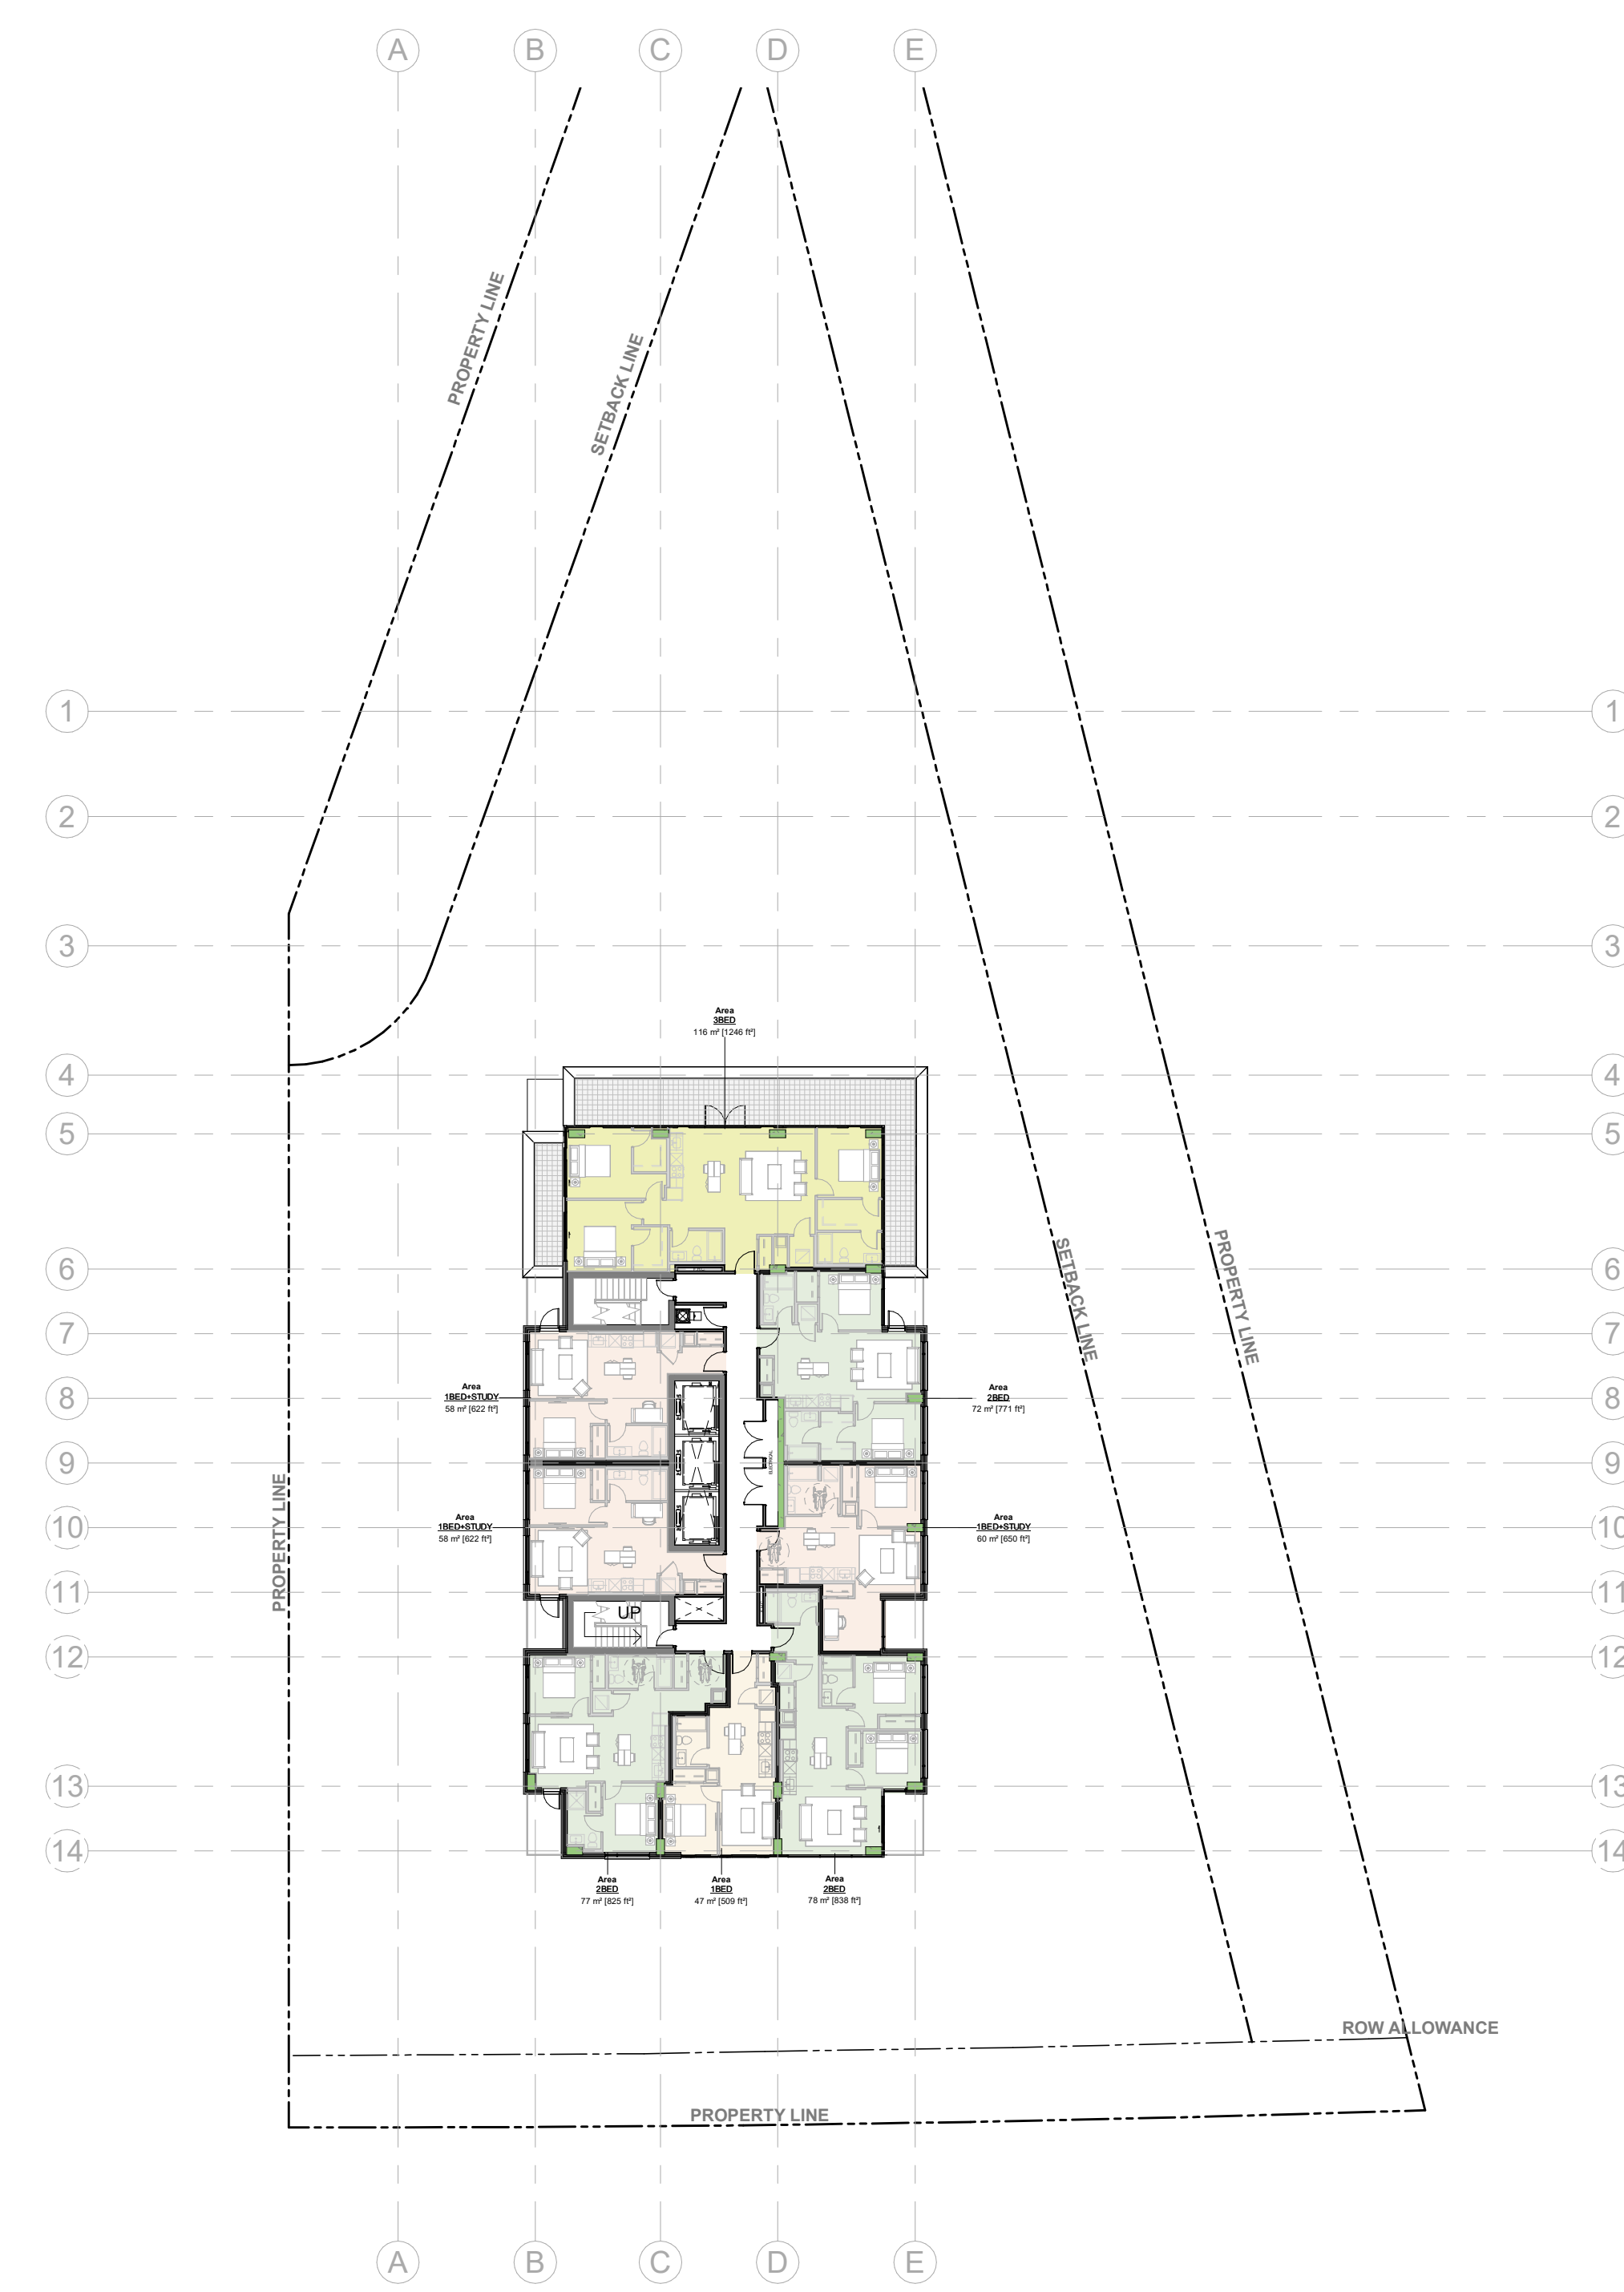

LEVEL 17 FLOOR PLAN

SPC 01 ISSUED FOR ZBLA APPLICATION	2024 12 13
No. DESCRIPTION	YYYY-MM-DD

ARCHITECT SEAL: NORTH ARROW:

CLIENT:

ARCHITECT:

PROJECT TITLE:  
1815 MONTREAL RD  
OTTAWA ON


SHEET TITLE:  
FLOOR PLANS

DRAWN: Author	CHECKED: Checker
SCALE: 1 : 300	SHEET No.:
PROJECT No.:	A-103
2405	

PAPER SIZE: ISO Full Base B1 (707.00 x 1000.00mm)  
 PLOT DATE: 2024-12-11 11:44:10 AM

IT IS THE RESPONSIBILITY OF THE APPROPRIATE CONTRACTOR TO CHECK AND VERIFY ALL DIMENSIONS ON SITE AND TO REPORT ALL ERRORS AND/OR OMISSIONS TO THE ARCHITECT.  
 ALL CONTRACTORS MUST COMPLY WITH ALL PERTINENT CODES AND BY-LAWS.  
 THIS DRAWING MAY NOT BE USED FOR CONSTRUCTION UNTIL SIGNED BY THE ARCHITECT.  
 DO NOT SCALE DRAWINGS.  
 COPYRIGHT RESERVED.

WITHOUT PREJUDICE

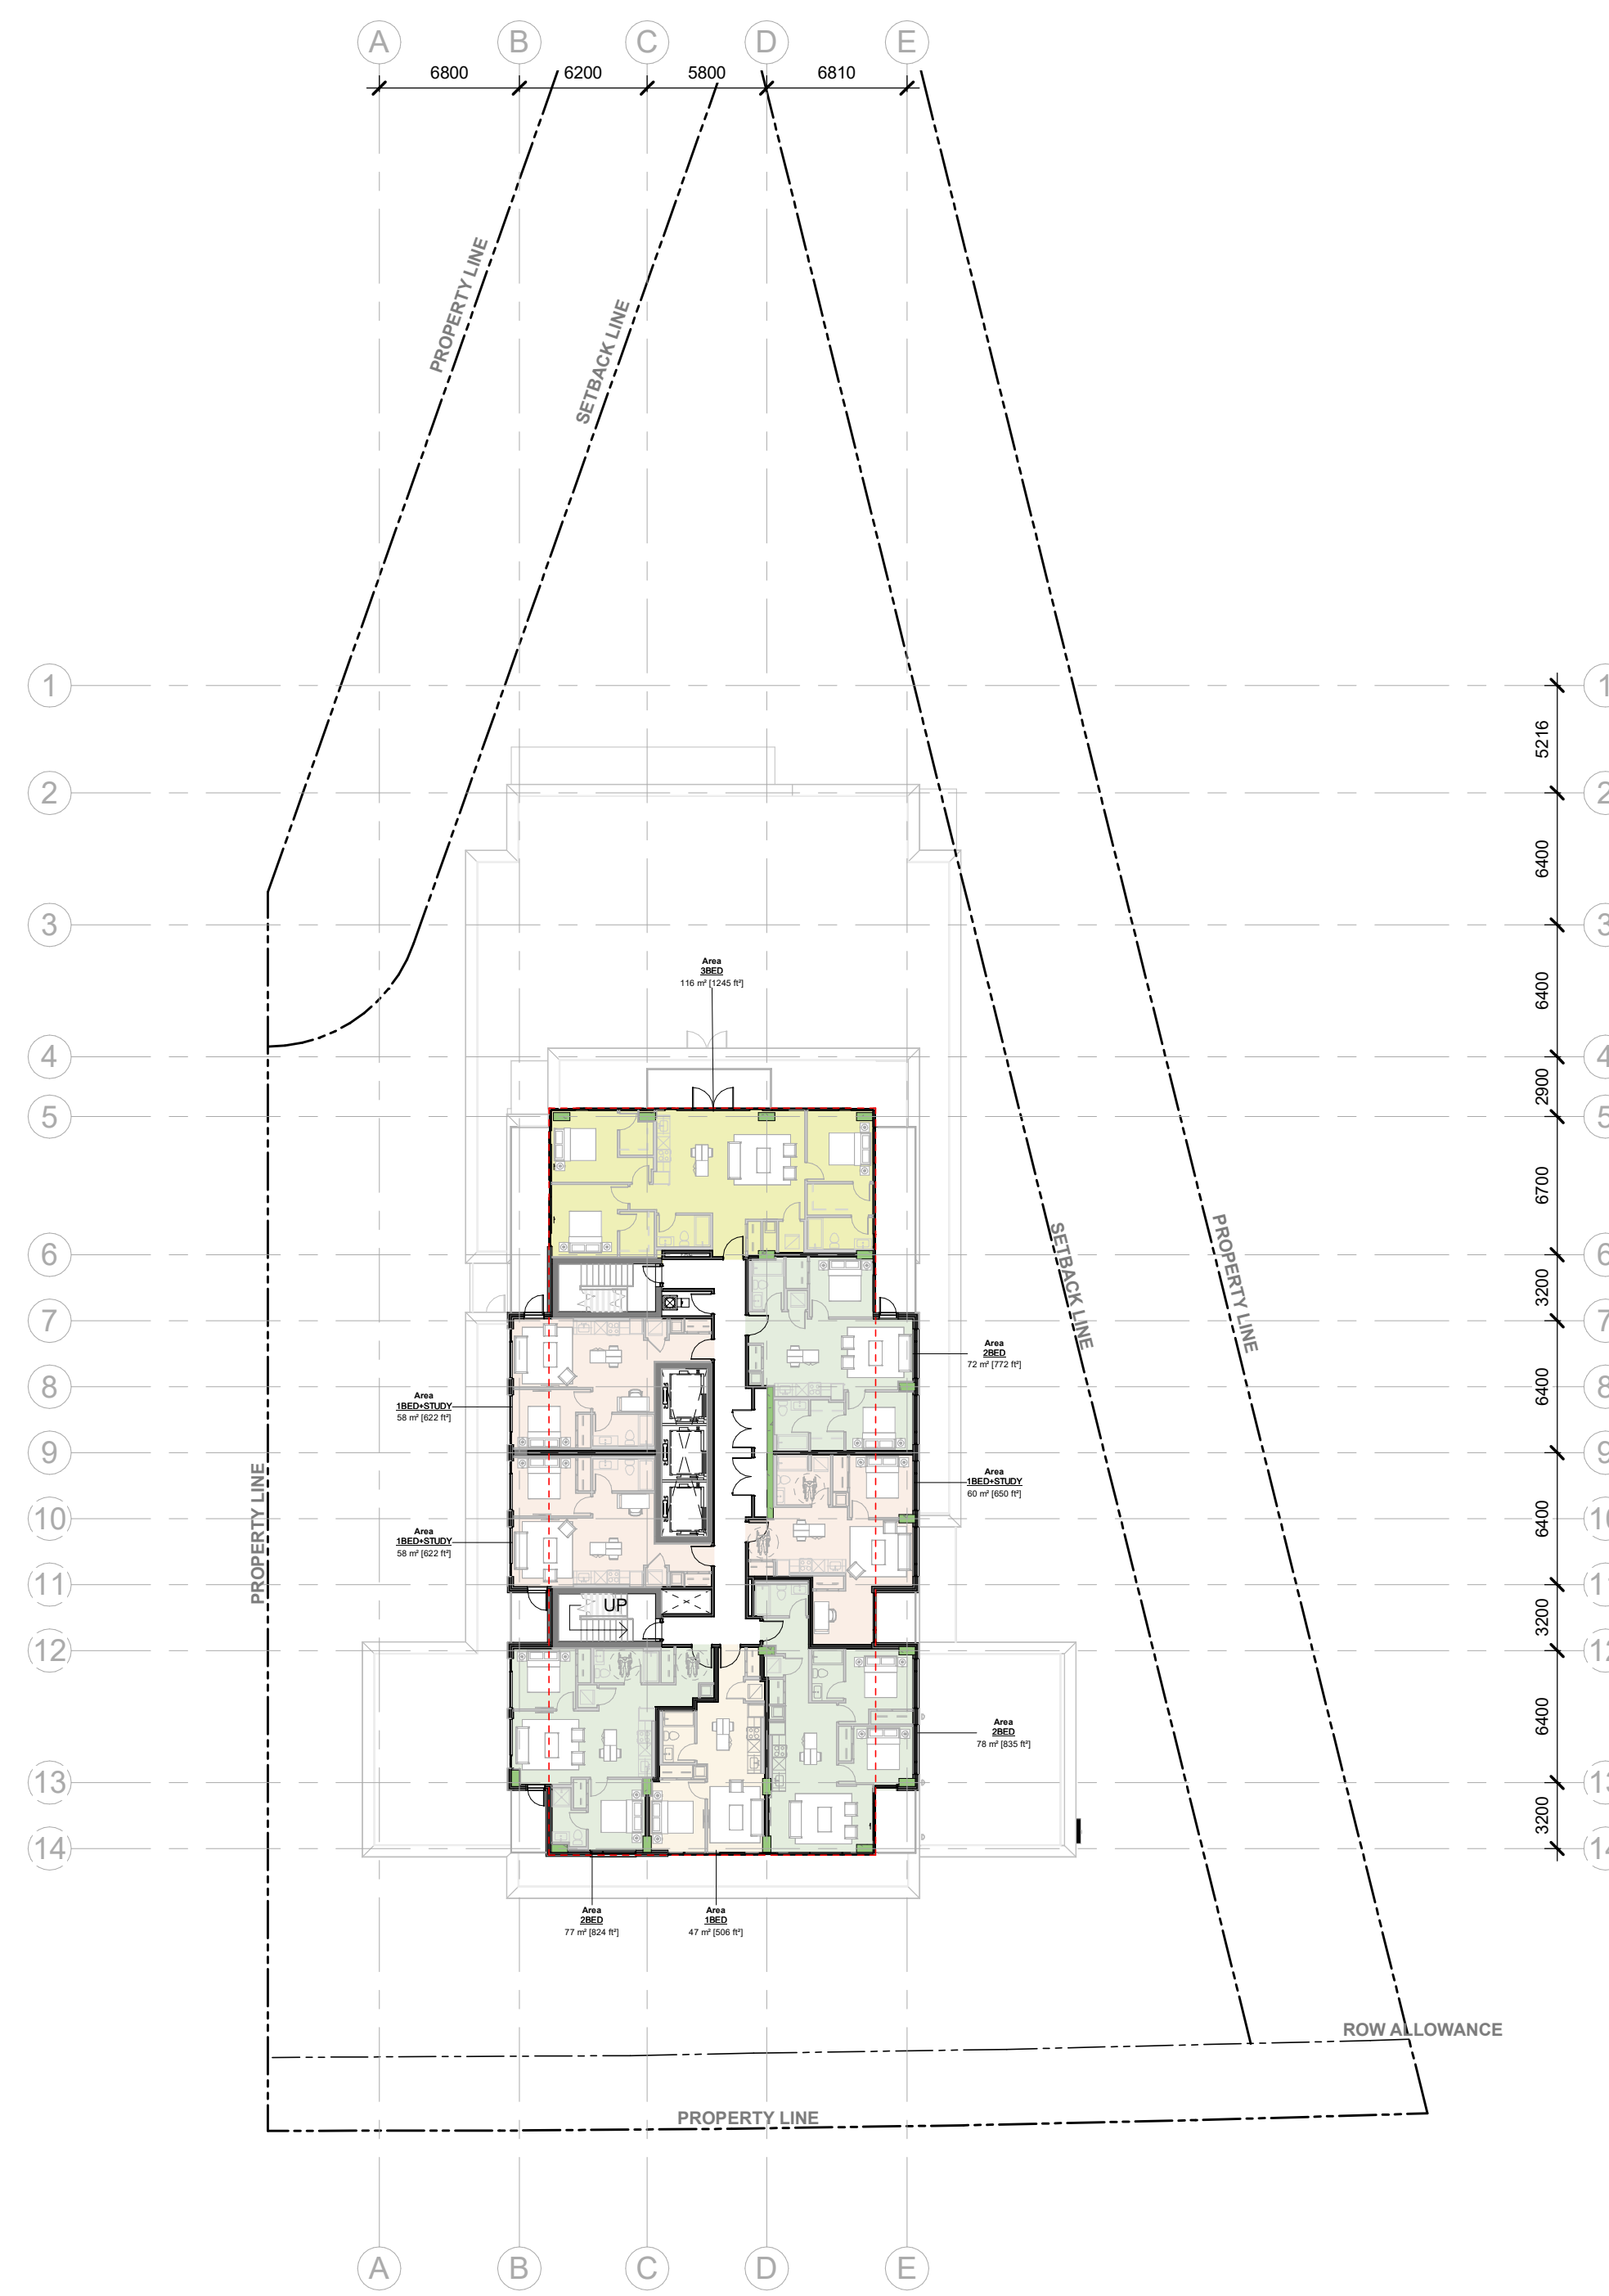

LEVEL 18 FLOOR PLAN



LEVEL 19 FLOOR PLAN



AMENITY / MECHANICAL FLOOR PLAN

SPC 01 ISSUED FOR ZBLA APPLICATION	2024 12 13
No. DESCRIPTION	YYYY-MM-DD

REVISIONS:

ARCHITECT SEAL:	NORTH ARROW:

CLIENT:

ARCHITECT:

56 Beech Street, Ottawa, Ontario K1S 3J6  
 t.613.724.9932 f.613.724.1209 www.rodericklahey.ca

PROJECT TITLE:  
 1815 MONTREAL RD  
 OTTAWA ON

SHEET TITLE:  
 FLOOR PLANS

DRAWN: Author	CHECKED: Checker
SCALE: 1 : 300	SHEET No.:
PROJECT No.:2405	A-104

PAPER SIZE: ISO Full Base B1 (707.0x 1000.0mm)  
 PLOT DATE: 2024-12-11 11:44:53 AM