

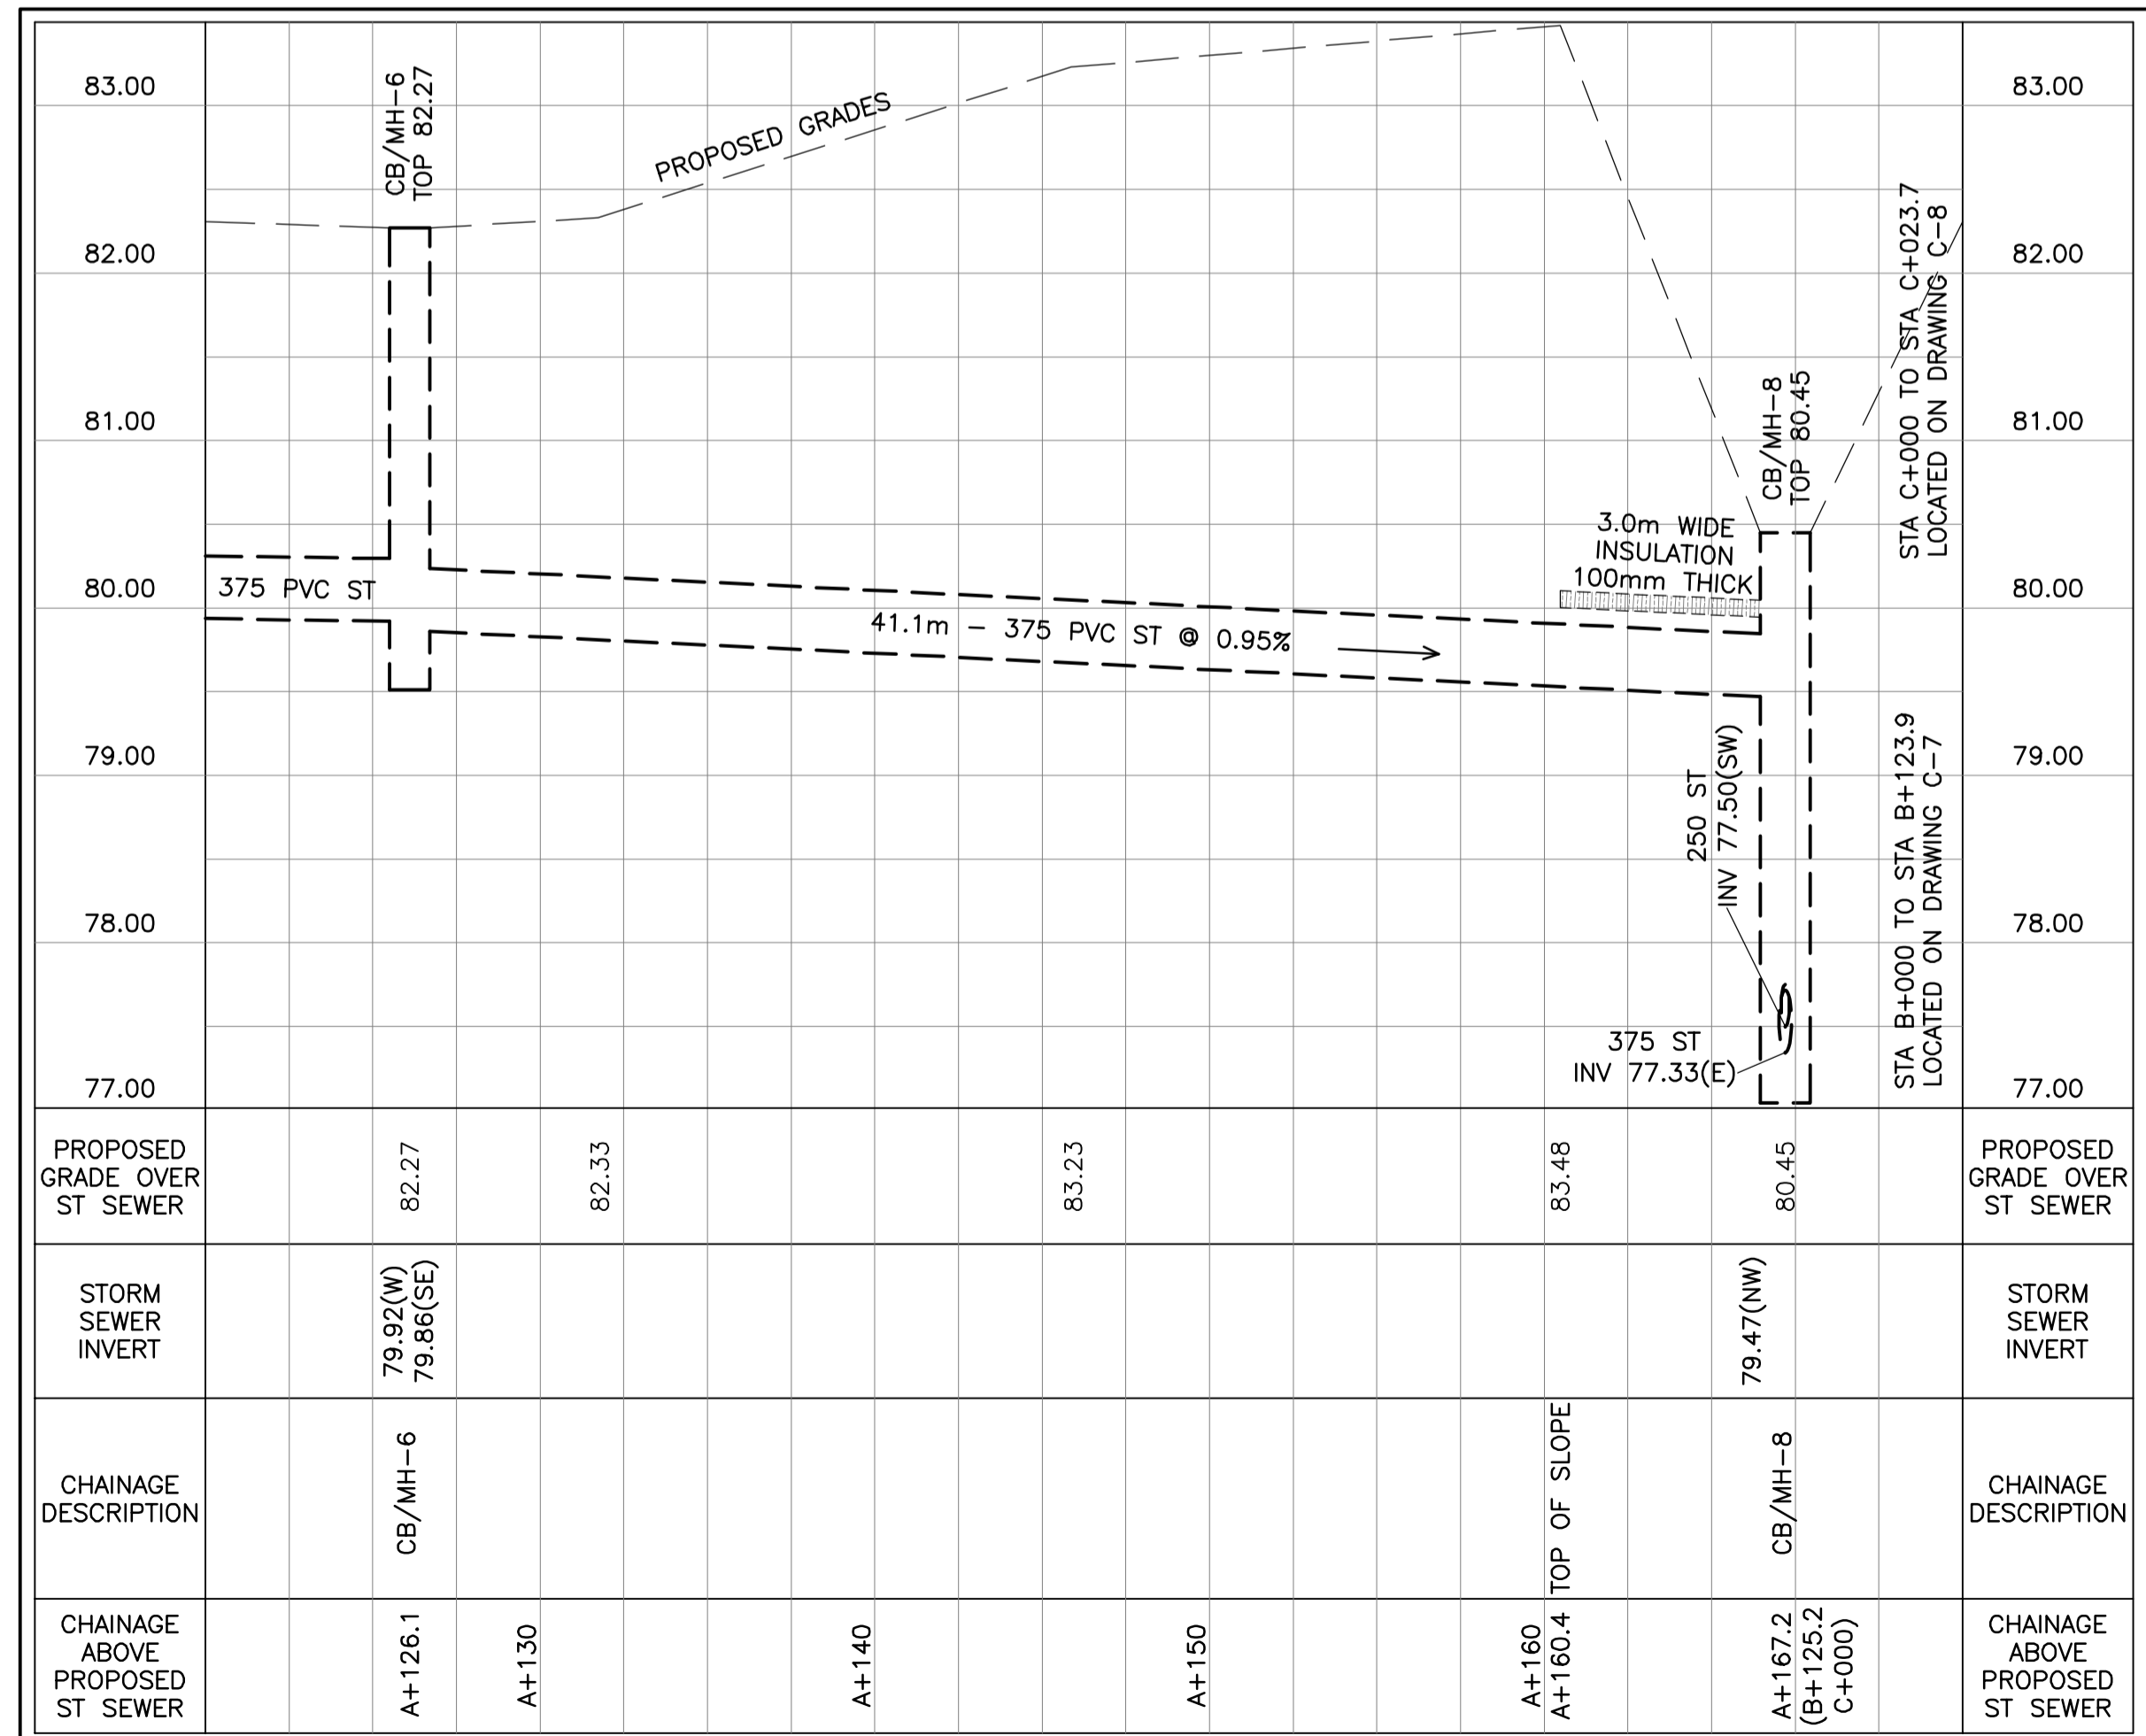
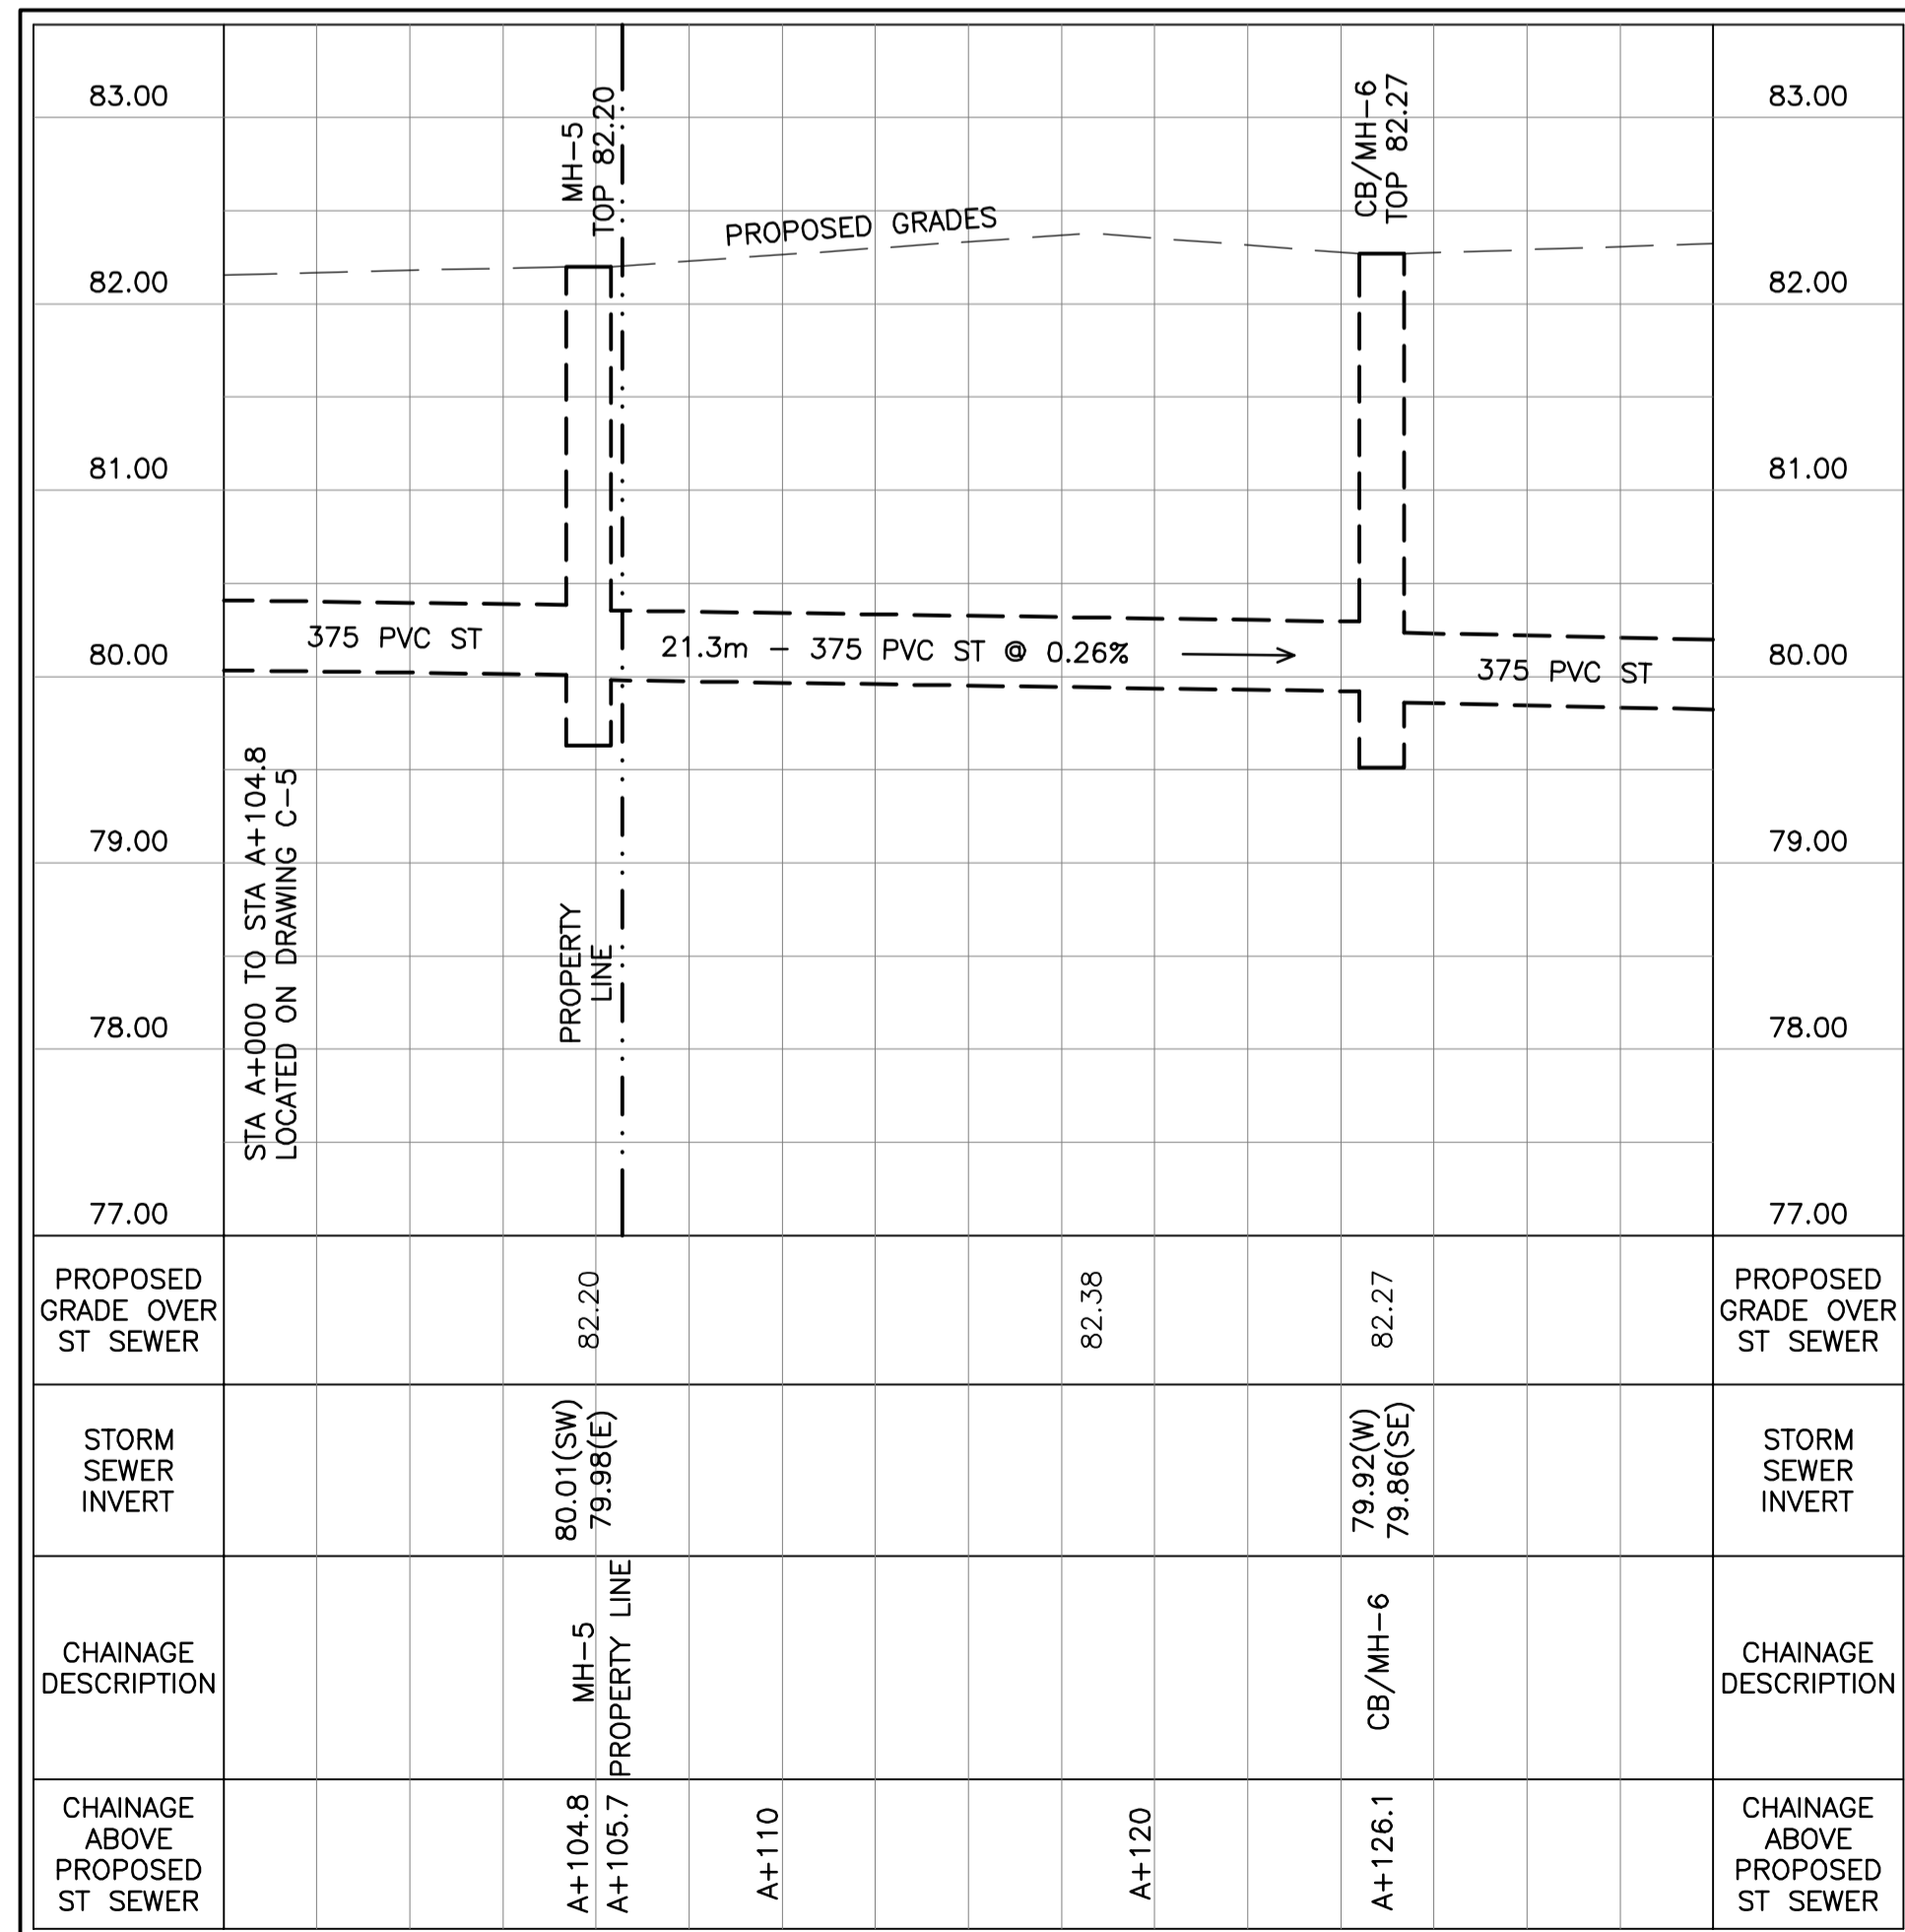


REFER TO NOTES, DETAILS &
SCHEDULES ON DRAWINGS
C-9 & C-10

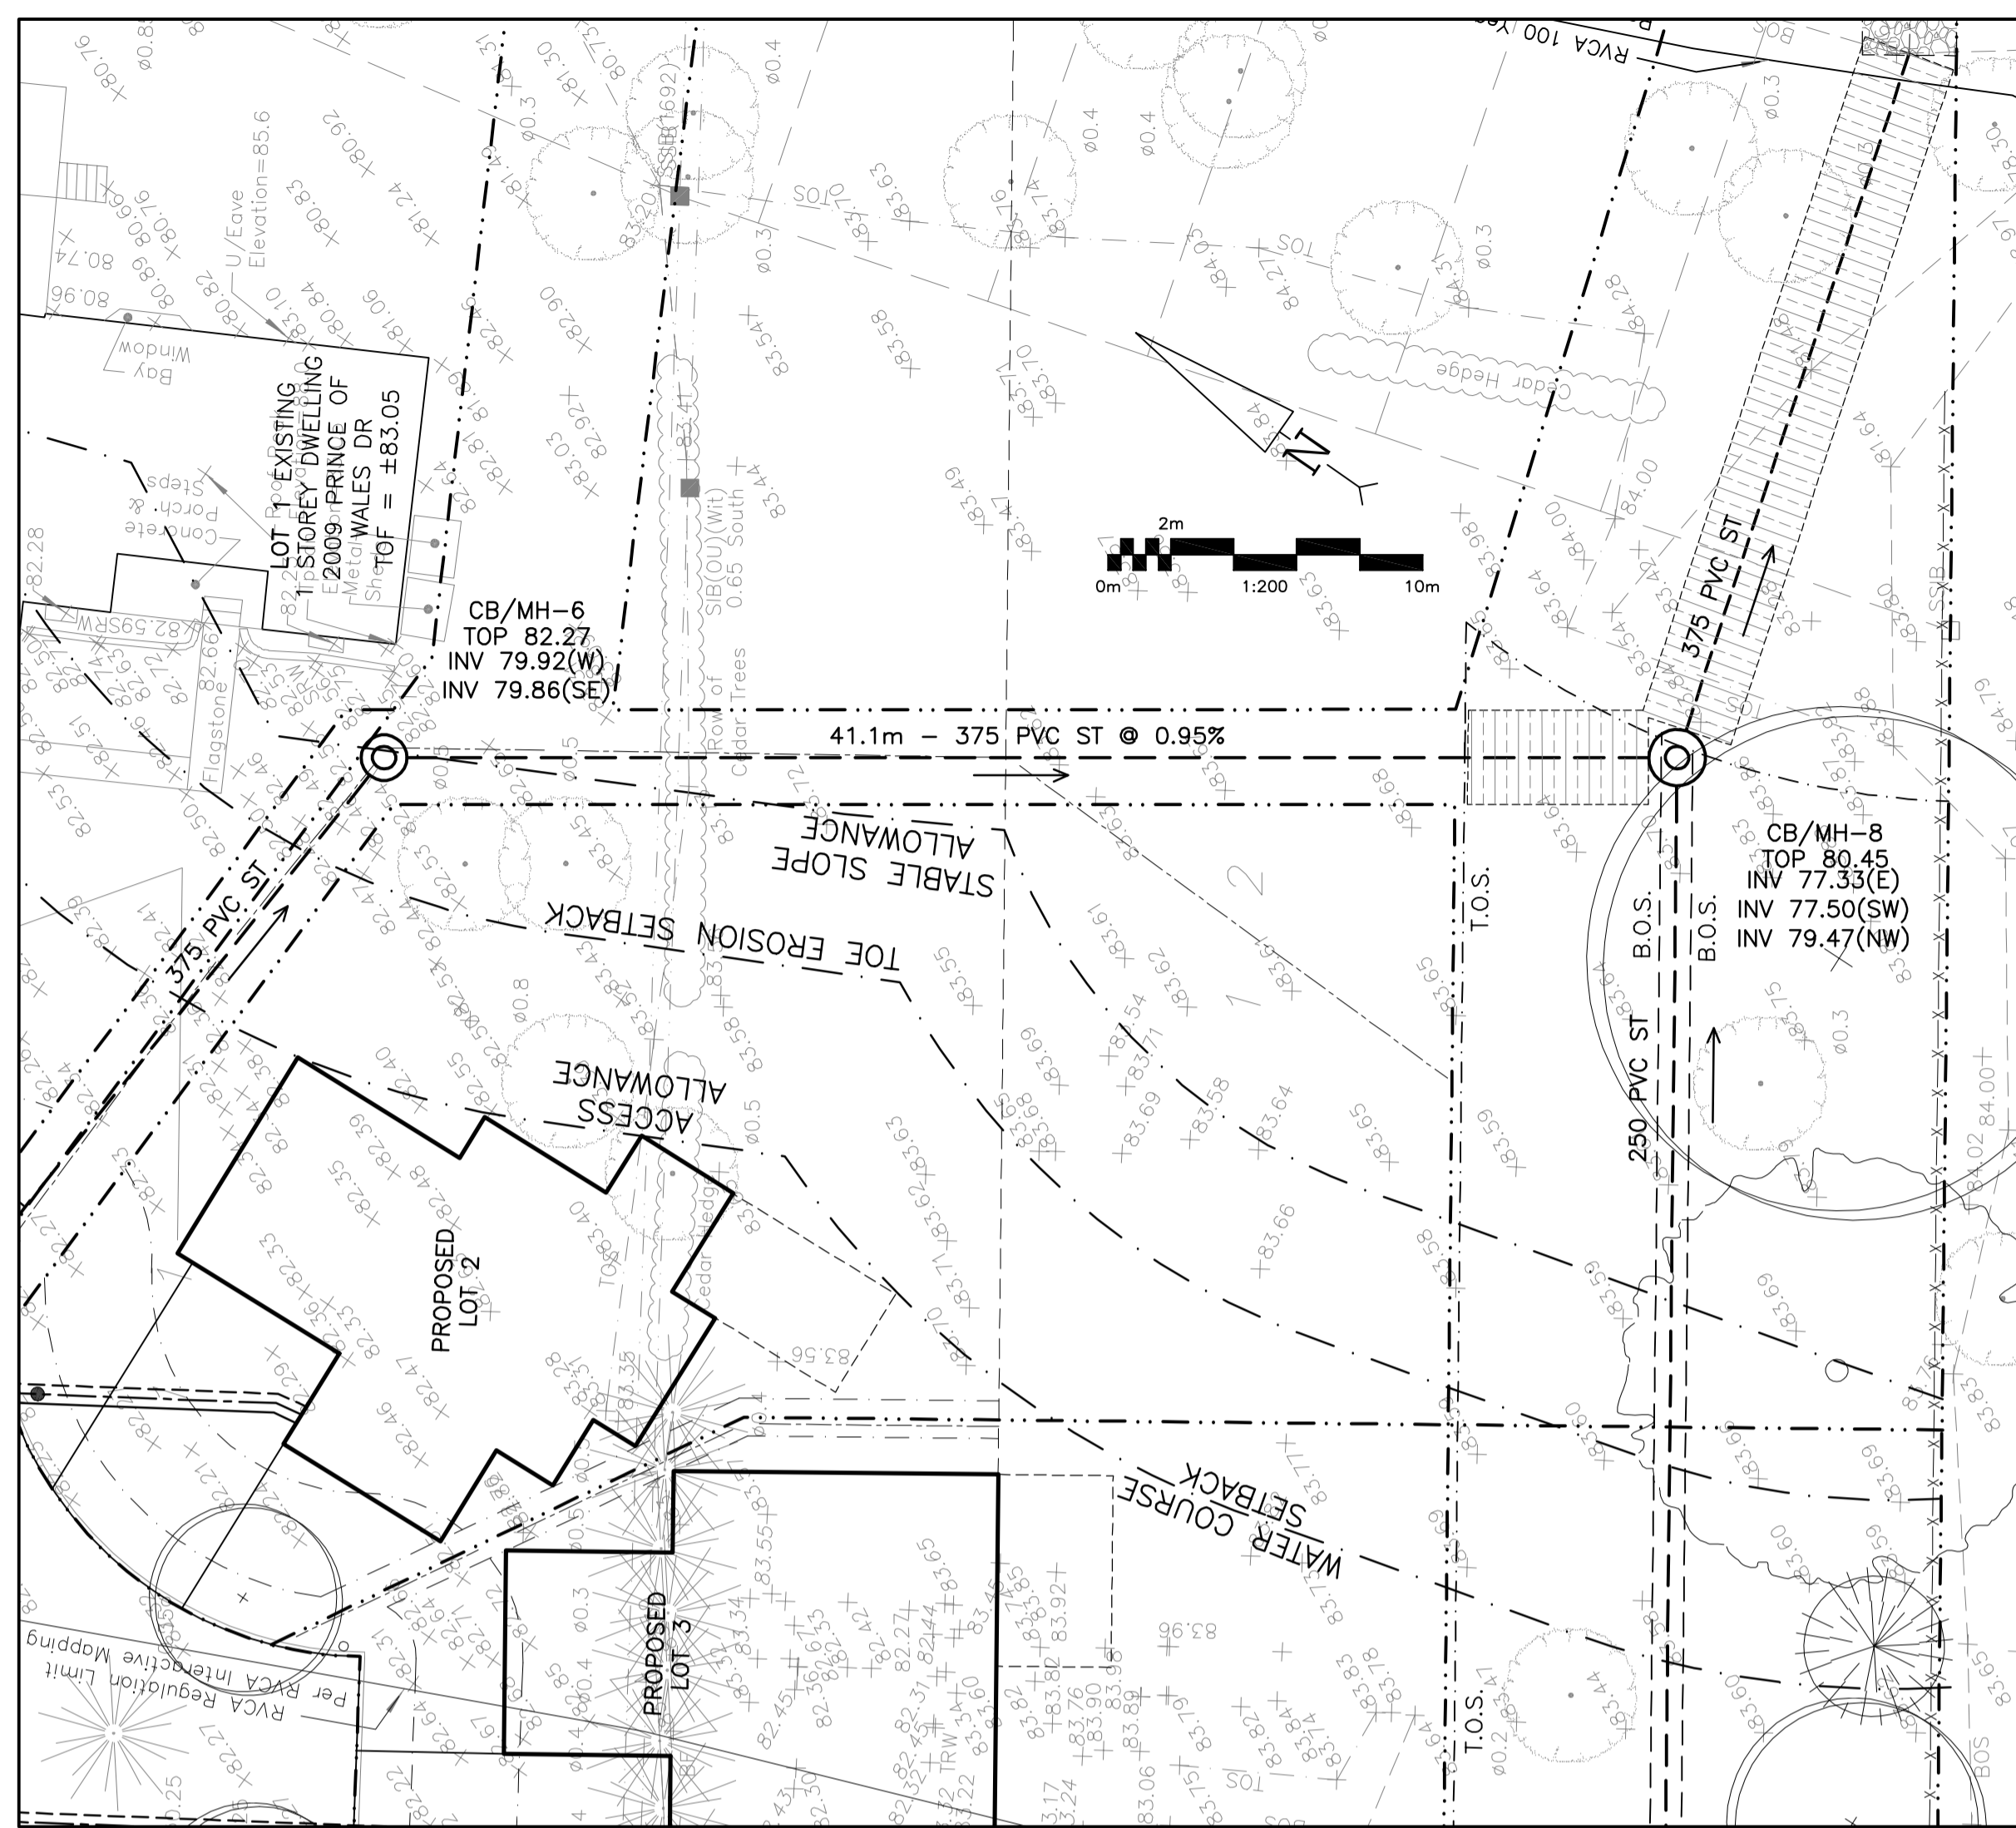

LEGEND

- F.F.L. FINISHED FLOOR ELEVATION
- T.O.F. TOP OF FOUNDATION
- B.F.L. BASEMENT FLOOR ELEVATION
- U.S.F. UNDERSIDE OF FOOTING
- PROPERTY LINE
- C.R.Z. CRITICAL ROOT ZONE
- CB CATCH-BASIN
- MH STORM MANHOLE
- CB/MH CATCH-BASIN/MANHOLE
- MH SANITARY MANHOLE
- VC VALVE CHAMBER
- FH FIRE HYDRANT
- VB VALVE & VALVE BOX
- SAN SANITARY SEWER
- ST STORM SEWER
- WS/WM WATER SERVICE/WATERMAIN
- SPL SPRINGLINE OF PIPE
- INV INVERT OF PIPE
- T.O.S. TOP OF SLOPE
- B.O.S. BOTTOM OF SLOPE
- CENTERLINE OF SWALE
- 150mm BARRIER CURB
- D.C. DEPRESSED CURB
- ROAD CUT REINSTATEMENT

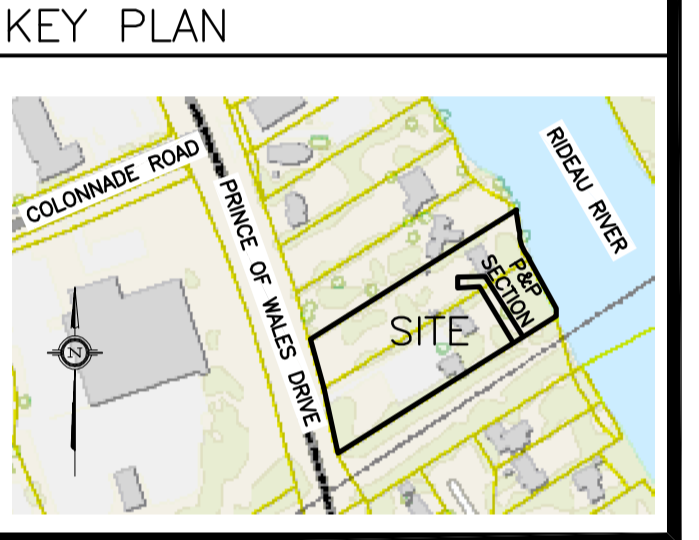

No.	DATE	REVISION
1	JAN 28-25	RE-ISSUED FOR APPROVAL

D. B. GRAY ENGINEERING INC.
 Stormwater Management • Grading & Drainage • Storm & Sanitary Sewers • Watermain
 700 Long Point Circle 613-425-8044
 Ottawa, Ontario d.gray@dbgrayengineering.com

Project
PROPOSED 7 LOT DEVELOPMENT
2009-2013 PRINCE OF WALES DR
 OTTAWA, ONTARIO

Drawing Title
PLAN AND PROFILE
 STA A+104.8 TO A+167.2

Engineer's Seal

 NOT VALID UNLESS SIGNED & DATED

Drawn D.B.G.
 H. Scale 1:200
 V. Scale 1:40
 Date JUN 29-23
 Job No. 22055

Drawing No.
C-6
 of 10

D02-02-23-0061 & D07-16-23-0009