


LEGEND

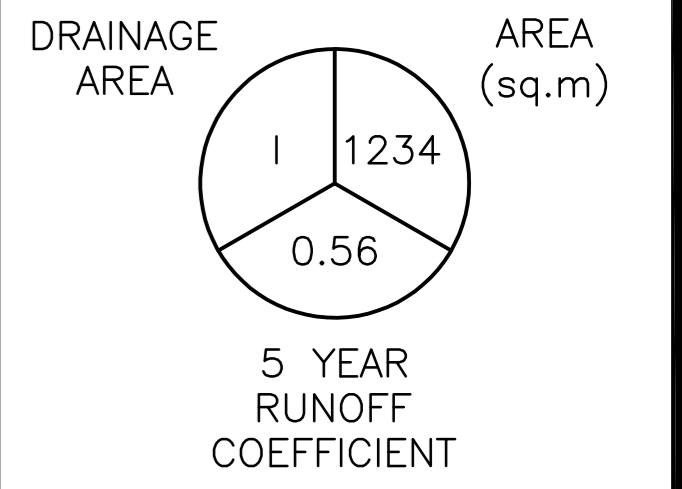

KEY PLAN



No.	DATE	REVISION
2	AUG 8-20	ISSUED FOR APPROVAL
1	AUG 4-20	ISSUED FOR COORDINATION

D. B. GRAY ENGINEERING INC.
Stormwater Management • Grading & Drainage • Storm & Sanitary Sewers • Watermain
700 Long Point Circle 613-425-8044
Ottawa, Ontario d.gray@dbgrayengineering.com

Project
PROPOSED 3 STOREY STACKED TOWNHOMES
240 FERLAND STREET
OTTAWA, ONTARIO

Drawing Title
DRAINAGE PLAN

	Engineer's Seal
	Drawn D.B.G. Hor. Scale 1:100 Vert. Scale Date AUG 4-20 Job No. 19073
	Drawing No. C-7 of 7

NOT VALID UNLESS SIGNED & DATED

