



**LEGEND**

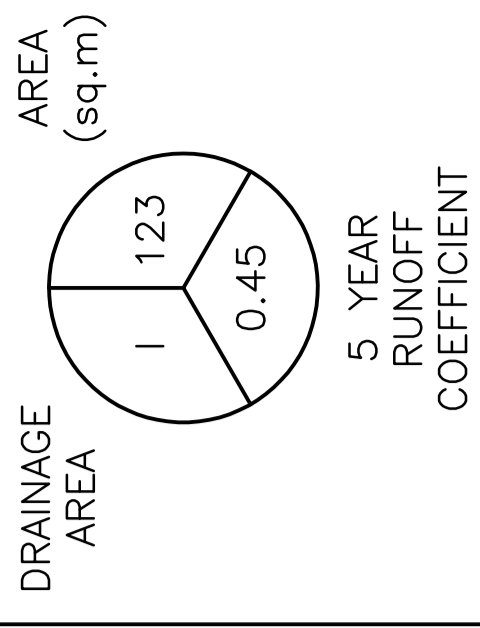

**KEY PLAN**

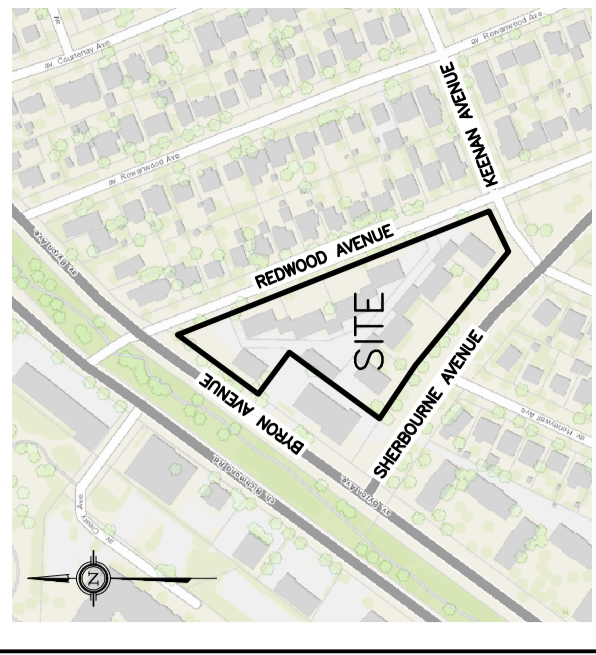

No.	DATE	REVISION
3	SEP 2-20	ISSUED FOR APPROVAL
2	AUG 26-20	ISSUED FOR COORDINATION
1	JUL 28-20	PRELIMINARY

**D. B. GRAY ENGINEERING INC.**  
 Professional Engineer  
 700 Long Point Circle  
 Ottawa, Ontario  
 613-425-8044  
 dgray@dbgrayengineering.com

**SHERBOURNE DEVELOPMENT**  
**455-483 SHERBOURNE AVE**  
 OTTAWA, ONTARIO

**DRAINAGE PLAN**

Engineer's Seal  
 D.B. GRAY  
 700 LONG POINT CIRCLE  
 OTTAWA, ONTARIO  
 SEP 2-20

Drawn: D.B.G.  
 Horz. Scale: 1:200  
 Vert. Scale: 1:20  
 Date: JUL 28-20  
 Rev. No.: 20043

Drawing No. **C-8** of **8**

NOT VALID UNLESS SIGNED & DATED

