


**LEGEND**

DRAINAGE AREA

AREA (sq.m)

I 1234  
0.56

5 YEAR RUNOFF COEFFICIENT

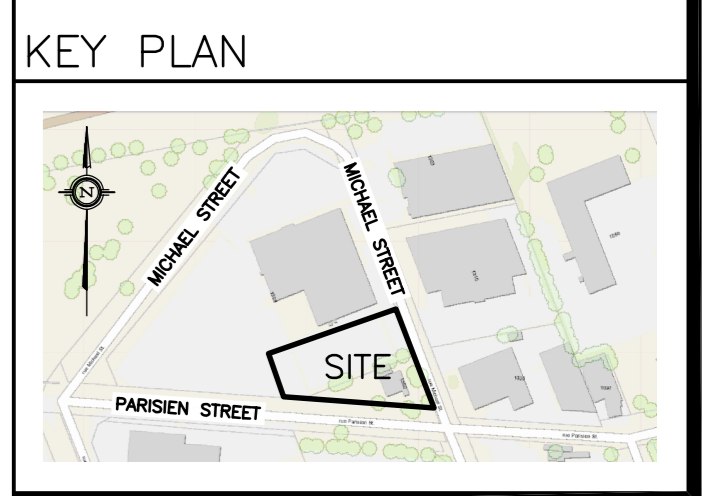


No.	DATE	REVISION
2	JAN 12-22	ISSUED FOR APPROVAL
1	JAN 11-22	ISSUED FOR COORDINATION

**D. B. GRAY ENGINEERING INC.**  
 Stormwater Management - Grading & Drainage - Storm & Sanitary Sewers - Watermain  
 700 Long Point Circle 613-425-8044  
 Ottawa, Ontario d.gray@dbgrayengineering.com

Project  
**PROPOSED 2 STOREY VOLVO DEALERSHIP**  
 1328 MICHAEL STREET  
 OTTAWA, ONTARIO

Drawing Title  
**DRAINAGE PLAN**

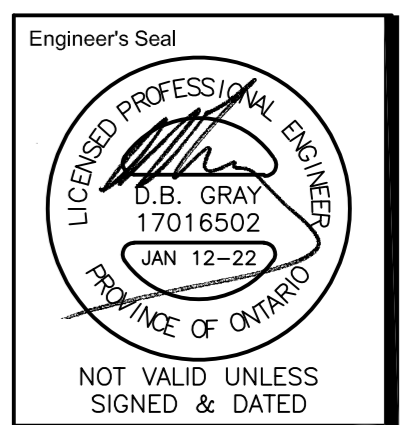

Drawn D.B.G.  
 H. Scale 1:200  
 V. Scale  
 Date NOV 2-21  
 Job No. 21014

Drawing No.  
**C-6**  
 of 6

