


EXTERIOR FIXTURE SCHEDULE			
TYPE	DESCRIPTION	LAMPS	MTG HT Ⓞ
A	12"W x 7"D x 9"H LED, 120V, 60W, WALL PACK WEDGED FIXTURE, SINGLE CAST ALUMINUM HOUSING, FULLY GASKETED FOR MOISTURE AND DUST, FINISH ARCH SELECT POWDER COATED MODEL: WDGE2-LED-P2-30K-80CRI-VF-MVOLT-SRM OR APPROVED EQUIVALENT	2000 LUMEN 3000K	WALL PACK

LEGEND		
SYMBOL	DESCRIPTION	MTG HT Ⓞ
• □	POLE MOUNTED LIGHT FIXTURE	AS NOTED
□	WALL MOUNTED LIGHT FIXTURE	AS NOTED
□	WALL MOUNTED LIGHT FIXTURE (WALLPACK TYPE)	AS NOTED
☉	DIRECTIONAL/AIMED FIXTURE	GROUND
☐	FLOOD LIGHT	GROUND
☐	PHOTO SENSOR	AS NOTED
☐	TIME CLOCK	AS NOTED

ELECTRICAL DRAWING LIST	
E000	ELECTRICAL DRAWING LIST, LEGEND, NOTES AND SCHEDULES
E001	ELECTRICAL SITE LIGHTING PLAN

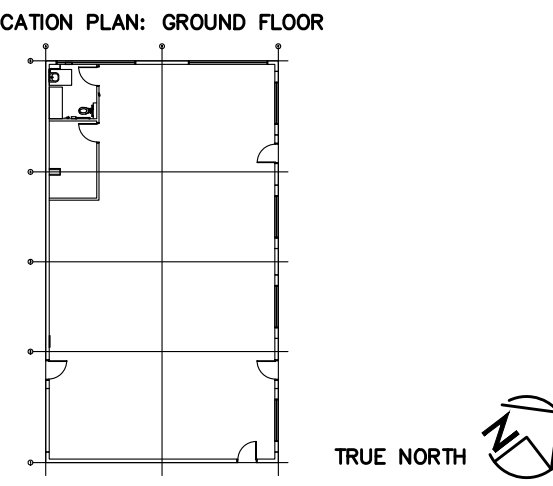

CONTRACTOR SHALL CHECK AND VERIFY ALL DIMENSIONS AND REPORT ANY OMISSIONS OR DISCREPANCIES TO THE ARCHITECT BEFORE PROCEEDING WITH THE WORK.  
DO NOT SCALE DRAWINGS.

REVISIONS		
NO.	DESCRIPTION	DATE
1	Issued for Class D estimate	Feb 22, 2021
2	Issued for Permit	Feb 28, 2022

PROJECT NORTH	DATE
	•
	DRAWN
	AK
	CHECKED
	DATE PRINTED
	-

NOT TO BE USED FOR CONSTRUCTION PURPOSES UNTIL SIGNED BY THE ARCHITECT.

**DYMECH WAREHOUSE ADDITION**


ADDRESS: 1383 OGDEN STREET, GUELPH, ON, N1P 1A1

DRAWING TITLE

**ELECTRICAL DRAWING LIST, LEGEND, NOTES AND SCHEDULES**




SCALE	DRAWING NO. :
NTS	E-000
PROJECT NO.	
059-20	

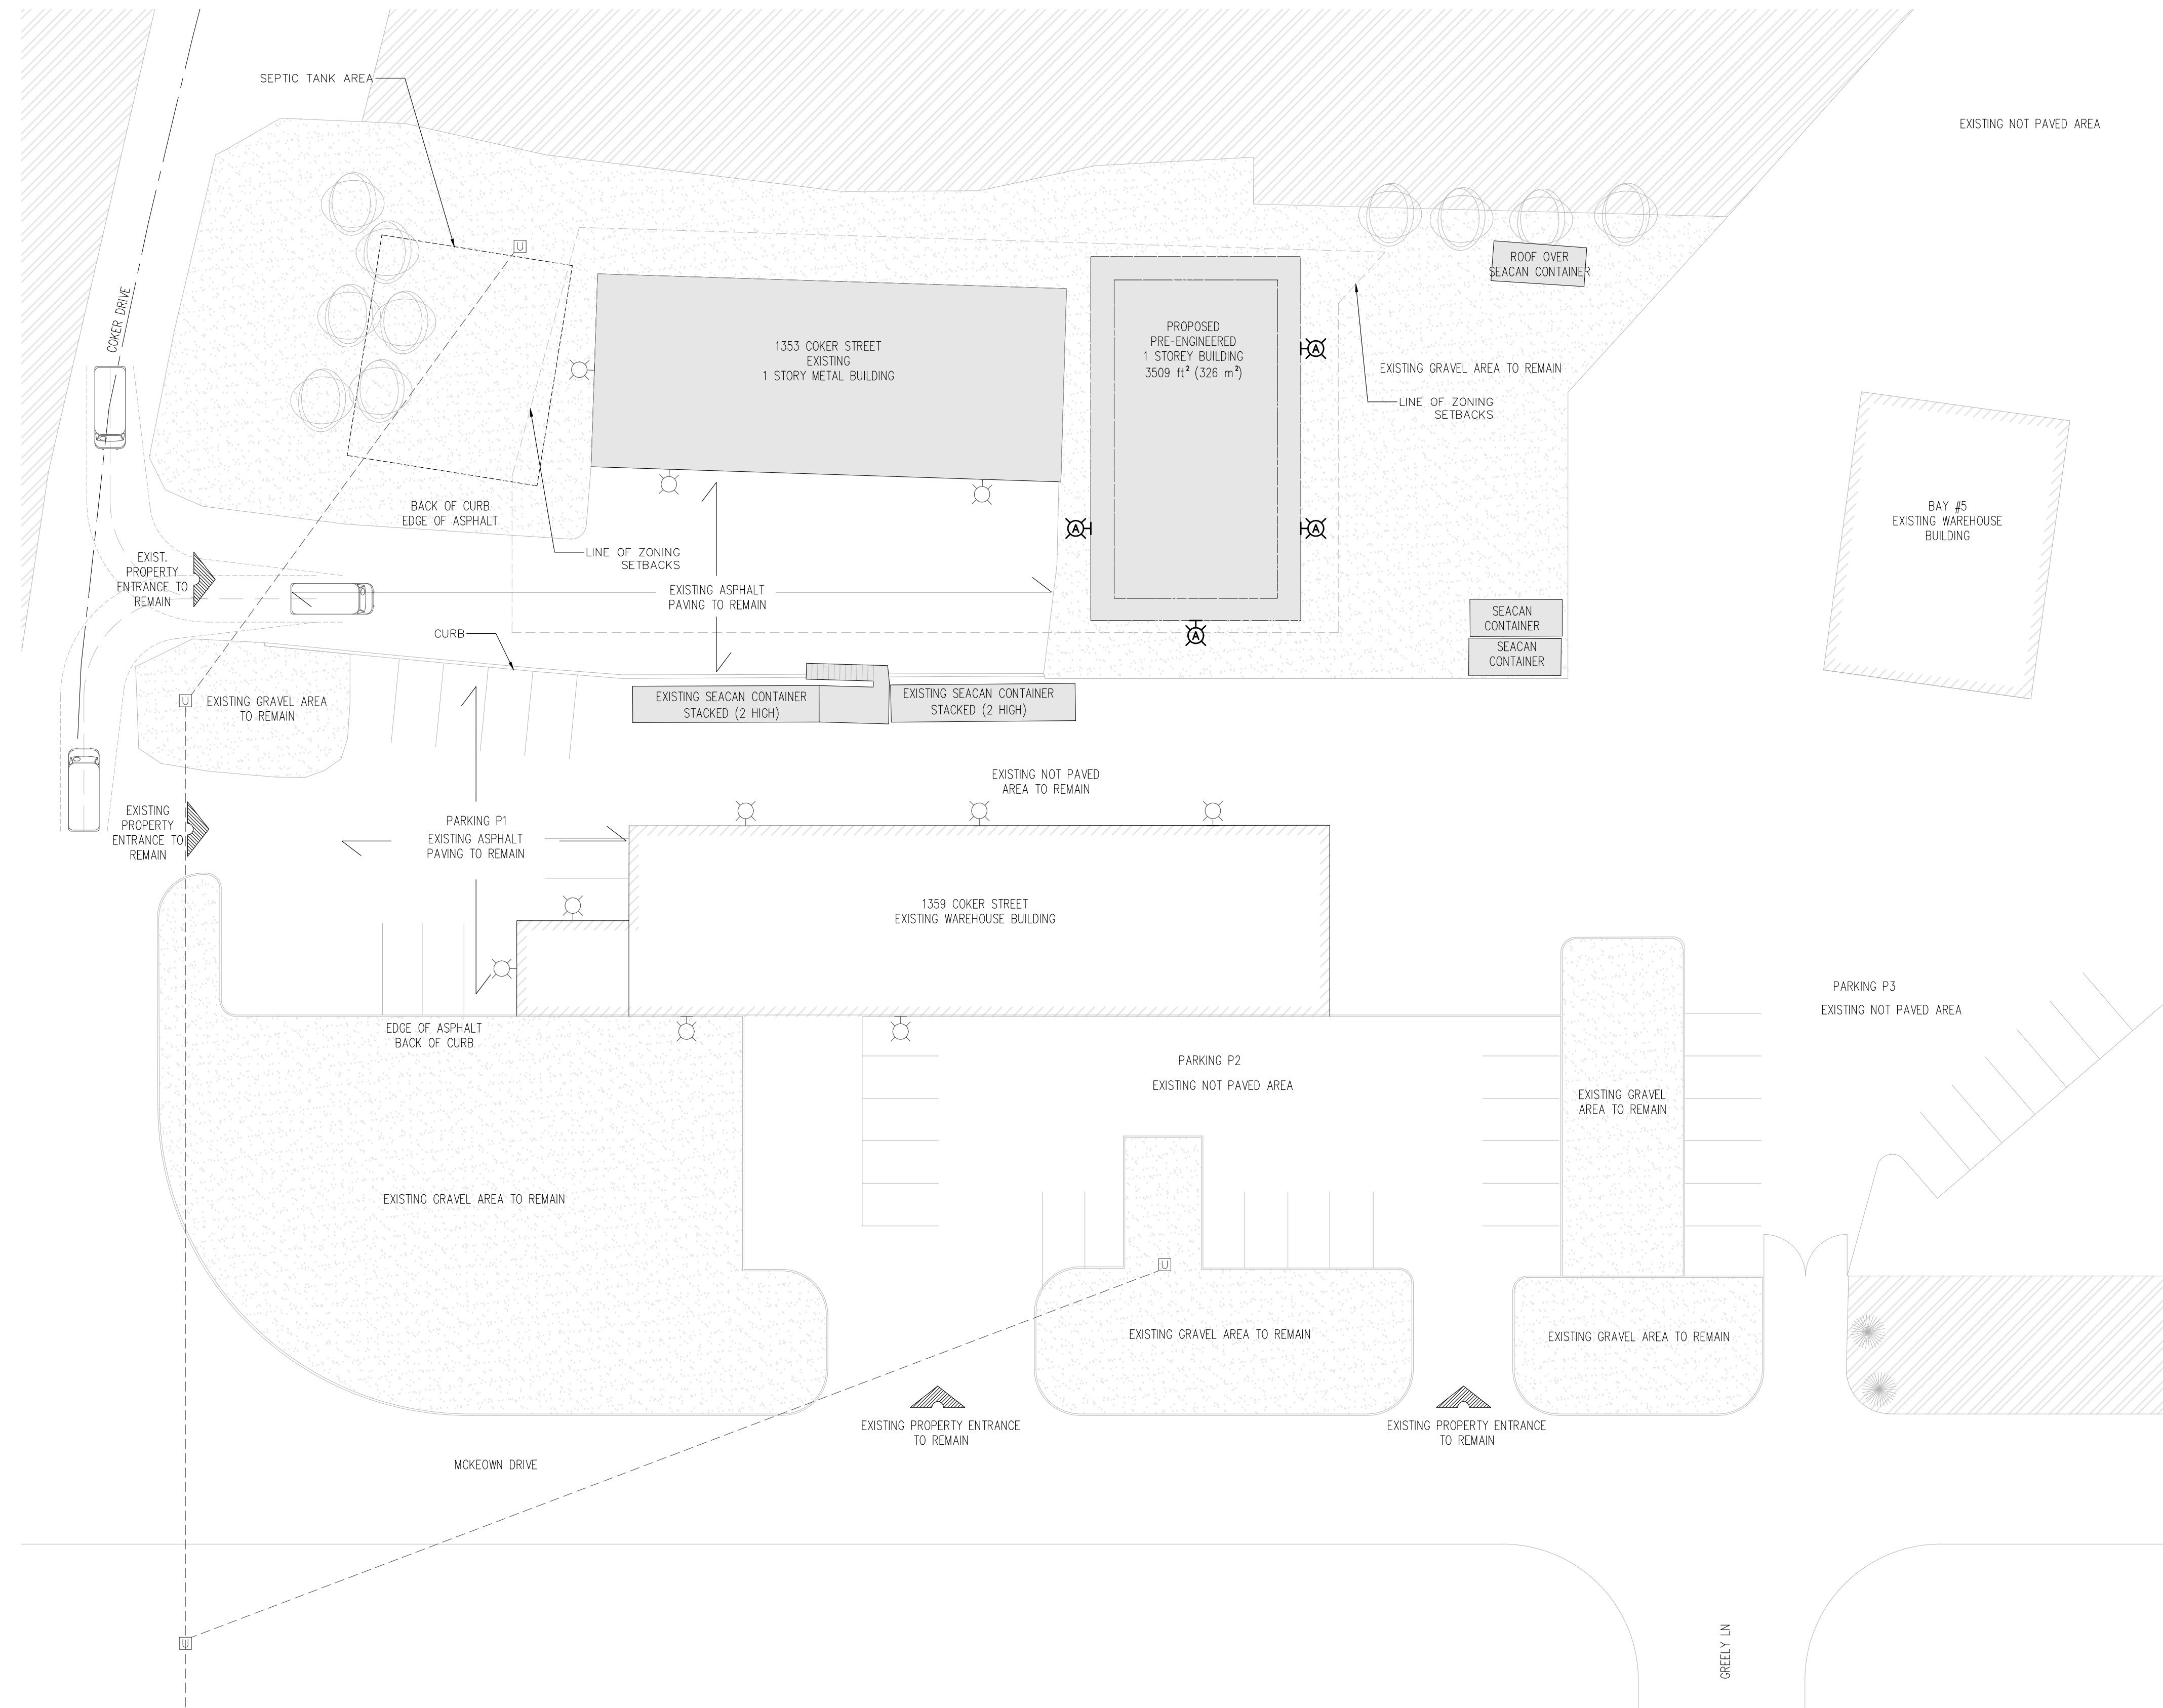

**NEW SITE LIGHTING NOTES**  
 1. PROVIDE NEW SITE LIGHTING AS SHOWN IN BOLD. CONNECT TO EXISTING PANEL. REFER TO ARCHITECTURAL DRAWINGS FOR EXACT LOCATIONS AND MOUNTING HEIGHTS.

**1** ELECTRICAL SITE PLAN  
 E004 1:250

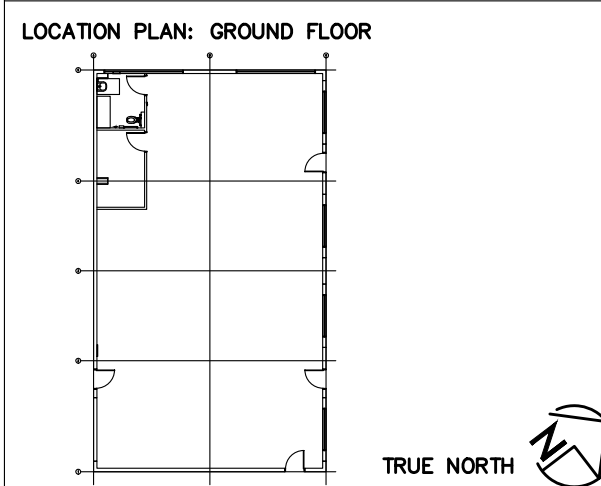

CONTRACTOR SHALL CHECK AND VERIFY ALL DIMENSIONS AND REPORT ANY OMISSIONS OR DISCREPANCIES TO THE ARCHITECT BEFORE PROCEEDING WITH THE WORK.  
 DO NOT SCALE DRAWINGS.

REVISIONS		
NO.	DESCRIPTION	DATE
1	Issued for Class D estimate	Feb 22, 2021
2	Issued for Permit	Feb 28, 2022

PROJECT NORTH	DATE
DRAWN	CHECKED
AK	
DATE PRINTED	

NOT TO BE USED FOR CONSTRUCTION PURPOSES UNTIL SIGNED BY THE ARCHITECT.

**DYMECH WAREHOUSE ADDITION**

ADDRESS: 1303 COKER STREET, GREELEY, ON, N4P 1A1

DRAWING TITLE  
**ELECTRICAL SITE LIGHTING PLAN**

SCALE	DRAWING NO. 1
<b>AS SHOWN</b>	
PROJECT NO.	<b>E-001</b>
<b>059-20</b>	

