



1 LOWER LEVEL FLOOR PLAN
SCALE: 1:125

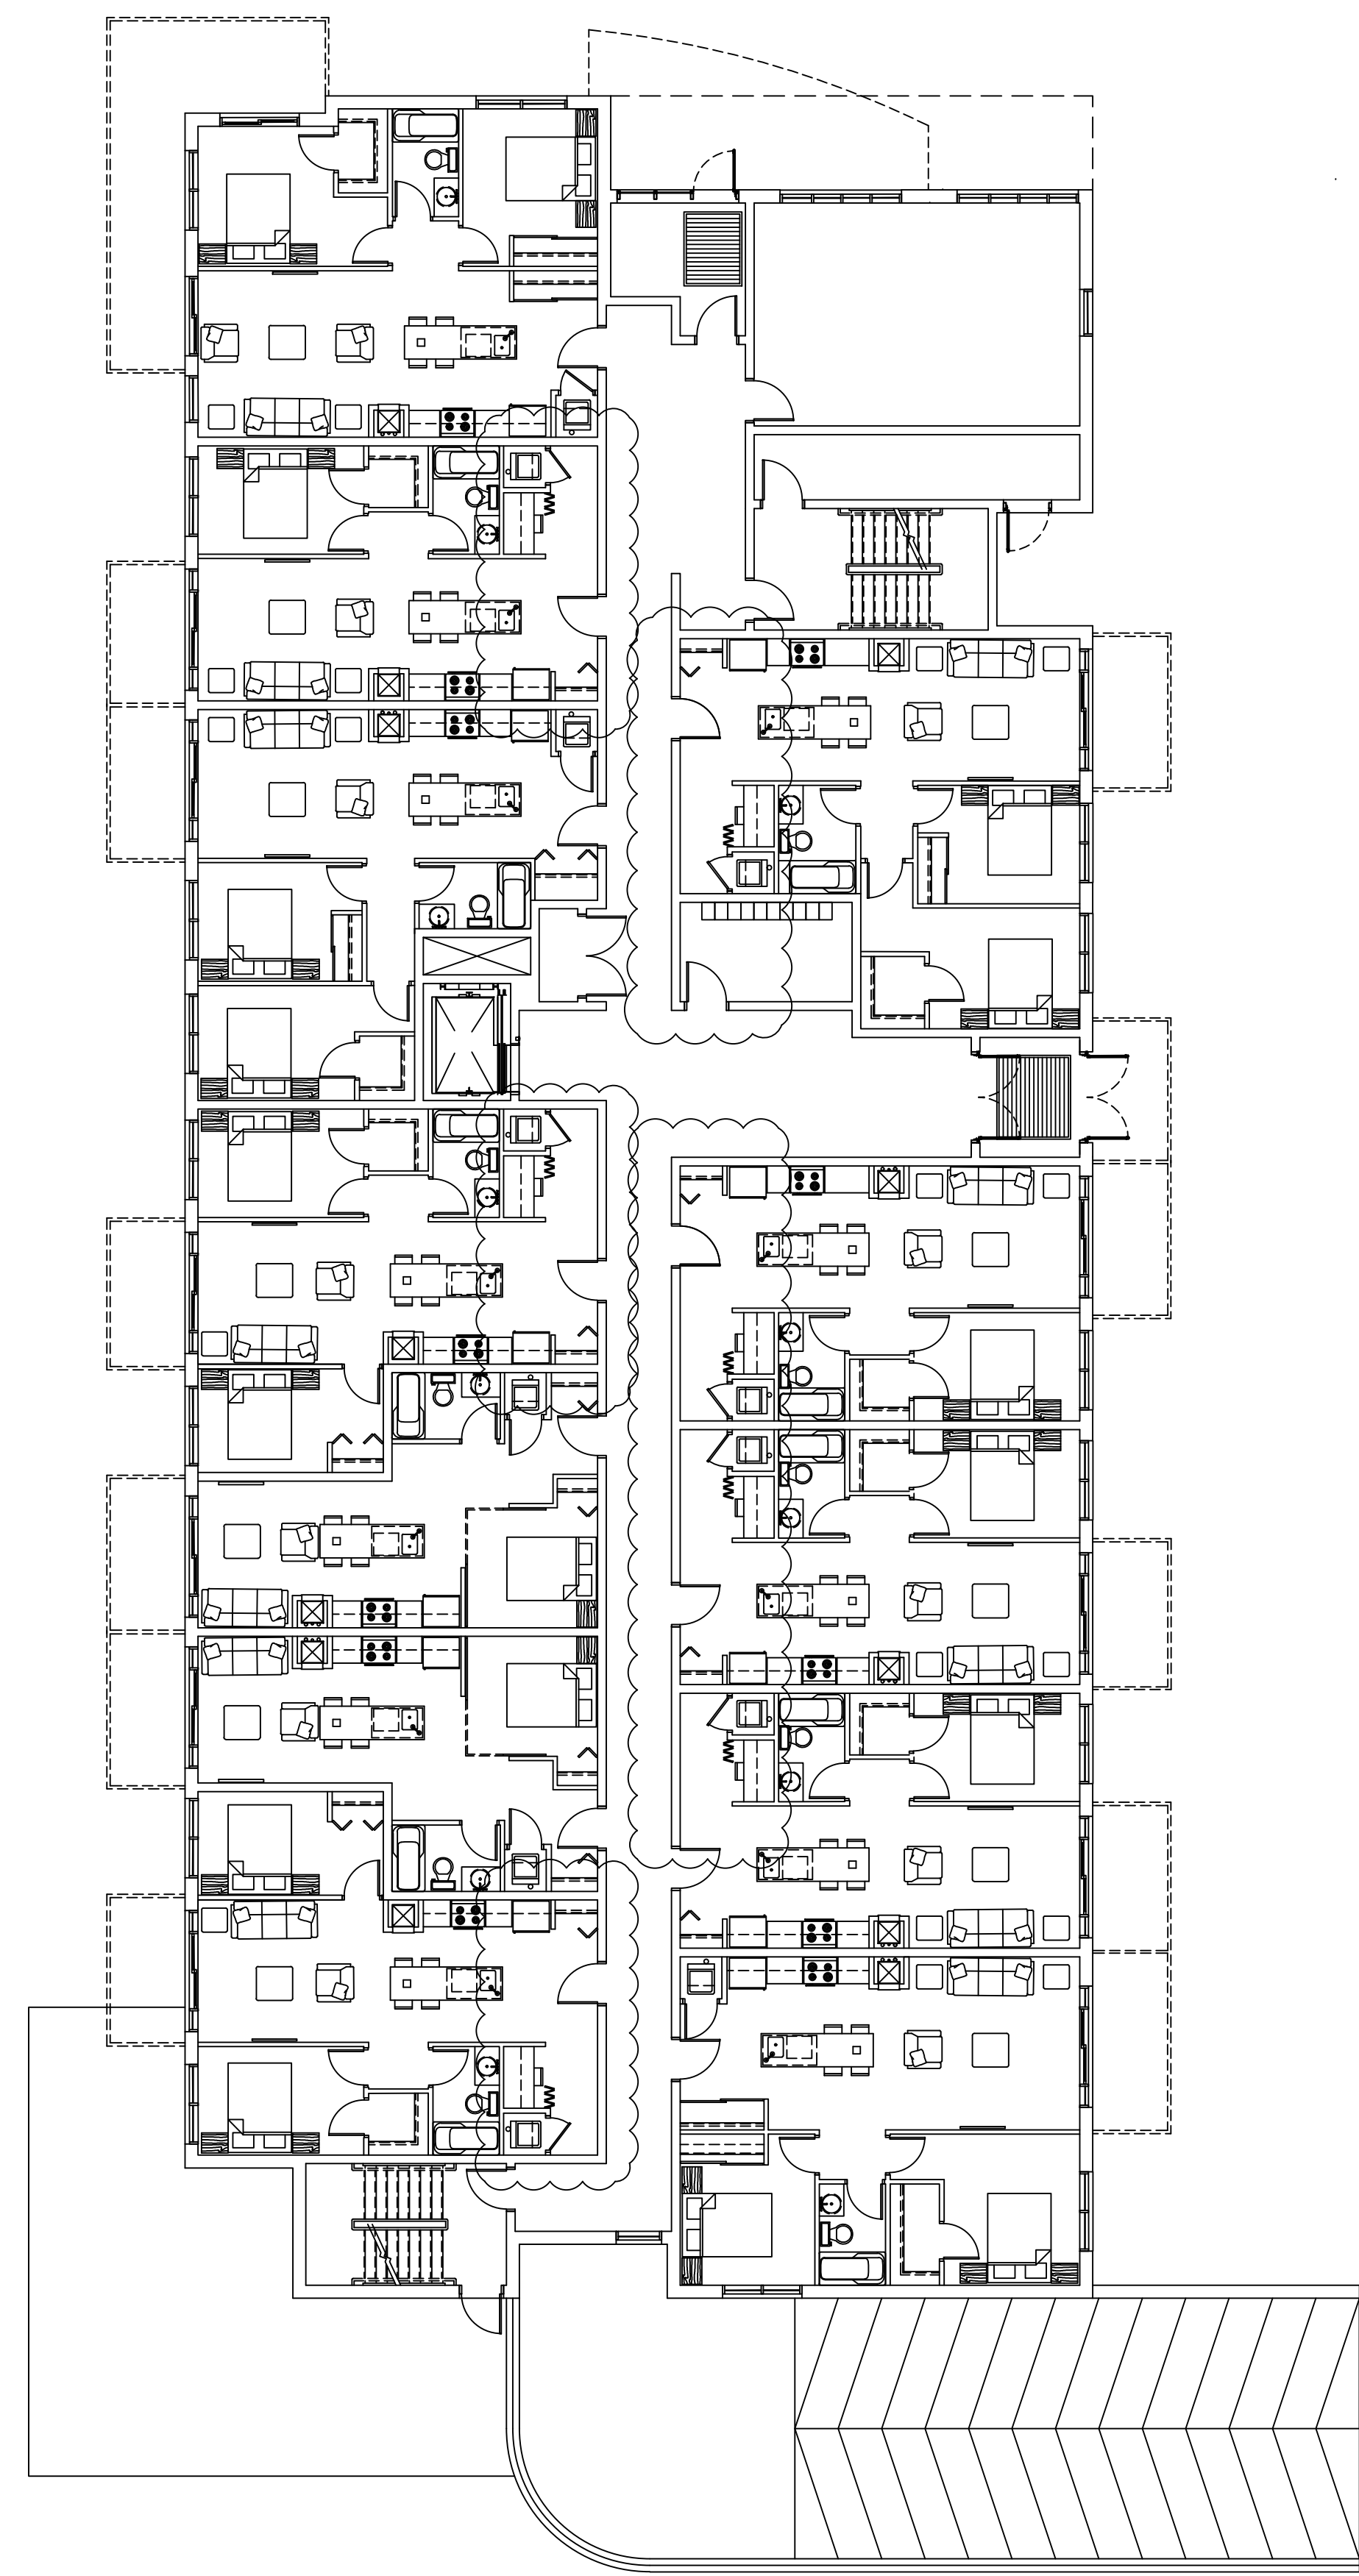

2 MAIN LEVEL FLOOR PLAN
SCALE: 1:125

BLOCK A			
UNIT TYPE	MICRO SUITE	1B	2B
LEVEL 1	2	4	6
LEVEL 2	2	7	5
LEVEL 3	2	7	5
TOTAL	6	18	16
	15%	45%	40%

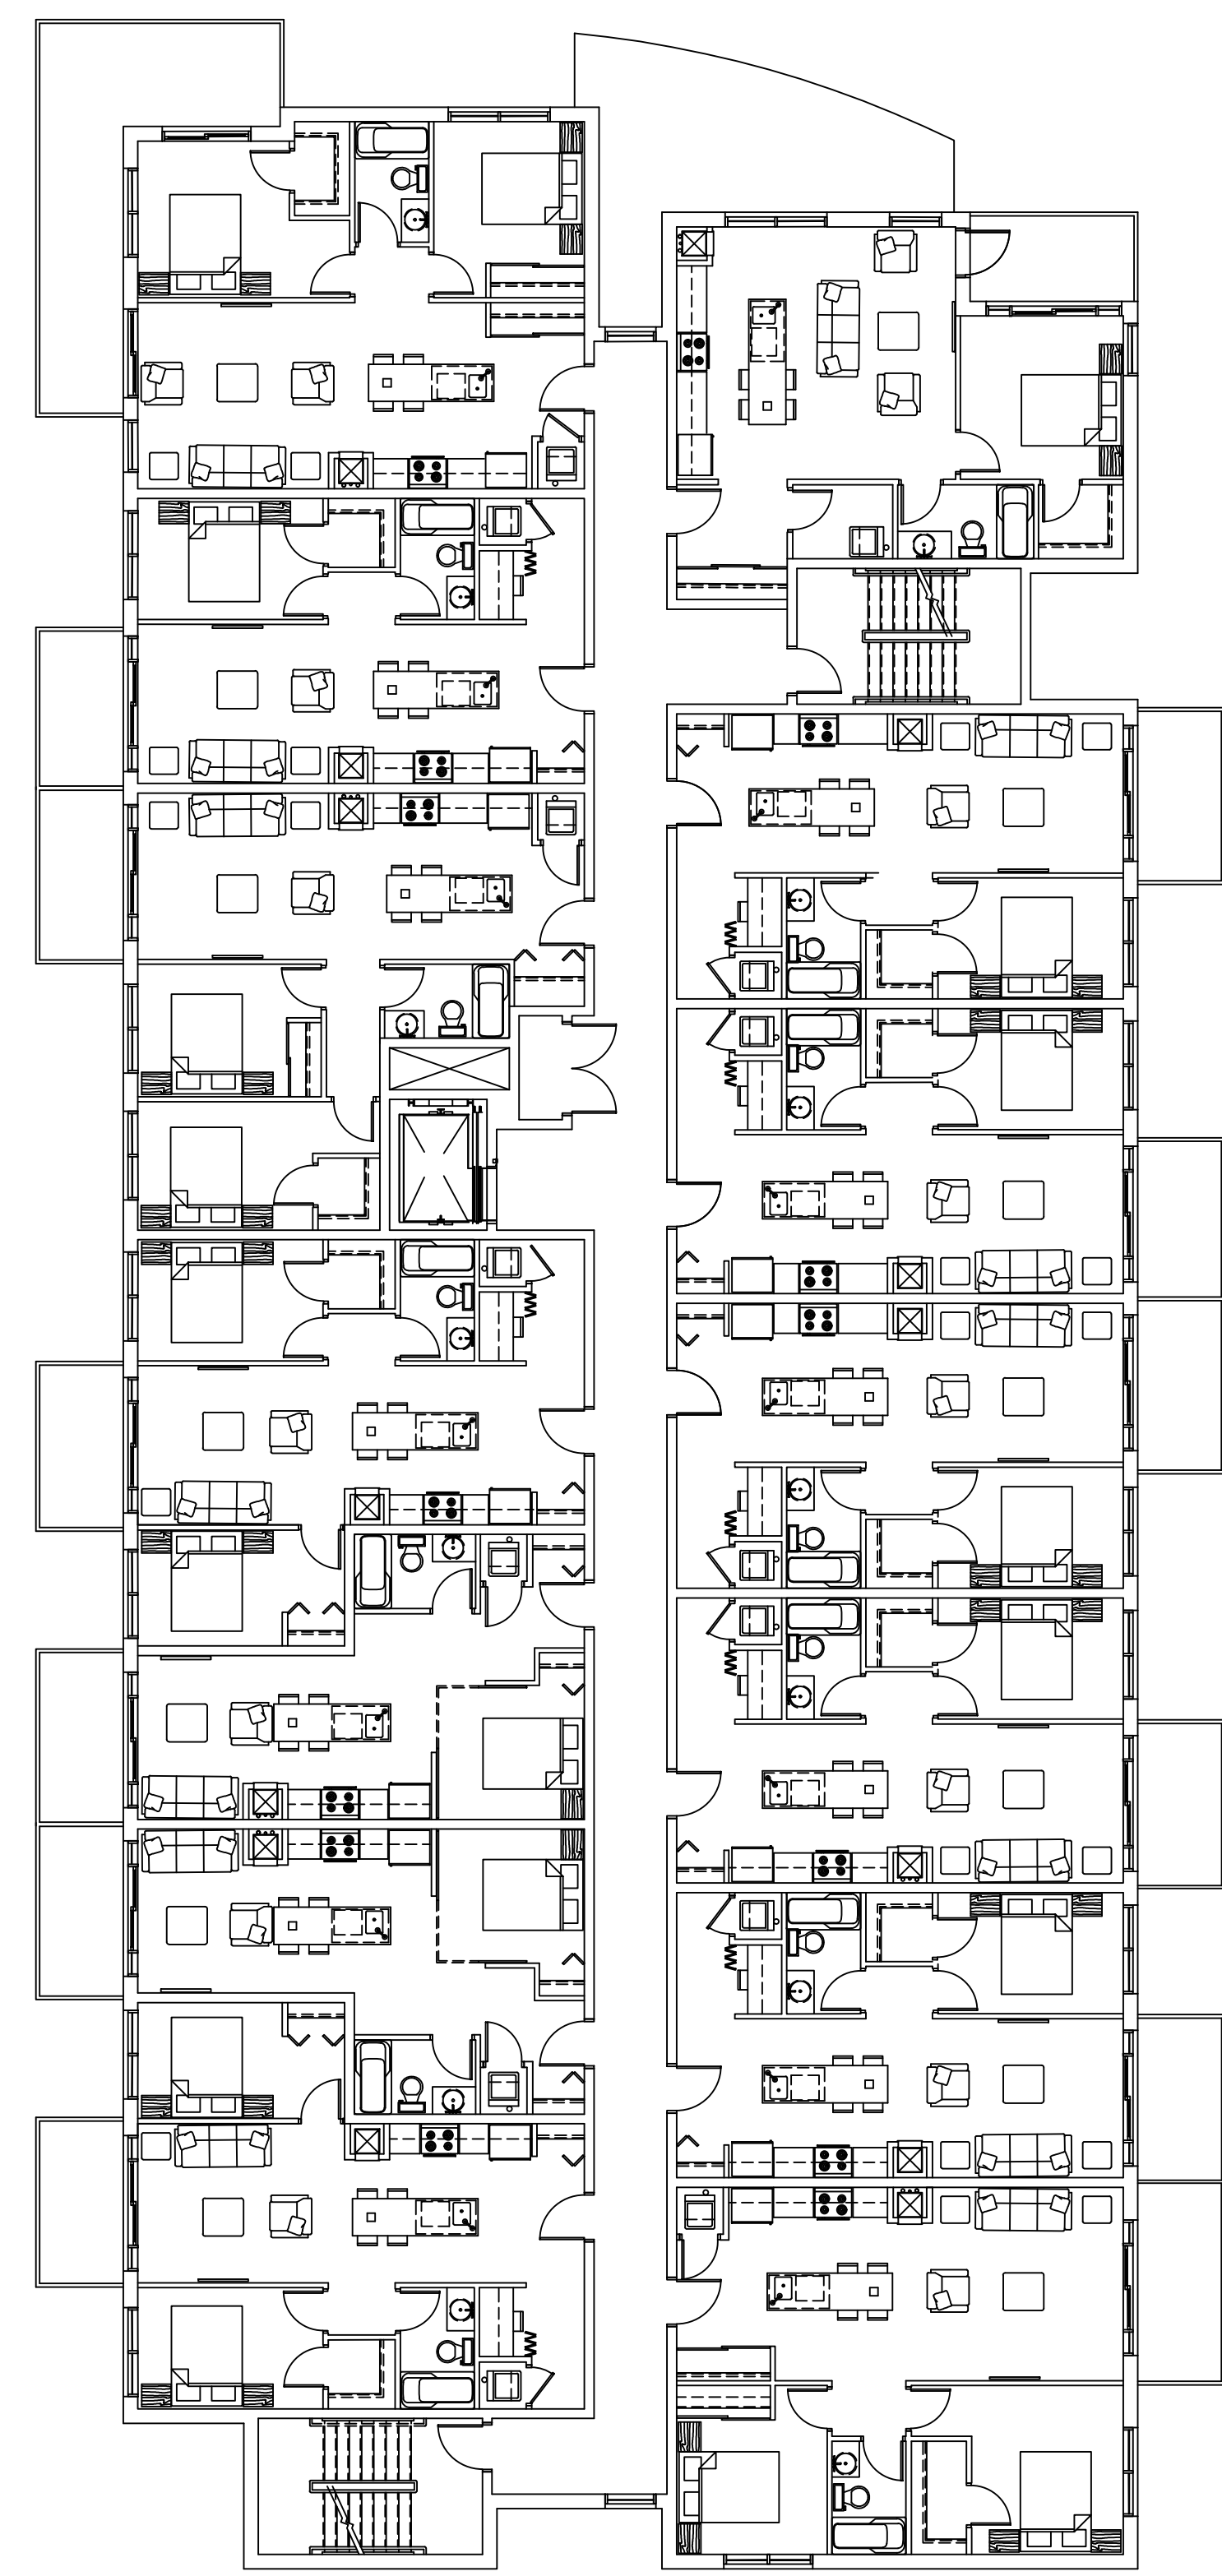

3 TYPICAL LEVEL FLOOR PLAN
SCALE: 1:125

No.	REVISIONS	BY	DATE
13			
12			
11			
10			
09			
08			
07			
06			
05	FOR REVIEW	PE	MAR. 18 2022
04	FOR REVIEW	PE	DEC. 22 2021
03	FOR REVIEW	PE	APR. 09 2021
02	FOR REVIEW	PE	FEB. 10 2021
01	FOR REVIEW	PE	DEC. 15 2020

NOT AUTHENTIC UNLESS SIGNED AND DATED
D2
concepts
 235 BROADWOOD AVE. SUITE 201
 OTTAWA, ONTARIO, K1V 6J8
 CONSULTING ENGINEERS
 STRUCTURAL
 MECHANICAL
 ELECTRICAL

DESIGNED BY: P.E.
 DRAWN BY: P.E.
 APPROVED BY: P.E.

PROJECT
**2380 and 2396
 CLEROUX CRESCENT
 OTTAWA**

DRAWING TITLE
**BLOCK A
 FLOOR PLANS**

PROJECT NO.
0403
 DATE
DEC. 11, 2020

A100