


BLOCK B				
UNIT TYPE	MICRO SUITE	1B	2B	TOTAL
LEVEL 1	1	6	5	12
LEVEL 2	2	7	5	14
LEVEL 3	2	7	5	14
TOTAL	5	20	15	40
	13%	50%	37%	

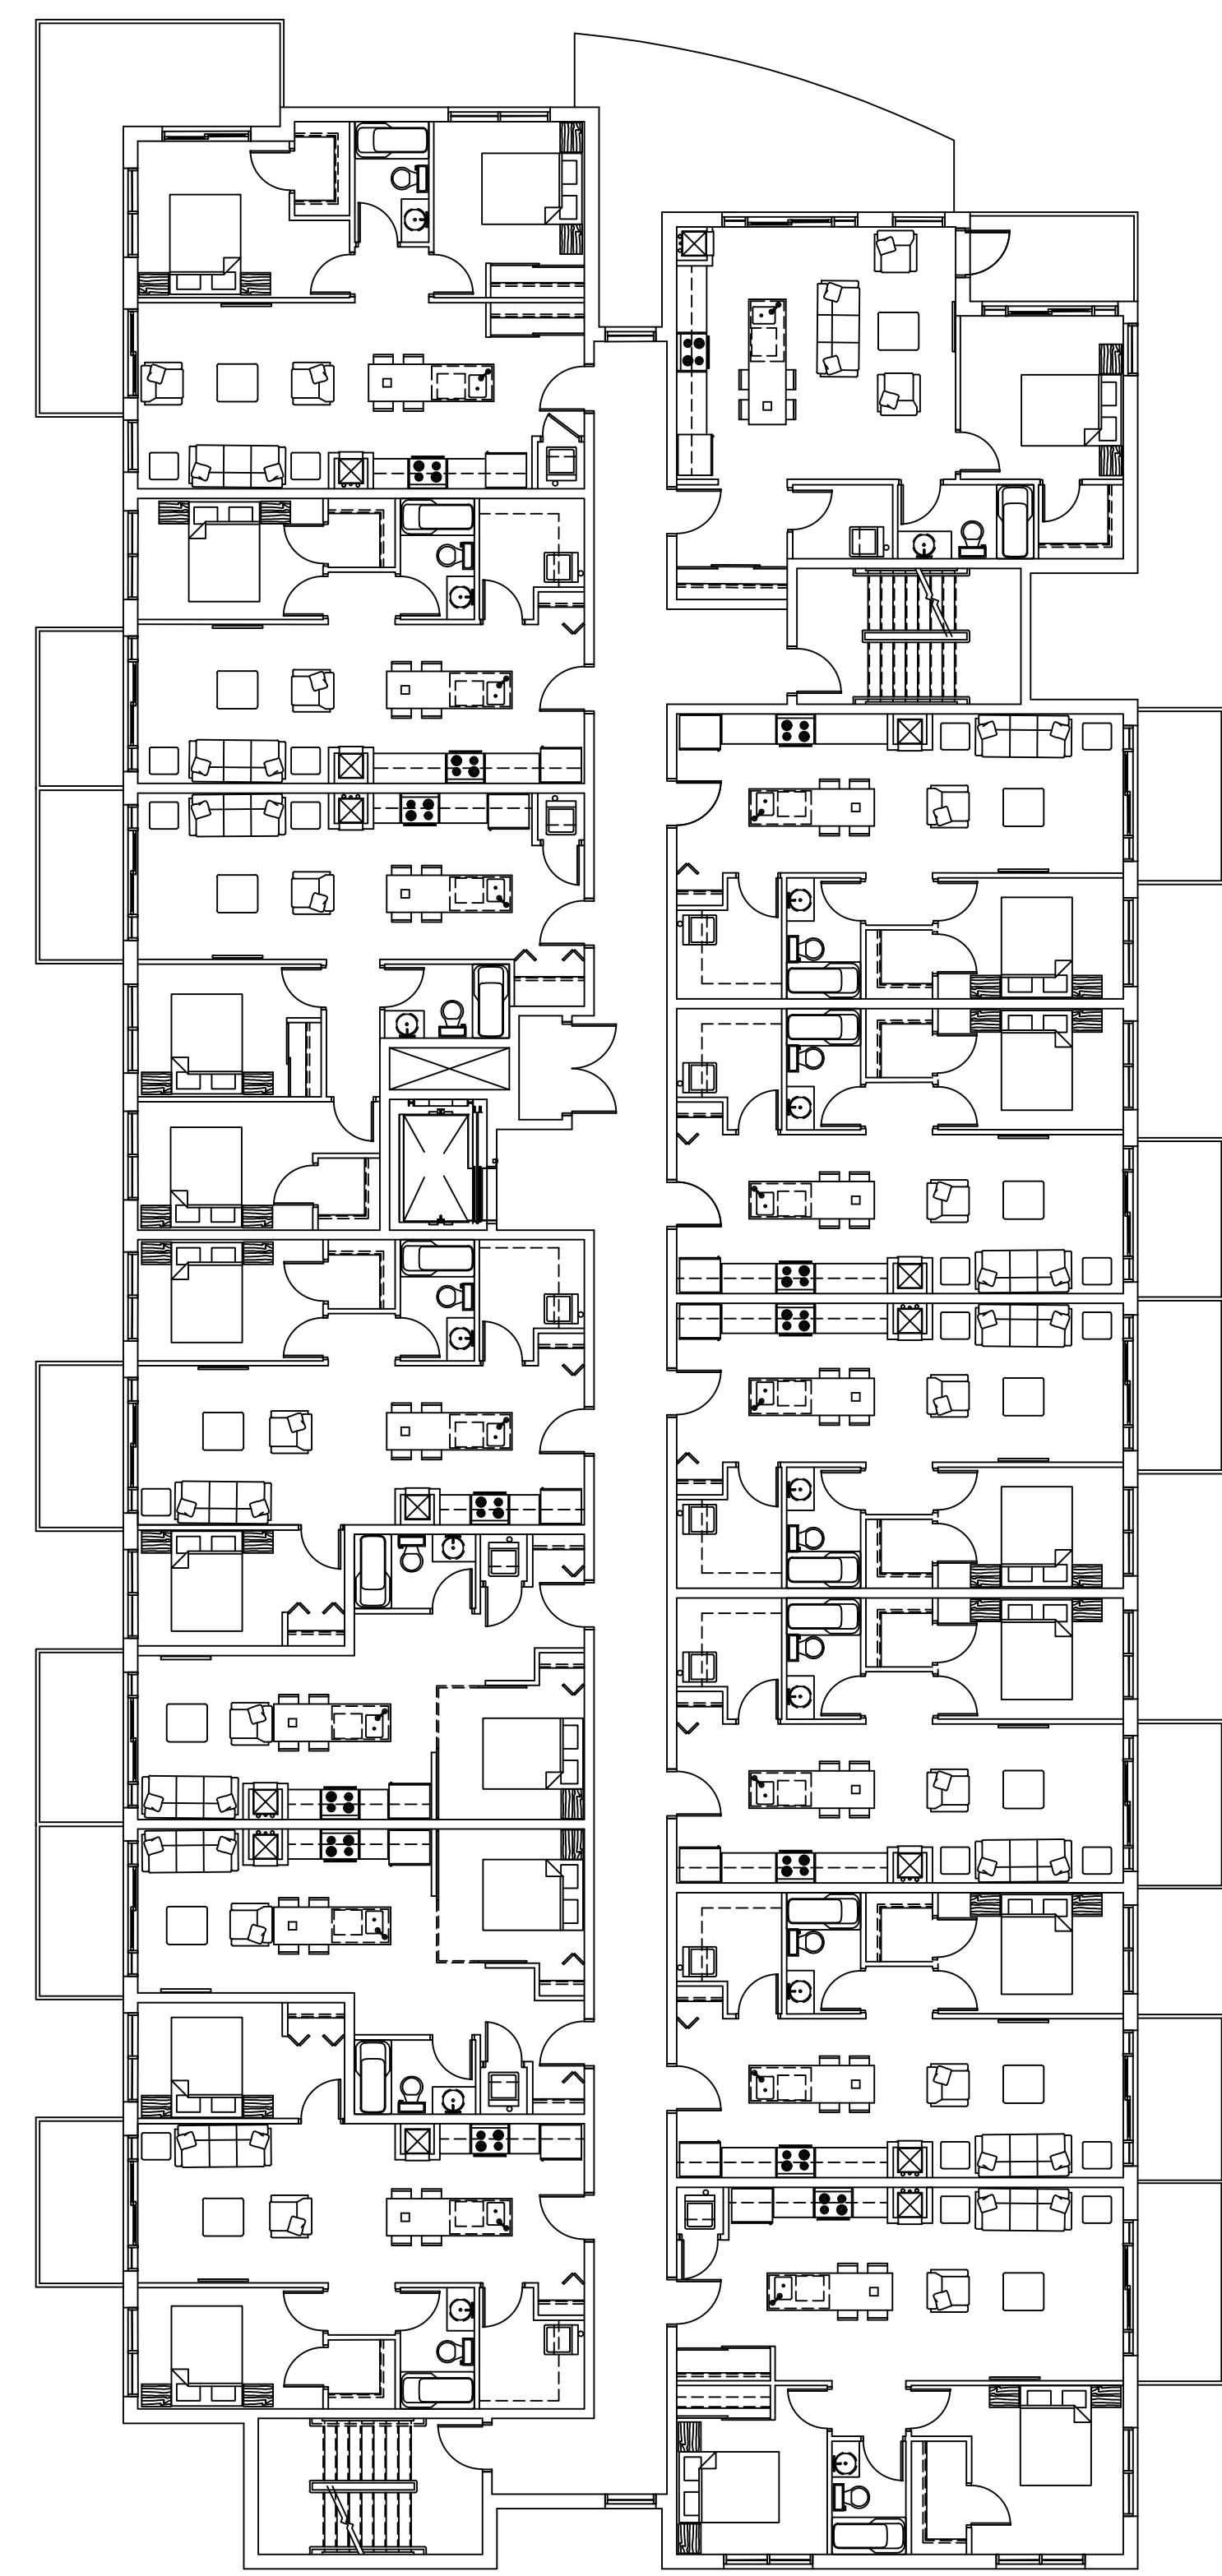

No.	REVISIONS	BY	DATE
13			
12			
11			
10			
09			
08			
07			
06			
05	FOR REVIEW	PE	MAR. 18 2022
04	FOR REVIEW	PE	DEC. 22 2021
03	FOR REVIEW	PE	APR. 09 2021
02	FOR REVIEW	PE	FEB. 10 2021
01	FOR REVIEW	PE	DEC. 15 2020

NOT AUTHENTIC UNLESS SIGNED AND DATED

D2
concepts
235 BROADWOOD AVE. SUITE 201
OTTAWA, ONTARIO, K1V 6J8

CONSULTING ENGINEERS

STRUCTURAL
MECHANICAL
ELECTRICAL

DESIGNED BY: P.E.
DRAWN BY: P.E.
APPROVED BY: P.E.

PROJECT
**2380 and 2396
CLEROUX CRESCENT
OTTAWA**

DRAWING TITLE
**BLOCK B
FLOOR PLANS**

PROJECT NO.
0403
DATE
DEC. 11, 2020

A101

1 LOWER LEVEL FLOOR PLAN
SCALE=1:125
A101

2 MAIN LEVEL FLOOR PLAN
SCALE=1:125
A101

3 TYPICAL LEVEL FLOOR PLAN
SCALE=1:125
A101

D07-12-21-0081