




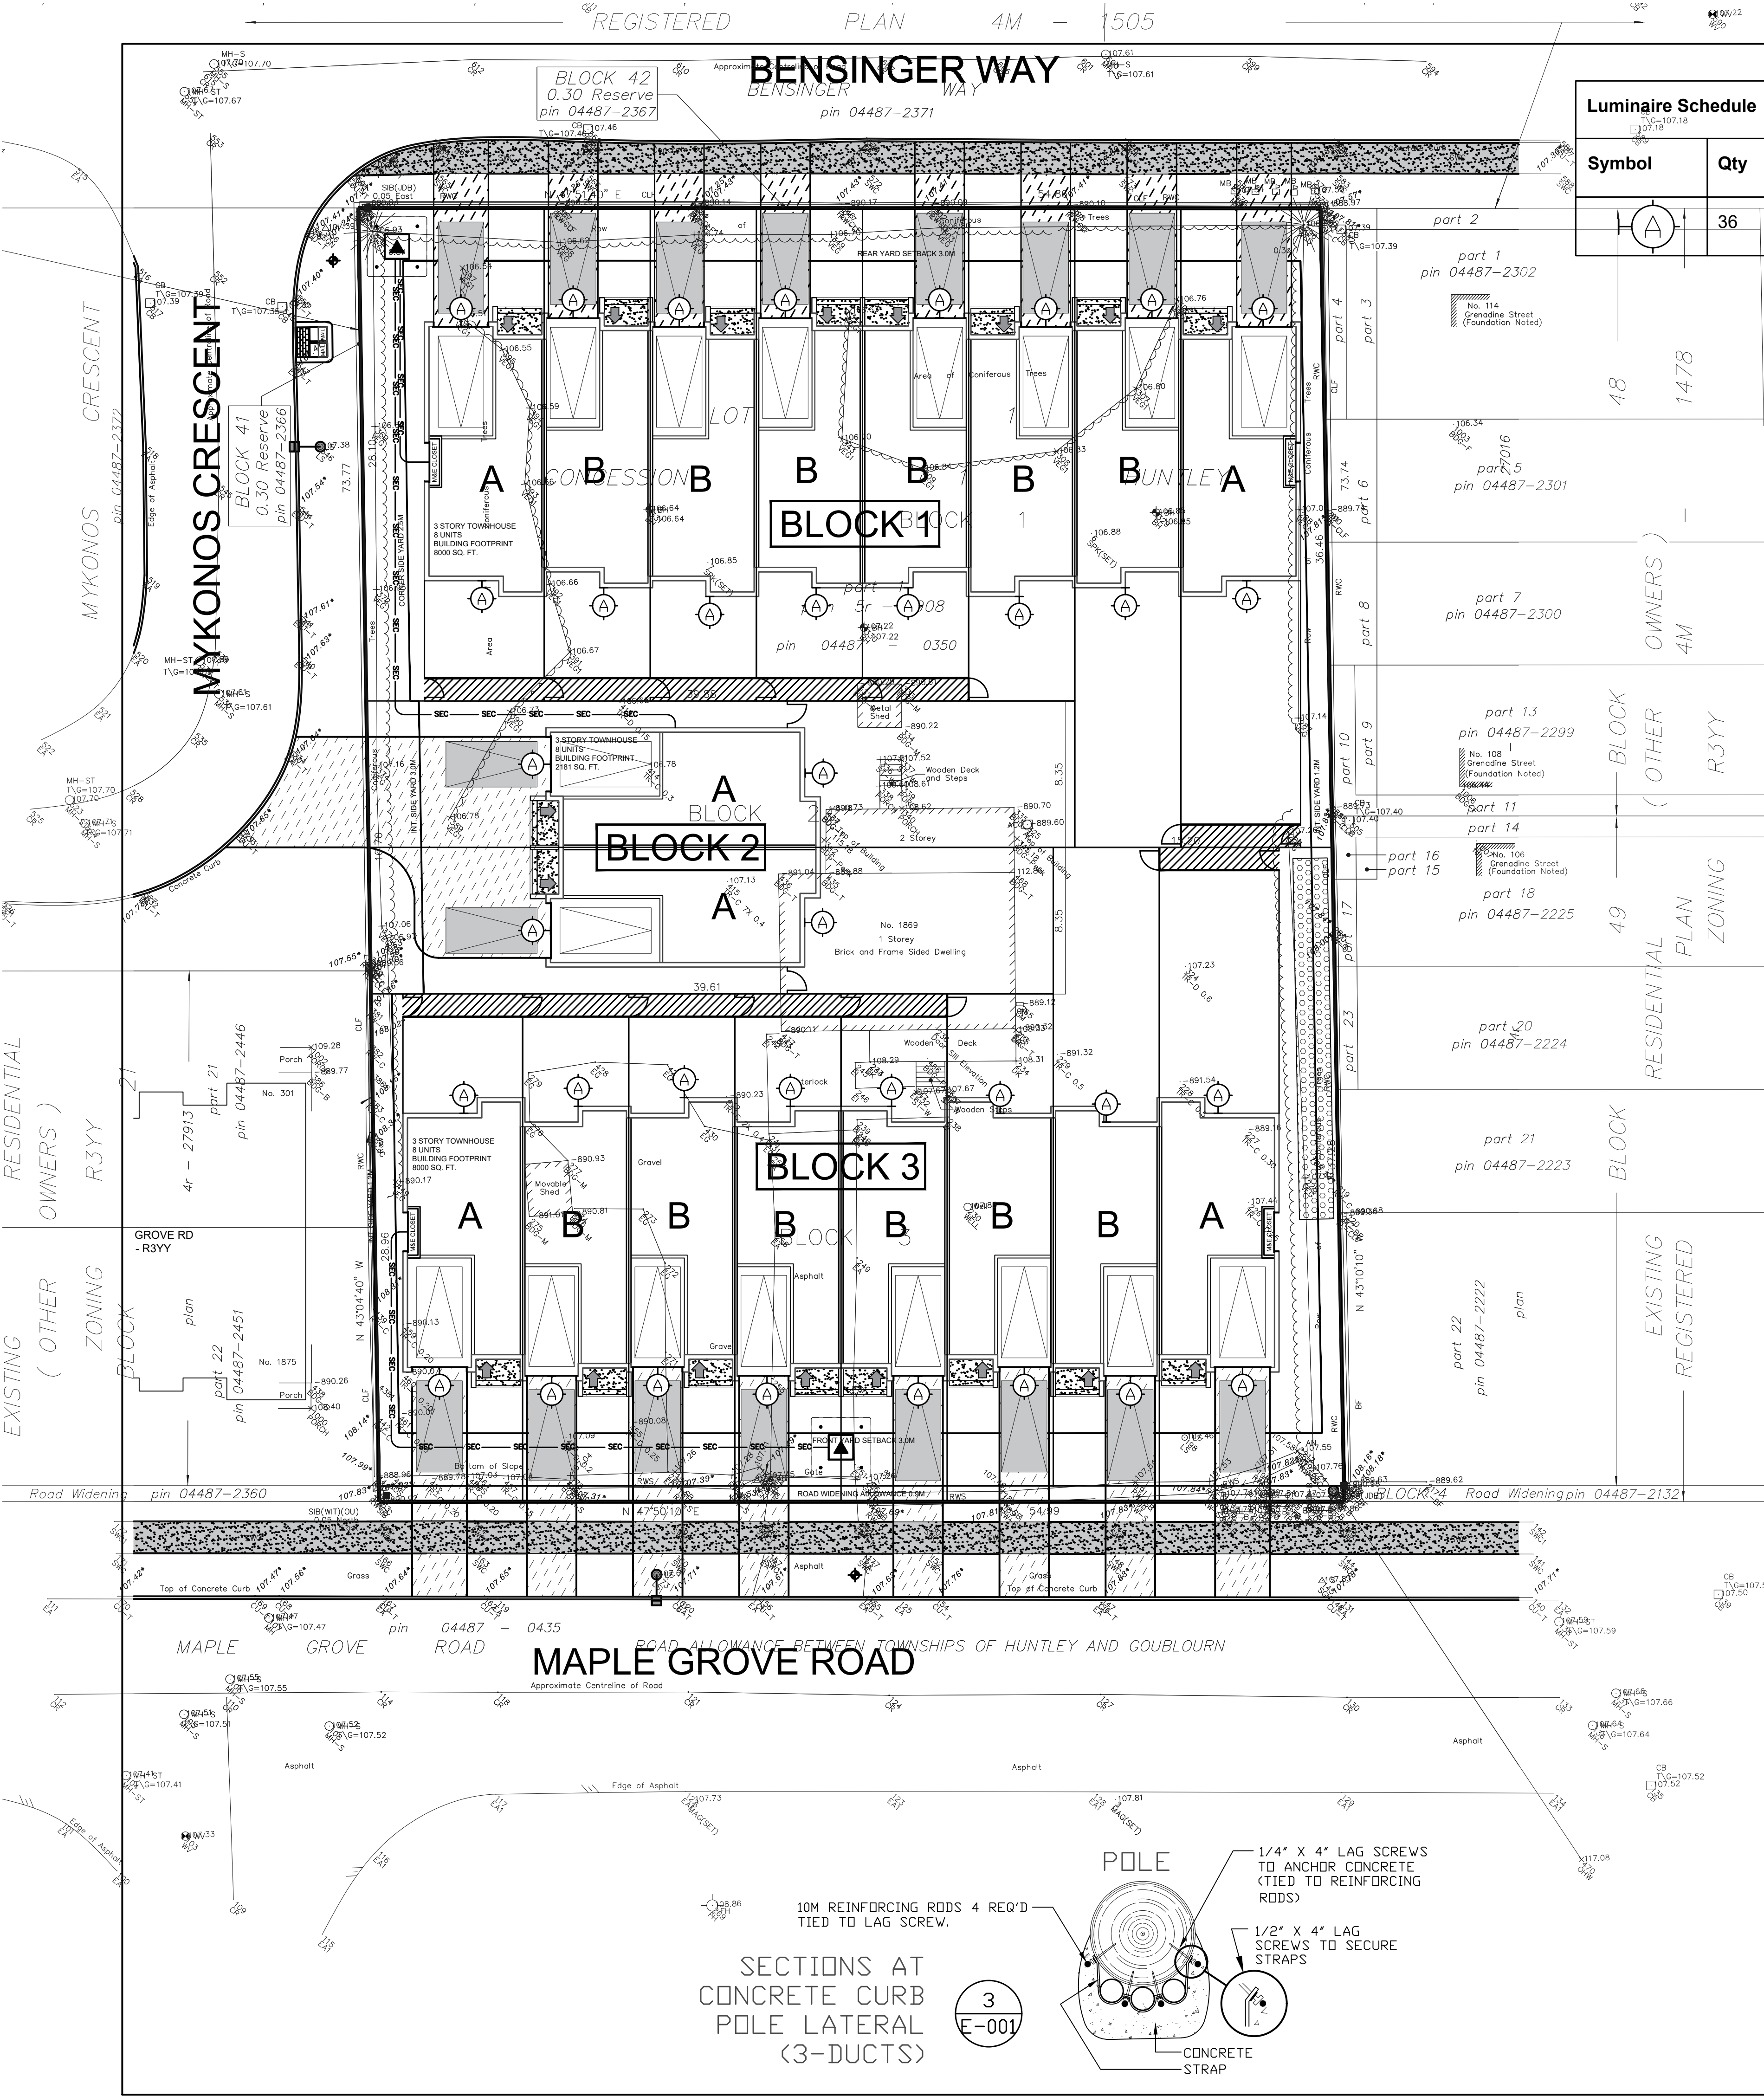


Luminaire Schedule						
Symbol	Qty	Label	Arrangement	Total Lamp Lumens	LLF	Description
	36	EWS	SINGLE	N.A.	0.900	EWLS01D15AF730 -347V

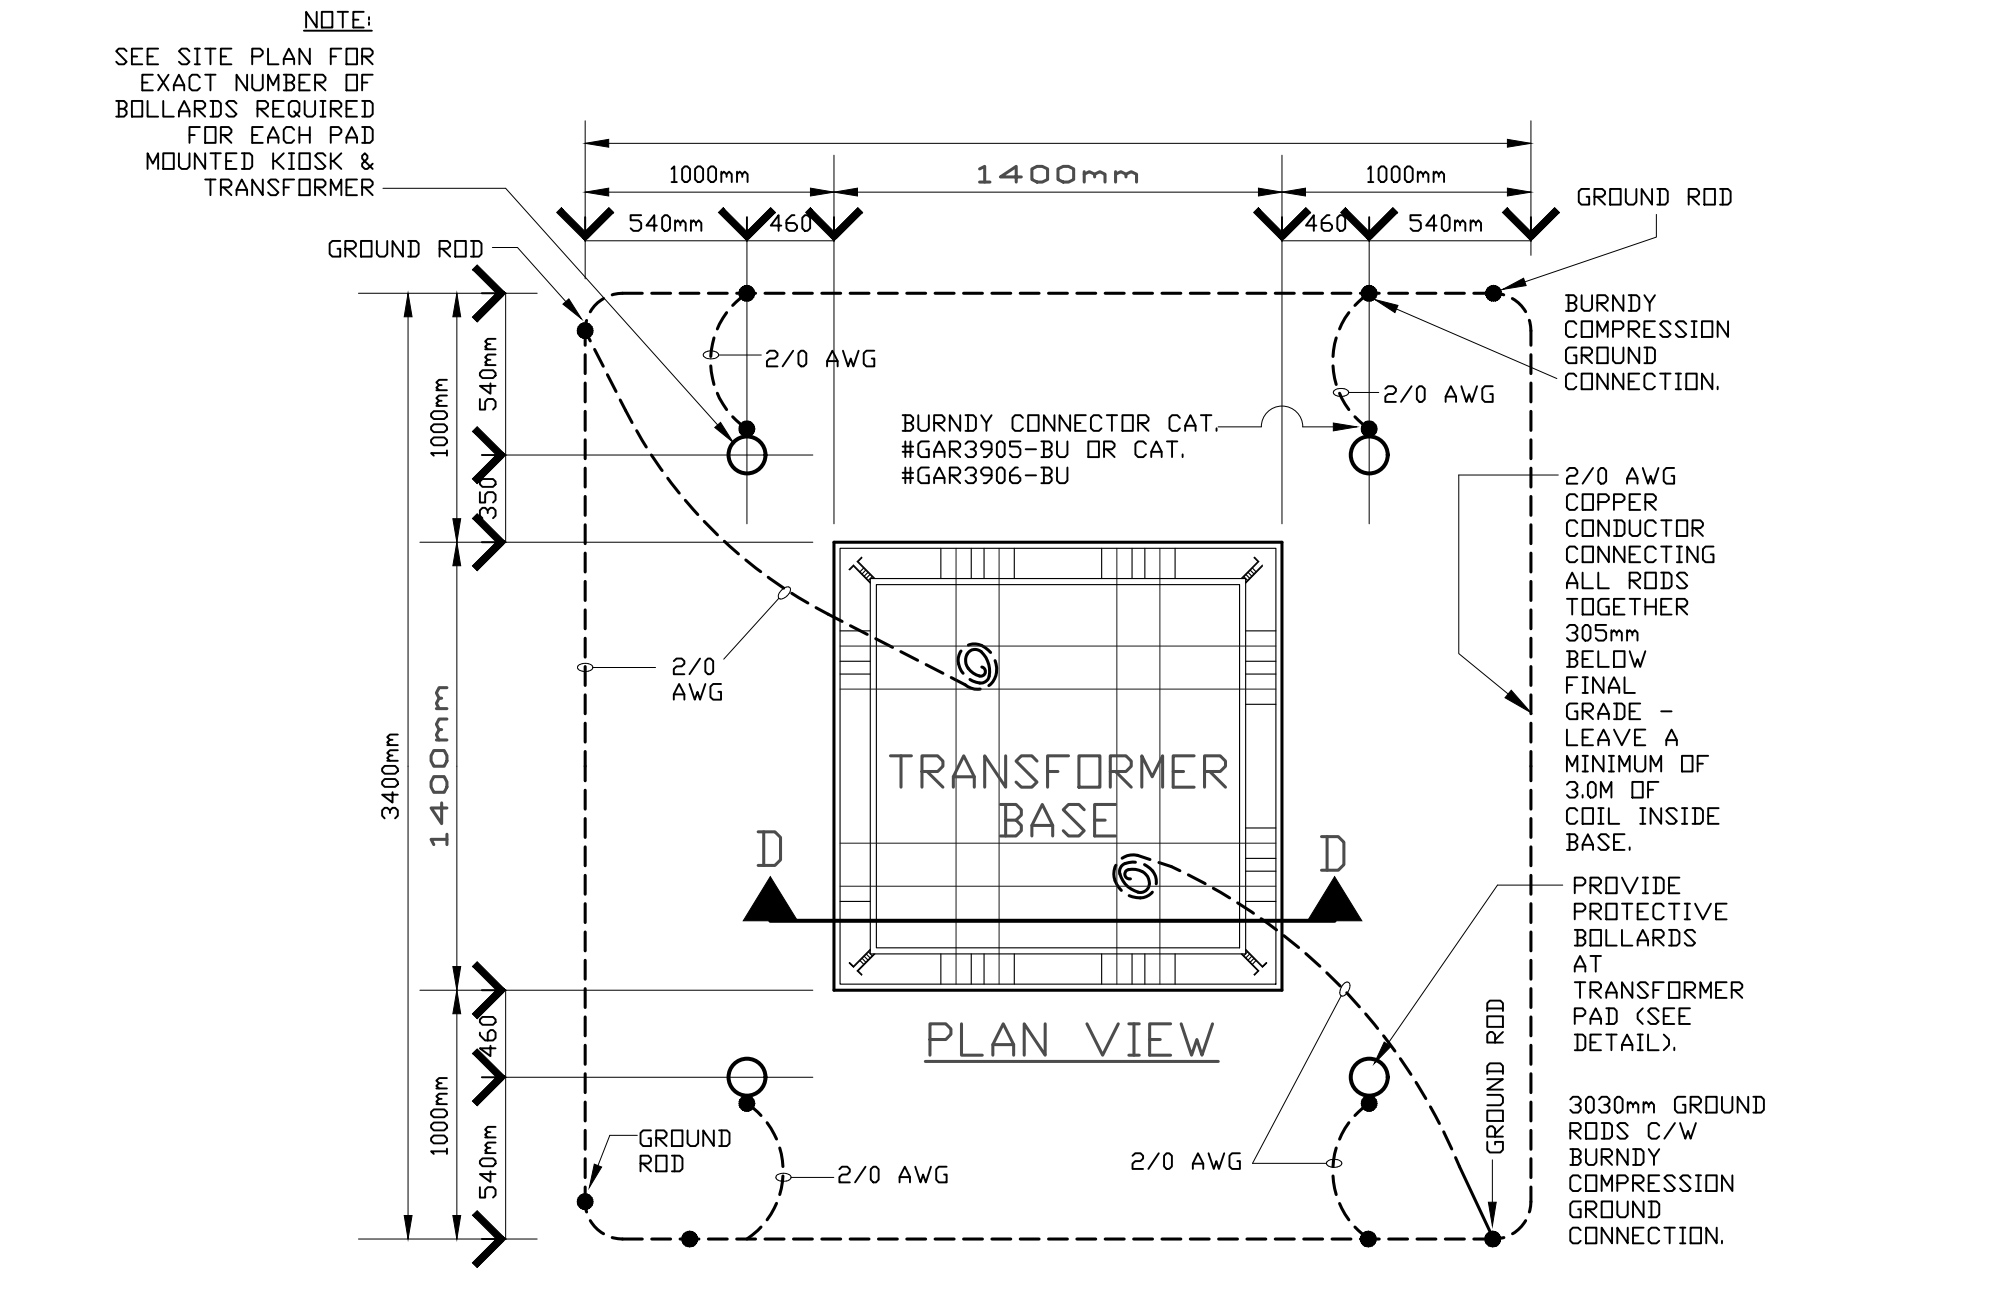


GENERAL NOTES

- 1. BASE TO BE GROUNDED AS PER HYDRO-ONE DETAIL.
- 2. COMPLETE INSTALLATION TO COMPLY WITH HYDRO ONE REQUIREMENTS. COORDINATE ON SITE WITH HYDRO-ONE.

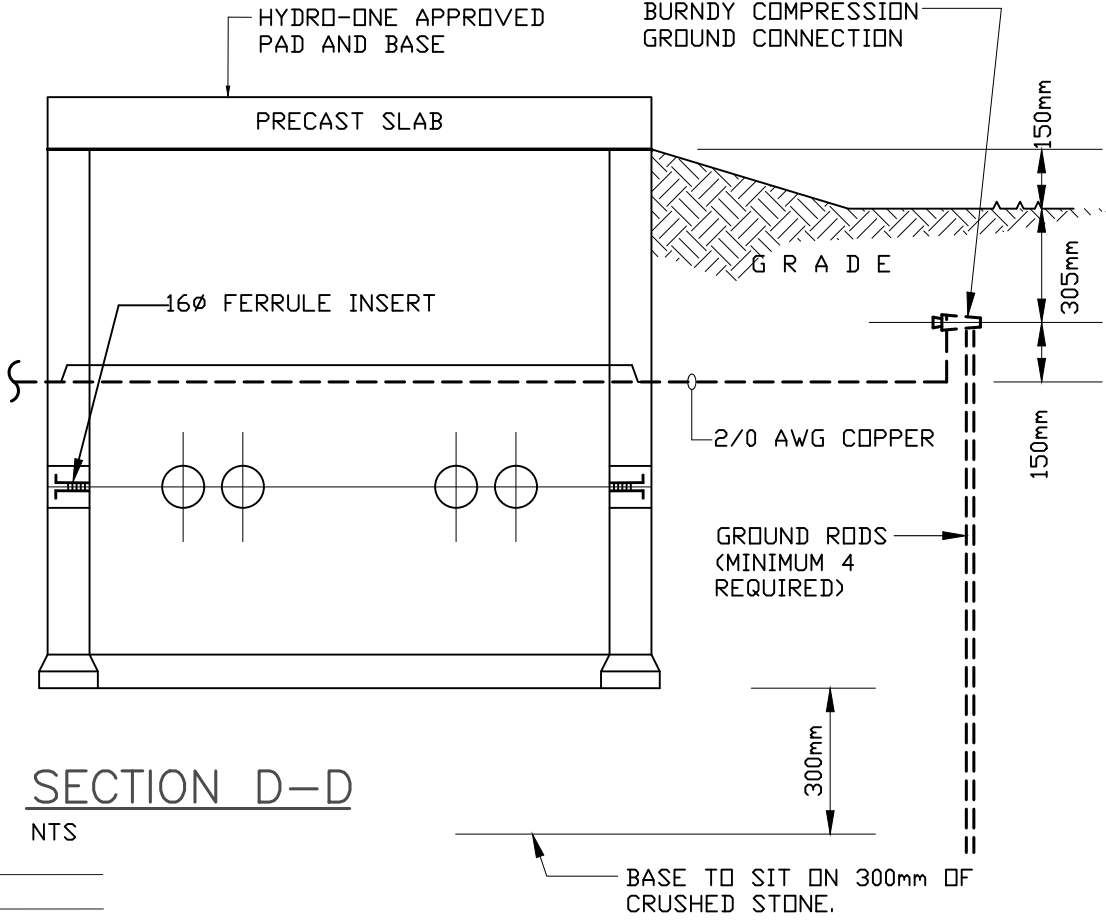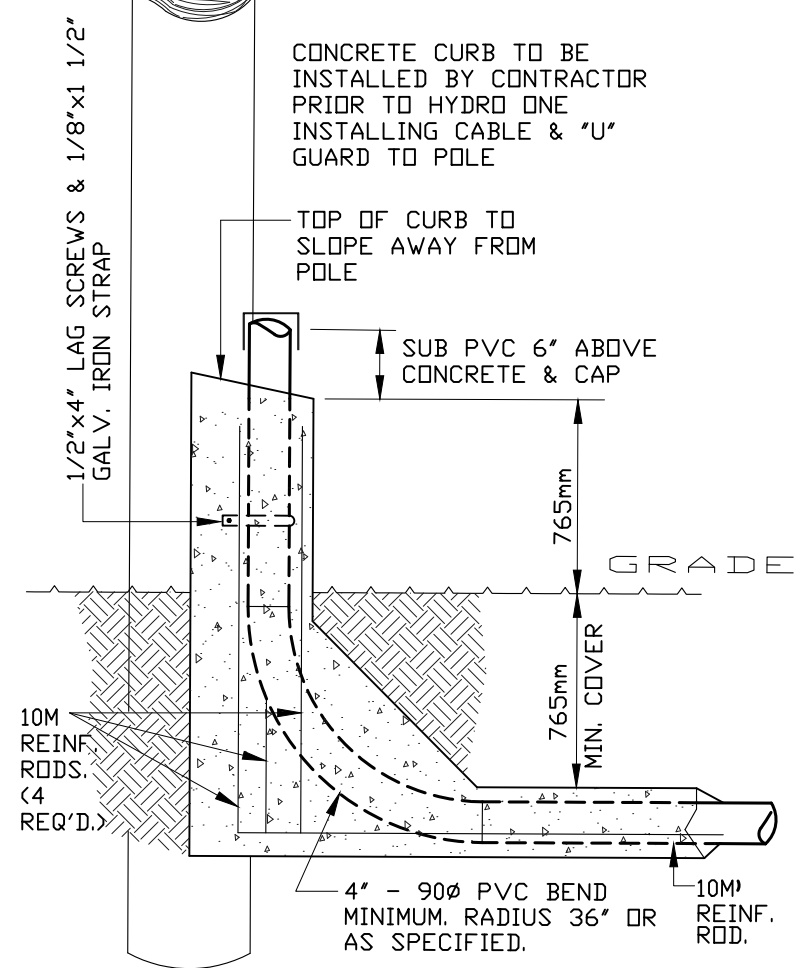

POLE LATERAL (WITH RISER) CONCRETE ENCASED (3-DUCTS)

1-PHASE PAD MOUNTED K I O S K

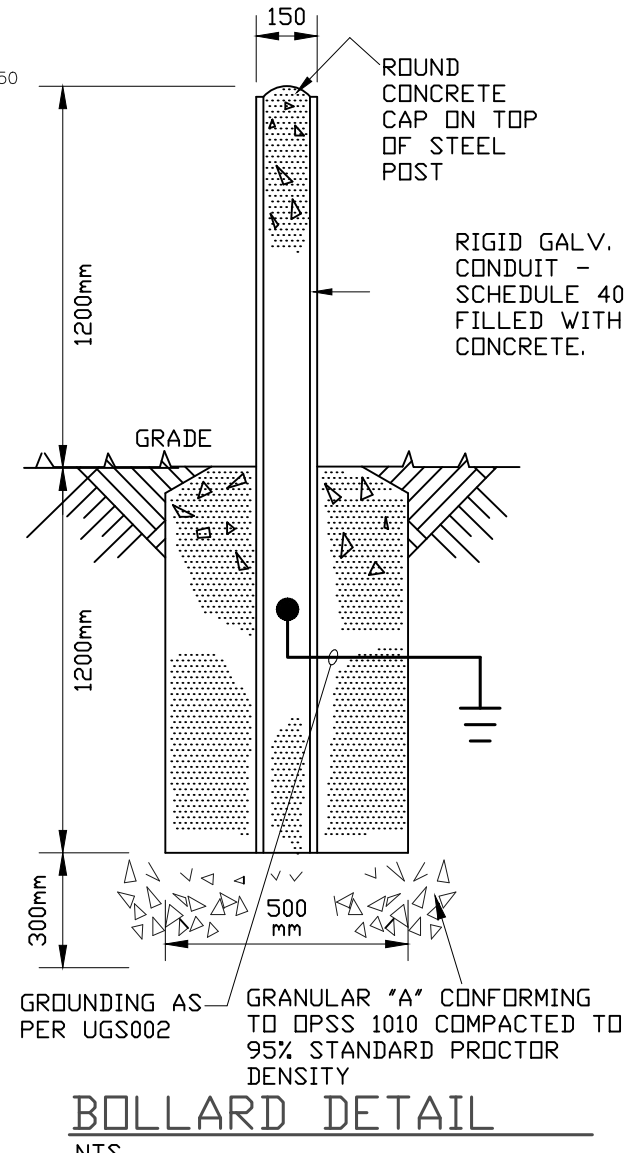


- TELEPHONE (NO PLANK REQUIRED)
- CABLE TV (NO PLANK REQUIRED)
- LIGHTING (NO PLANK REQUIRED)
- POWER (PLANK REQUIRED)

SECONDARY POWER BURIED AS PER THE ONTARIO ELECTRICAL SAFETY CODE TABLE "D11-A" DETAIL-2


TYPICAL TRENCH SEC "A-A"

No. OF RIGID PVC:
TRENCH DETAIL SEC BB INDICATES ONE RIGID PVC CONDUIT AND IS INTENDED FOR BURIAL INFORMATION ONLY. WIDTH OF TRENCH MAY VARY, DEPENDING OF NUMBER & TYPES OF CONDUITS IN EACH TRENCH - REFER TO SITE PLAN FOR NUMBER OF CONDUITS.

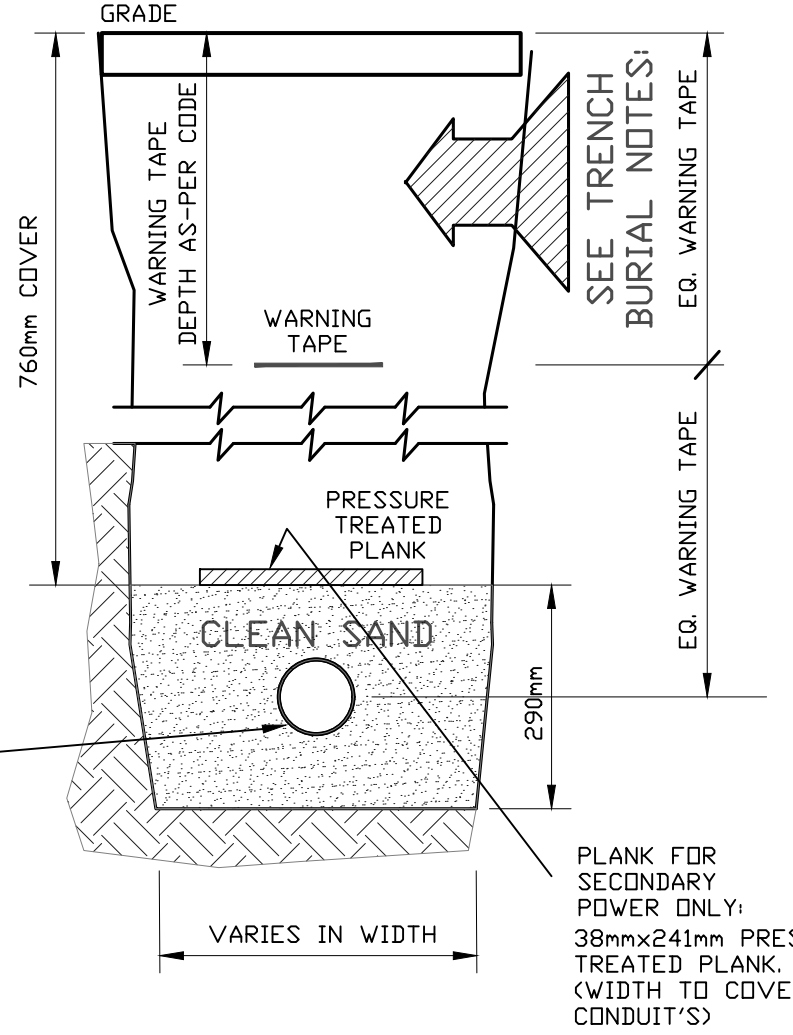

SECTIONS AT CONCRETE CURB POLE LATERAL (3-DUCTS)

3 E-001

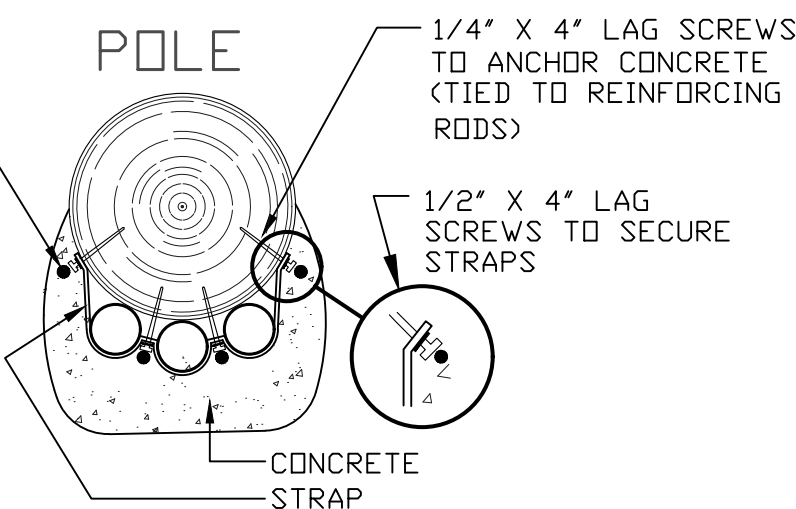

THIS DRAWING, OR PARTS THEREOF, MAY NOT BE REPRODUCED OR USED IN ANY FORM, BY ANY METHOD, FOR ANY PURPOSE, WITHOUT THE WRITTEN PERMISSION OF QUADRANT ENGINEERING.

THIS DRAWING IS TO BE READ IN CONJUNCTION WITH THE SPECIFICATION, WHERE CONFLICT ARISES THE MORE STRINGENT OF THE TWO SHALL APPLY.

COPYRIGHT © 2020 QUADRANT ENGINEERING.

THE ELECTRICAL CONTRACT DOCUMENTS ARE THE PROPERTY OF QUADRANT ENGINEERING (QE).

THE CONTRACTOR SHALL OBTAIN A FULL SET OF ALL CONSULTANTS' DESIGN DOCUMENTS PRIOR TO STARTING WORK.

QE BEARS NO RESPONSIBILITY FOR INTERPRETATIONS OF THESE DOCUMENTS BY OTHERS.

UPON WRITTEN APPLICATION QE WILL PROVIDE WRITTEN CLARIFICATION REGARDING THE INTENT OF THE CONTRACT DOCUMENTS.

QE REVIEW OF SHOP DRAWINGS SUBMITTED BY THE CONTRACTOR IS FOR DESIGN CONFORMANCE ONLY.

DRAWINGS ARE NOT TO BE SCALED FOR CONSTRUCTION. CONTRACTOR TO VERIFY ALL CONDITIONS AND DIMENSIONS, ON SITE, REQUIRED TO PERFORM THE WORK AND REPORT ANY DISCREPANCIES WITH THE CONTRACT DOCUMENTS TO THE DESIGN TEAM BEFORE COMMENCING WORK.

GENERAL NOTES:

TRENCH BURIAL NOTES:

- 1.a. WHEN CROSS ROADWAYS, PARKING LOTS & SIDEWALKS: REINSTATE SURFACE TO MATCH ADJACENT SURFACE.
- 1.b. WHEN CROSSING GRASS: SEEDING OR SOD BY OTHERS.
- 2.a. WARNING TAPE (BURIED AT 300mm) (BELOW FINISHED GRADE)
- 3.a. WHEN CROSSING SIDEWALK OR SOD: APPROVED BACKFILL (AND/OR SCREENED NATIVE FILL)- COMPACTED C/W 150mm SCREENED TOPSOIL TO GRADE.
- 3.b. WHEN CROSSING ROADWAYS OR PARKING LOTS: BACKFILL WITH GRANULAR 'B' FILL- COMPACT TO 95 % PROCTOR IN 150mm LAYERS.

NO.	REVISION	DATE	BY
9			
8			
7			
6			
5			
4			
3			
2	ISSUED FOR COORDINATION	APR 09, 2020	YD
1	ISSUED FOR COORDINATION	APR 01, 2020	YD

MAPLE GROVE TOWNHOUSES
OTTAWA, ONTARIO

QUADRANT
an Intellectric Company
2283 ST. LAURENT BLVD., UNIT 203, OTTAWA, ONT., K1G 5A2
TEL. (613) 567-1487 FAX. (613) 567-1493
E-Mail: mail@quadrantengineering.ca

CURRENT DATE	
Thu, 09 Apr 2020, 16:21	
SCALE	1:200
DRAWN	YD
DESIGNED	YD
CHECKED	LVDL
PROJECT	20-Q015
DRAWING NUMBER	E-001

SITE PLAN