


LEGEND

DRAINAGE AREA X XXX 0.XX

AREA (sq.m)

5 YEAR RUNOFF COEFFICIENT

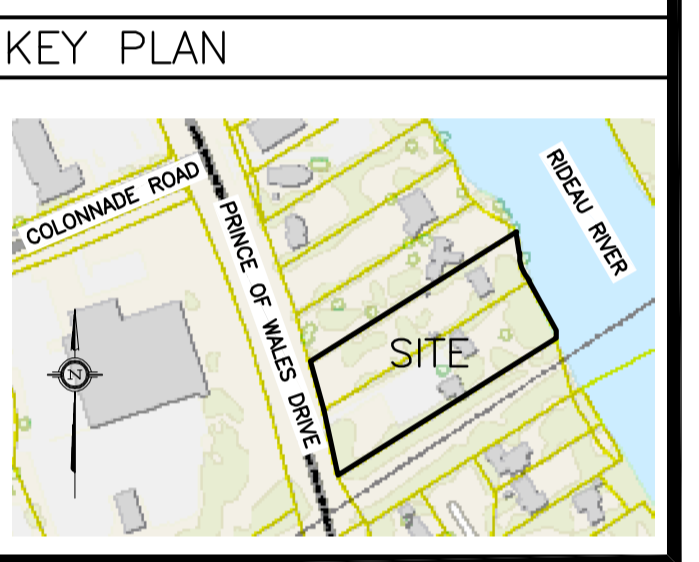

No.	DATE	REVISION
1	JUN 29-23	ISSUED FOR APPROVAL

D. B. GRAY ENGINEERING INC.
 Stormwater Management - Grading & Drainage - Storm & Sanitary Sewers - Watermain
 700 Long Point Circle 613-425-8044
 Ottawa, Ontario d.gray@dbgrayengineering.com

Project: **PROPOSED 7 LOT DEVELOPMENT 2009-2013 PRINCE OF WALES DR OTTAWA, ONTARIO**

POST-DEVELOPMENT DRAINAGE PLANS

Engineer's Seal: Drawn: D.B.G.
 H. Scale: 1:300
 V. Scale:
 Date: JUN 29-23
 Job No.: 22055

Drawing No.: **C-10 of 10**

NOT VALID UNLESS SIGNED & DATED